



- (1) EXISTING ASPHALT PAVING.
- (2) EXISTING GRASS AREA.
- (3) EXISTING CURB.
- (4) EXISTING LIGHT POLE.
- (5) SWING GATE, HARDWARE AND OPERATOR.
- (6) CARD READER AND PEDESTAL - REFER TO ELECTRICAL DRAWINGS FOR ADDITIONAL DETAIL.
- (7) NEW FIRE HYDRANT - SEE CIVIL DRAWINGS.
- (8) NEW ADD ALTERNATE GENERATOR ENCLOSURE AND BELLY TANK.
- (9) NEW CONDENSING UNITS ON CONCRETE PAD. - REFER TO MECHANICAL & STRUCTURAL DRAWINGS FOR DETAILS.
- (10) EXISTING BOLLARD.
- (11) NEW 6" DIA. BOLLARD, TYP.
- (12) NEW UTILITY TRANSFORMER-REFER TO ELECTRICAL DRAWINGS.
- (13) EXISTING CONDENSER UNIT
- (14) NEW BACK-UP GENERATOR ENCLOSURE WITH BELLY TANK.
- (15) NEW CONCRETE CURB. - REFER TO CIVIL DRAWINGS FOR DETAILS.
- (16) NEW CONCRETE PAD AT DOOR. - REFER TO CIVIL DRAWINGS FOR DETAILS.
- (17) DAY ONE HVAC UNIT. - REFER TO MECHANICAL DRAWINGS.
- (18) "ADD ALTERNATE" HVAC UNIT. - REFER TO MECHANICAL DRAWINGS.
- (19) NEW CONCRETE PAD FOR AHU'S. - REFER TO STRUCTURAL DRAWINGS. TOP OF PAD 83.5'
- (20) NEW TEMP IN/UP BOXES - REFER TO ELECTRICAL DRAWINGS FOR ADD'L INFORMATION.
- (21) EXISTING UTILITY TRANSFORMER
- (22) FILL FILL PORTS MOUNTED AT NEW GEN PAD AND BELLY TANKS.
- (23) CONCRETE RETAINING WALL
- (24) NEW CMU SCREENWALL
- (25) EXISTING CMU SCREENWALL
- (26) NEW HW DOOR

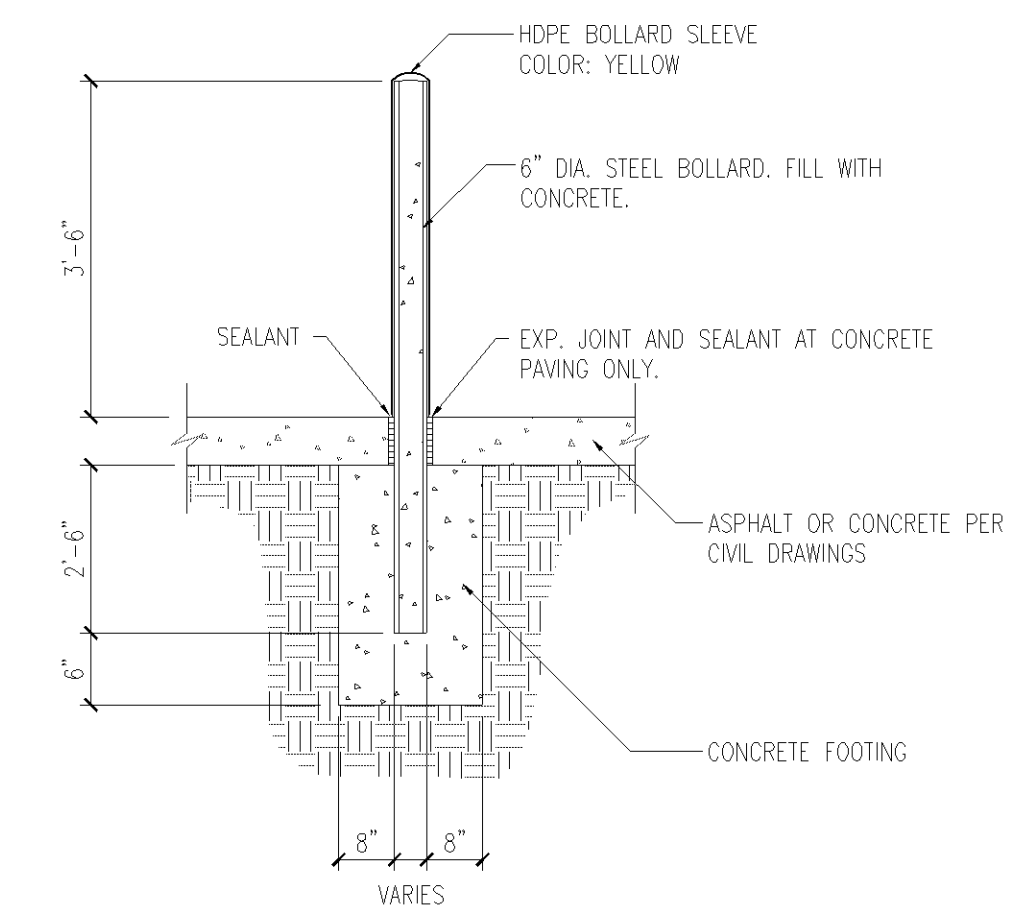


2 BOLLARD DETAIL
A101 SCALE: 1/2" = 1'-0"


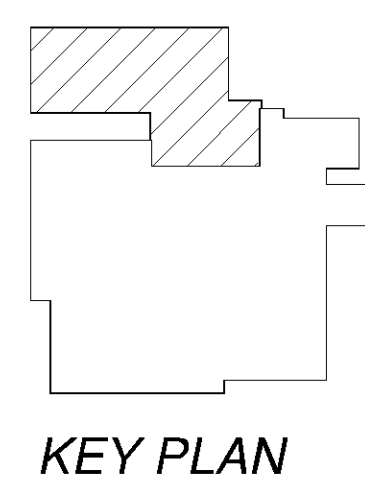


verizon[✓]
BLOOMINGTON MSC EXPANSION
10801 BUSH LAKE ROAD
BLOOMINGTON, MN.

SHEET NUMBER **A101**

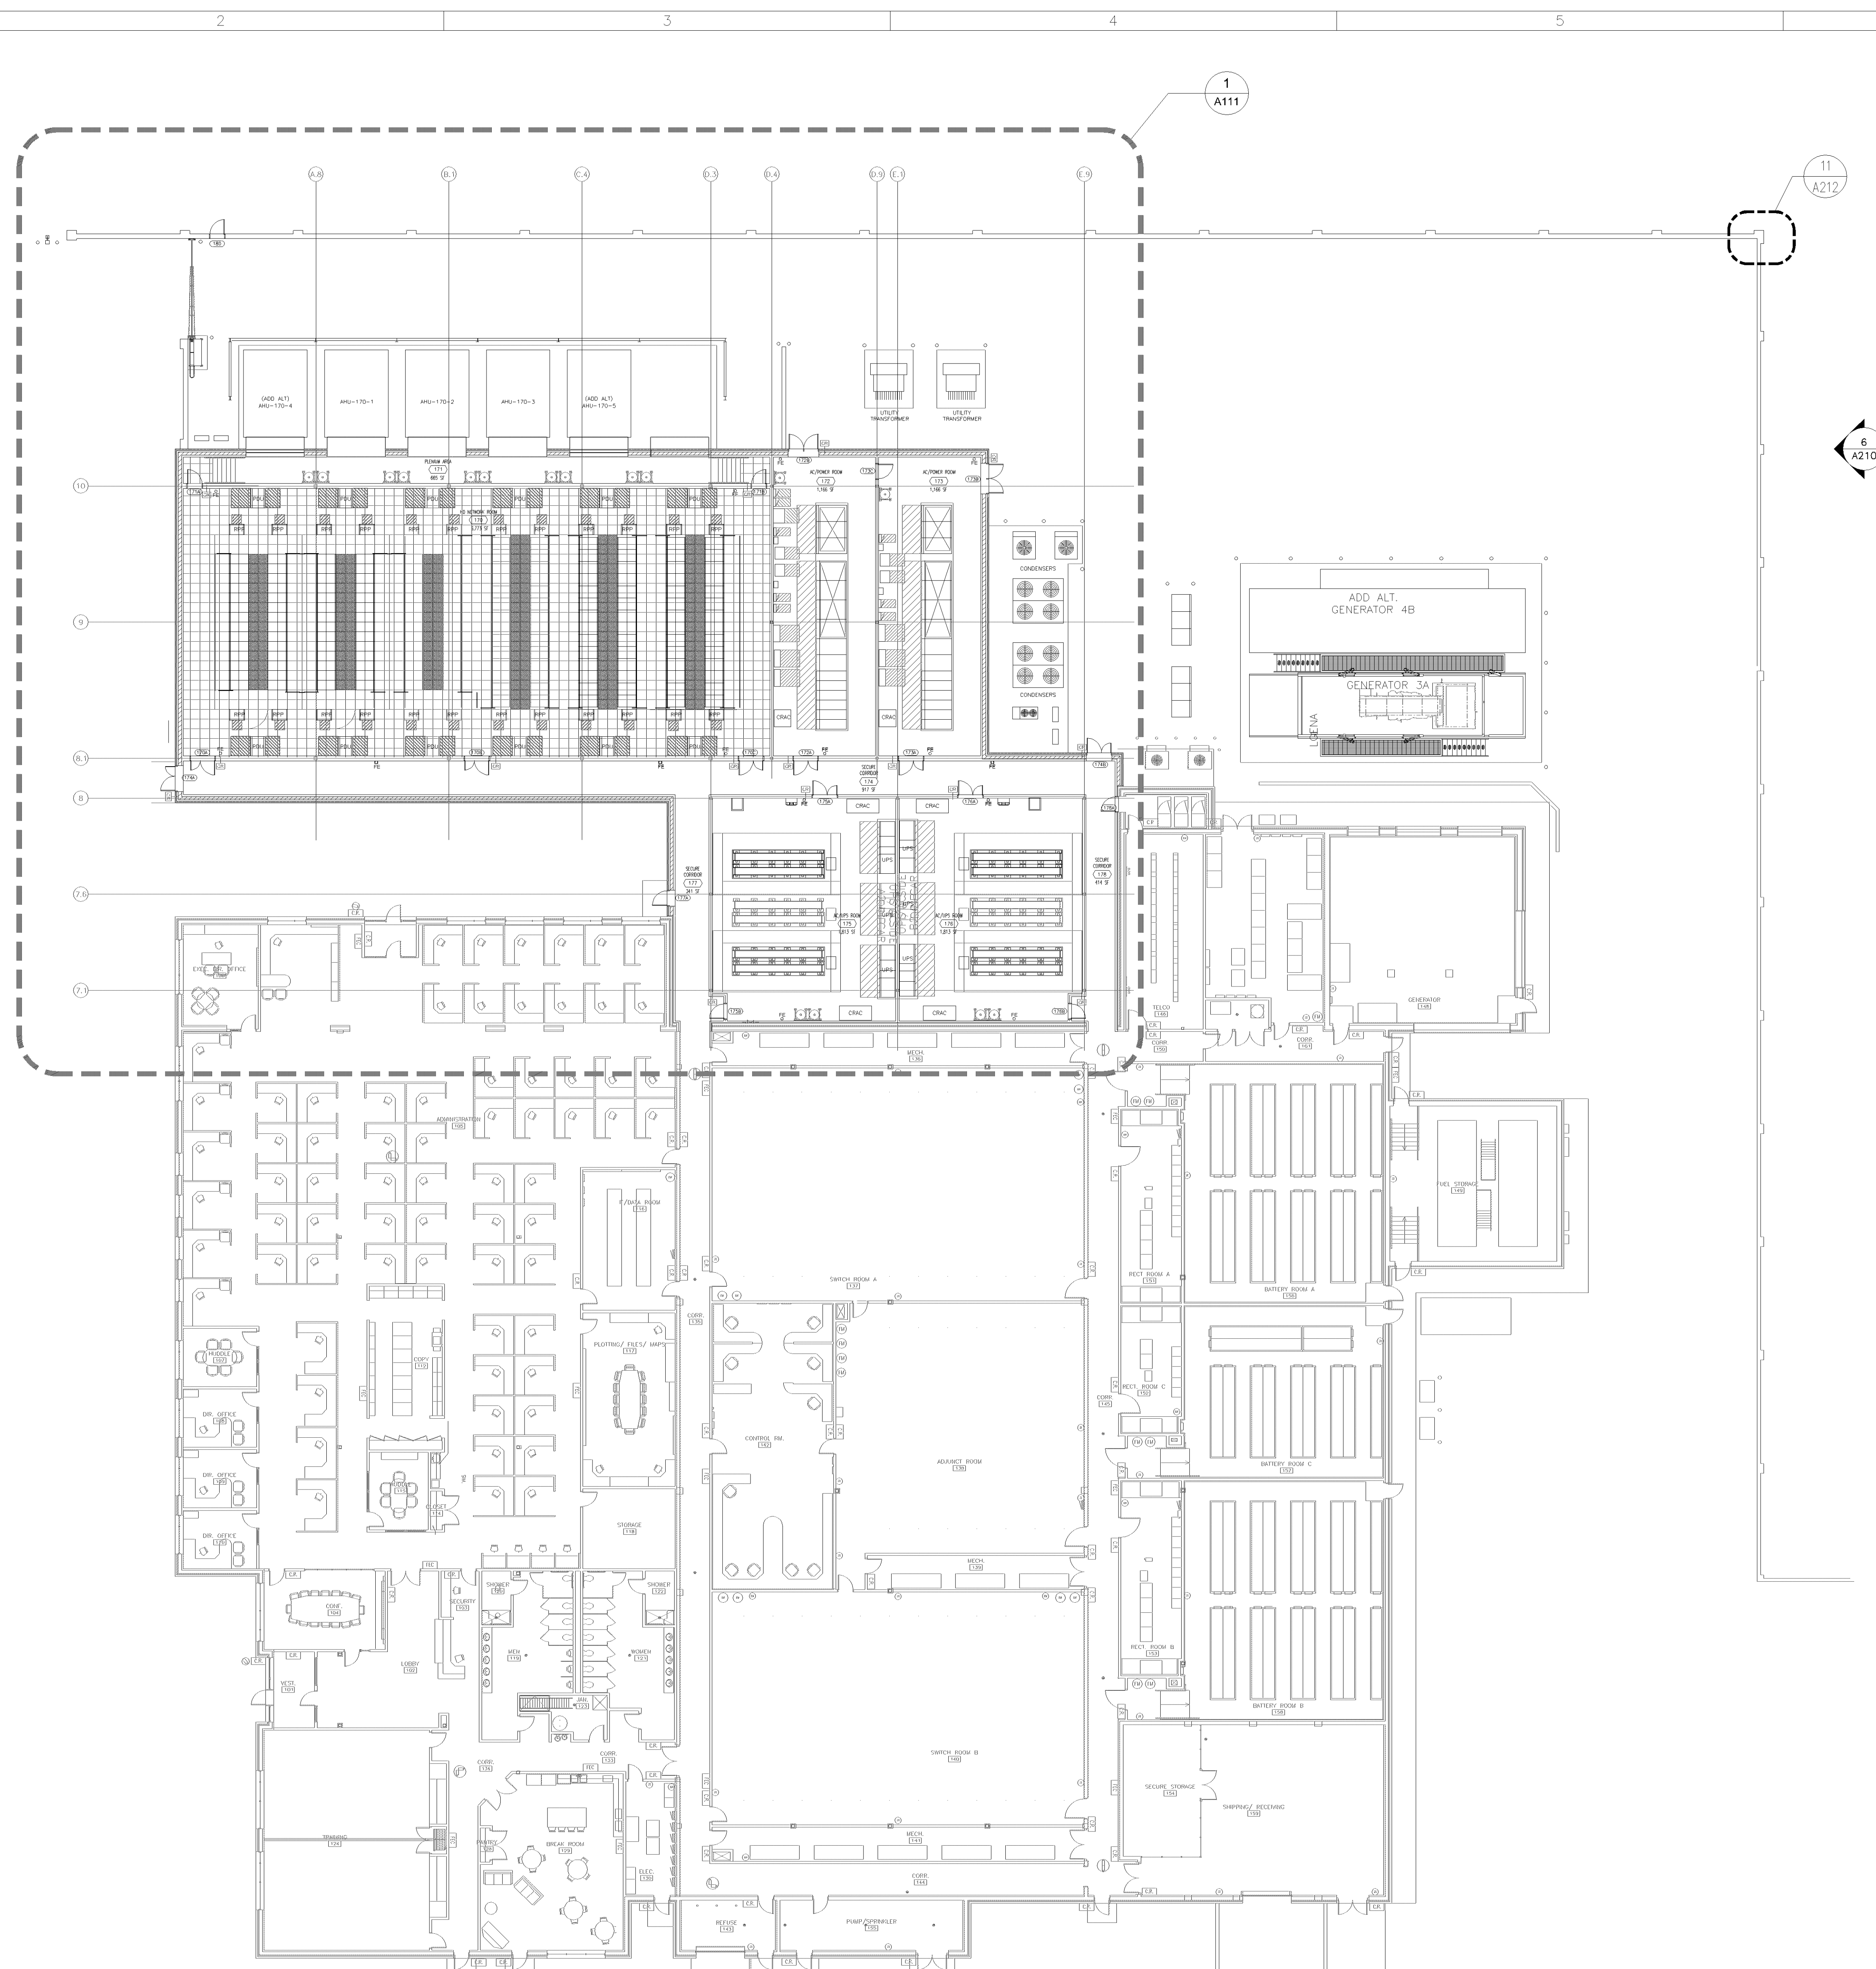

1 OVERALL FLOOR PLAN
A110 SCALE: 1/16" = 1'-0"

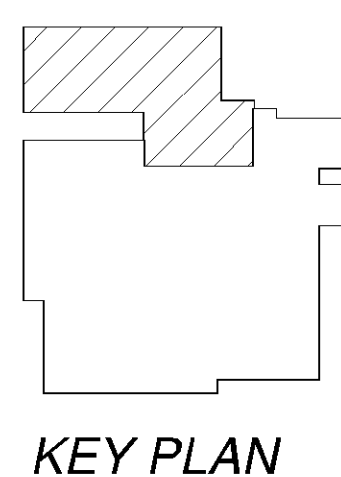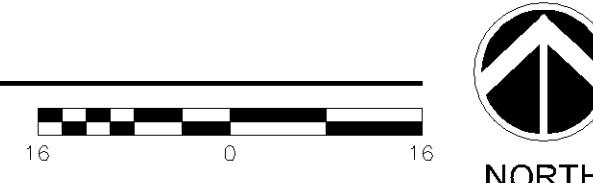

verizon[✓]

This drawing was prepared solely for the use of Verizon Wireless and must only be used by Verizon Wireless employees, contractors, and vendors while performing the work shown on this drawing. Any other use of this drawing is forbidden.

m MORRISON HERSHFIELD
MISSION CRITICAL
1455 LINCOLN PARKWAY, SUITE 500
ATLANTA, GA 30346
TEL: 770.379.8500 FAX: 770.379.8501
WWW.MORRISONHERSHFIELD.COM

Do not scale drawings. Contractor must verify all dimensions and advise Consultants of any errors or omissions. No variations or modifications to work shown shall be implemented without prior written approval. All previous issues of this drawing are superseded by the latest revision. All drawings and specifications remain the property of Morrison Hershfield Corporation.

SURCONSULTANT

verizon[✓]
BLOOMINGTON MSC EXPANSION
10801 BUSH LAKE ROAD
BLOOMINGTON, MN.

[illegible]


NETWORK COMPLIANCE SUBMITTALS	DATE
ISSUED FOR PRELIMINARY REVIEW	04/24/2020
ISSUED FOR 30% SUBMISSION	06/29/2020
ISSUED FOR 60% SUBMISSION	07/24/2020
ISSUED FOR 90% SUBMISSION	09/21/2020

PROJECT NO:	200174900	STAMP
CAD DWG FILE:	A110	
DESIGNED BY:	JP	
DRAWN BY:	KNC	
CHECKED BY:	KM	
COPYRIGHT:	MAY 2020	

SHEET TITLE

OVERALL FLOOR PLAN

SHEET NUMBER **A110**

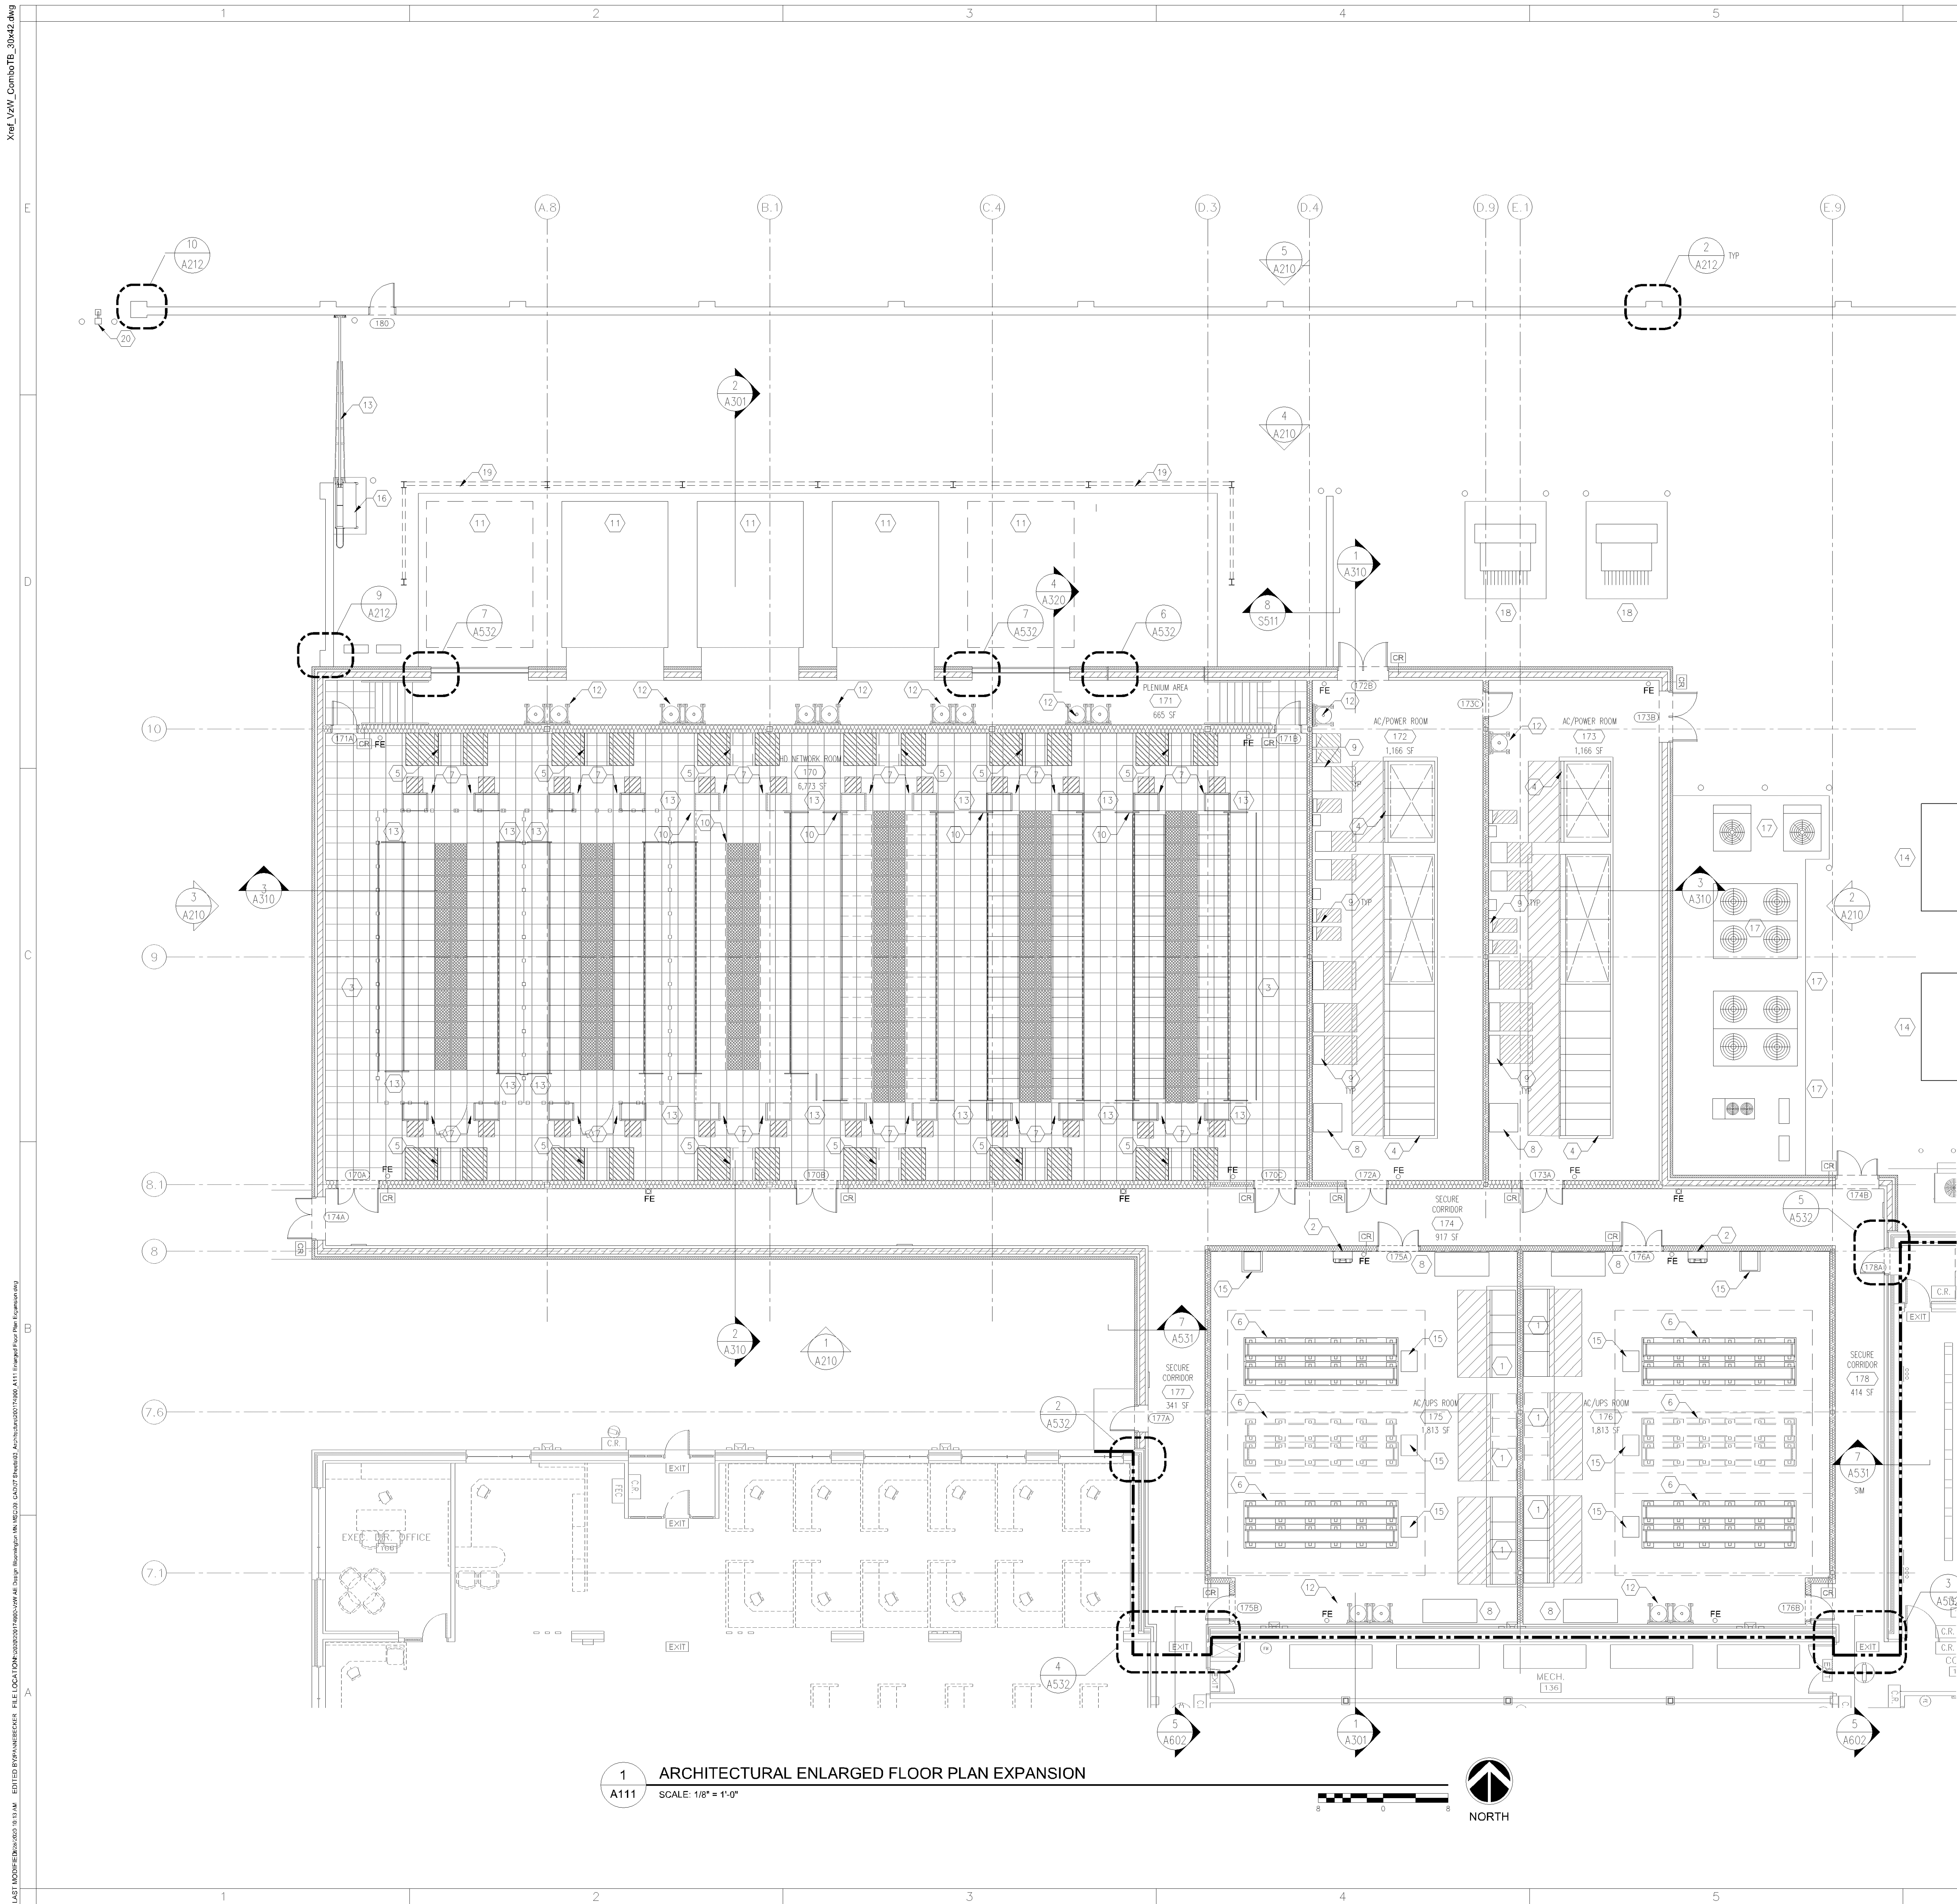

1 ARCHITECTURAL ENLARGED FLOOR PLAN EXPANSION
SCALE: 1/8" = 1'-0"

SHEET NOTES


- SEE SHEETS 0100 FOR ALL EQUIPMENT, EQUIPMENT DIMENSIONAL LOCATIONS AND REQUIRED CLEARANCES.
- SEE SHEETS A120 FOR DIMENSIONS.
- SEE SHEETS A550 AND A551 FOR SIGNAGE REQUIREMENTS.
- ALL CONSTRUCTION MATERIALS SHALL BE NON COMBUSTIBLE (CLASS A FLAME SPREAD) AND FIRE RETARDANT TREATED WOOD.

KEY NOTES

- UPS MODULE, SEE ELECTRICAL DRAWINGS.
- PERSONAL EYEWASH STATION
- RAISED ACCESS FLOOR
- ELECTRICAL SWITCHGEAR, SEE ELECTRICAL DRAWINGS
- PDU, SEE ELECTRICAL DRAWINGS
- BATTERY STRINGS, SEE ELECTRICAL DRAWINGS
- RPP, SEE ELECTRICAL DRAWINGS.
- MECHANICAL UNIT, SEE MECHANICAL DRAWINGS
- ELECTRICAL EQUIPMENT, SEE ELECTRICAL DRAWINGS.
- HOT ASLE CONTAINMENT
- OUTSIDE AIR HANDLING UNIT, SEE MECHANICAL DRAWINGS
- CLEAN AGENT TANK - REFER TO FIRE PROTECTION DRAWINGS FOR DETAILS.
- GATE - SEE DETAIL 7/A212
- TAP BOXES AND DISCONNECTS ON 'H' FRAME. SEE ELECTRICAL DRAWINGS.
- MAIN BATTERY DISCONNECT
- GATE OPERATOR
- OUTSIDE AIR CONDENSER UNIT - SEE MECHANICAL DRAWINGS
- UTILITY TRANSFORMER
- SOUND CONTROL BARRIER - SEE DETAIL 8/A212 AND SPECIFICATION 323516
- CARD READER PERISTAL - SEE SECURITY DRAWINGS

LEGEND

- DOOR TAG
- CARD READER (NEW)
- BRACKET MOUNTED FIRE EXTINGUISHER, SEE SPECIFICATIONS.
- SEMI RECESSED FIRE EXTINGUISHER/CABINET SEE FIREPROTECTION FOR SIZE & TYPE.
- CLEAN AGENT TANK
- BRUSHED STAINLESS STEEL CORNER GUARD - START GUARD ABOVE BASE, TOP OF GUARD TO BE AT 4'-0" AFF
- ADA CLEARANCE REQUIREMENTS AT ALL DOORS
- SCOPE OF WORK LIMIT LINE
- EXISTING CONSTRUCTION TO REMAIN
- NEW DWS CONSTRUCTION, SEE SHEET A120 FOR WALL TYPE TAGS
- INDICATES PROPOSED LOCATION OF TEMPORARY PARTITION. ACCESS TO ALL BUILDING EXITS TO BE MAINTAINED.
- EMERGENCY EXIT ROUTE SIGNAGE LOCATION SEE DETAIL 6/A550

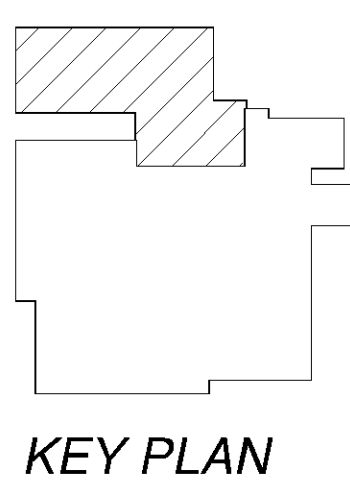

verizon

This drawing was prepared solely for the use of Verizon Wireless and must only be used by Verizon Wireless employees, contractors, and vendors while performing the work shown on this drawing. Any other use of this drawing is forbidden.

MORRISON HERSHFIELD
MISSION CRITICAL
1455 LINCOLN PARKWAY, SUITE 500
ATLANTA, GA 30346
TEL: 770.379.8500 FAX: 770.379.8501
WWW.MORRISONHERSFIELD.COM

SUBCONSULTANT

verizon
BLOOMINGTON MSC EXPANSION
10801 BUSH LAKE ROAD
BLOOMINGTON, MN.

REV	DESCRIPTION	DATE

NETWORK COMPLIANCE SUBMITTALS	DATE
ISSUED FOR PRELIMINARY REVIEW	04/24/2020
ISSUED FOR 50% SUBMISSION	05/29/2020
ISSUED FOR 90% SUBMISSION	07/24/2020
ISSUED FOR 95% SUBMISSION	08/21/2020


PROJECT NO:	200114800	STAMP
CAD DWG FILE:	A111	
DESIGNED BY:	JH	
DRAWN BY:	KNC	
CHECKED BY:	KM	
COPYRIGHT:	MAY 2020	

SHEET TITLE
ENLARGED FLOOR PLAN EXPANSION

SHEET NUMBER
A111

Xref_Vis_Vis_CombiTB_20x42.dwg

LAST MODIFIED: 05/20/2015 1:14 PM EDITED: BPP/ANDES/CDR FILE LOCATION: C:\PROJECTS\10801 BUSH LAKE\Bldg Elevations\A210.dwg

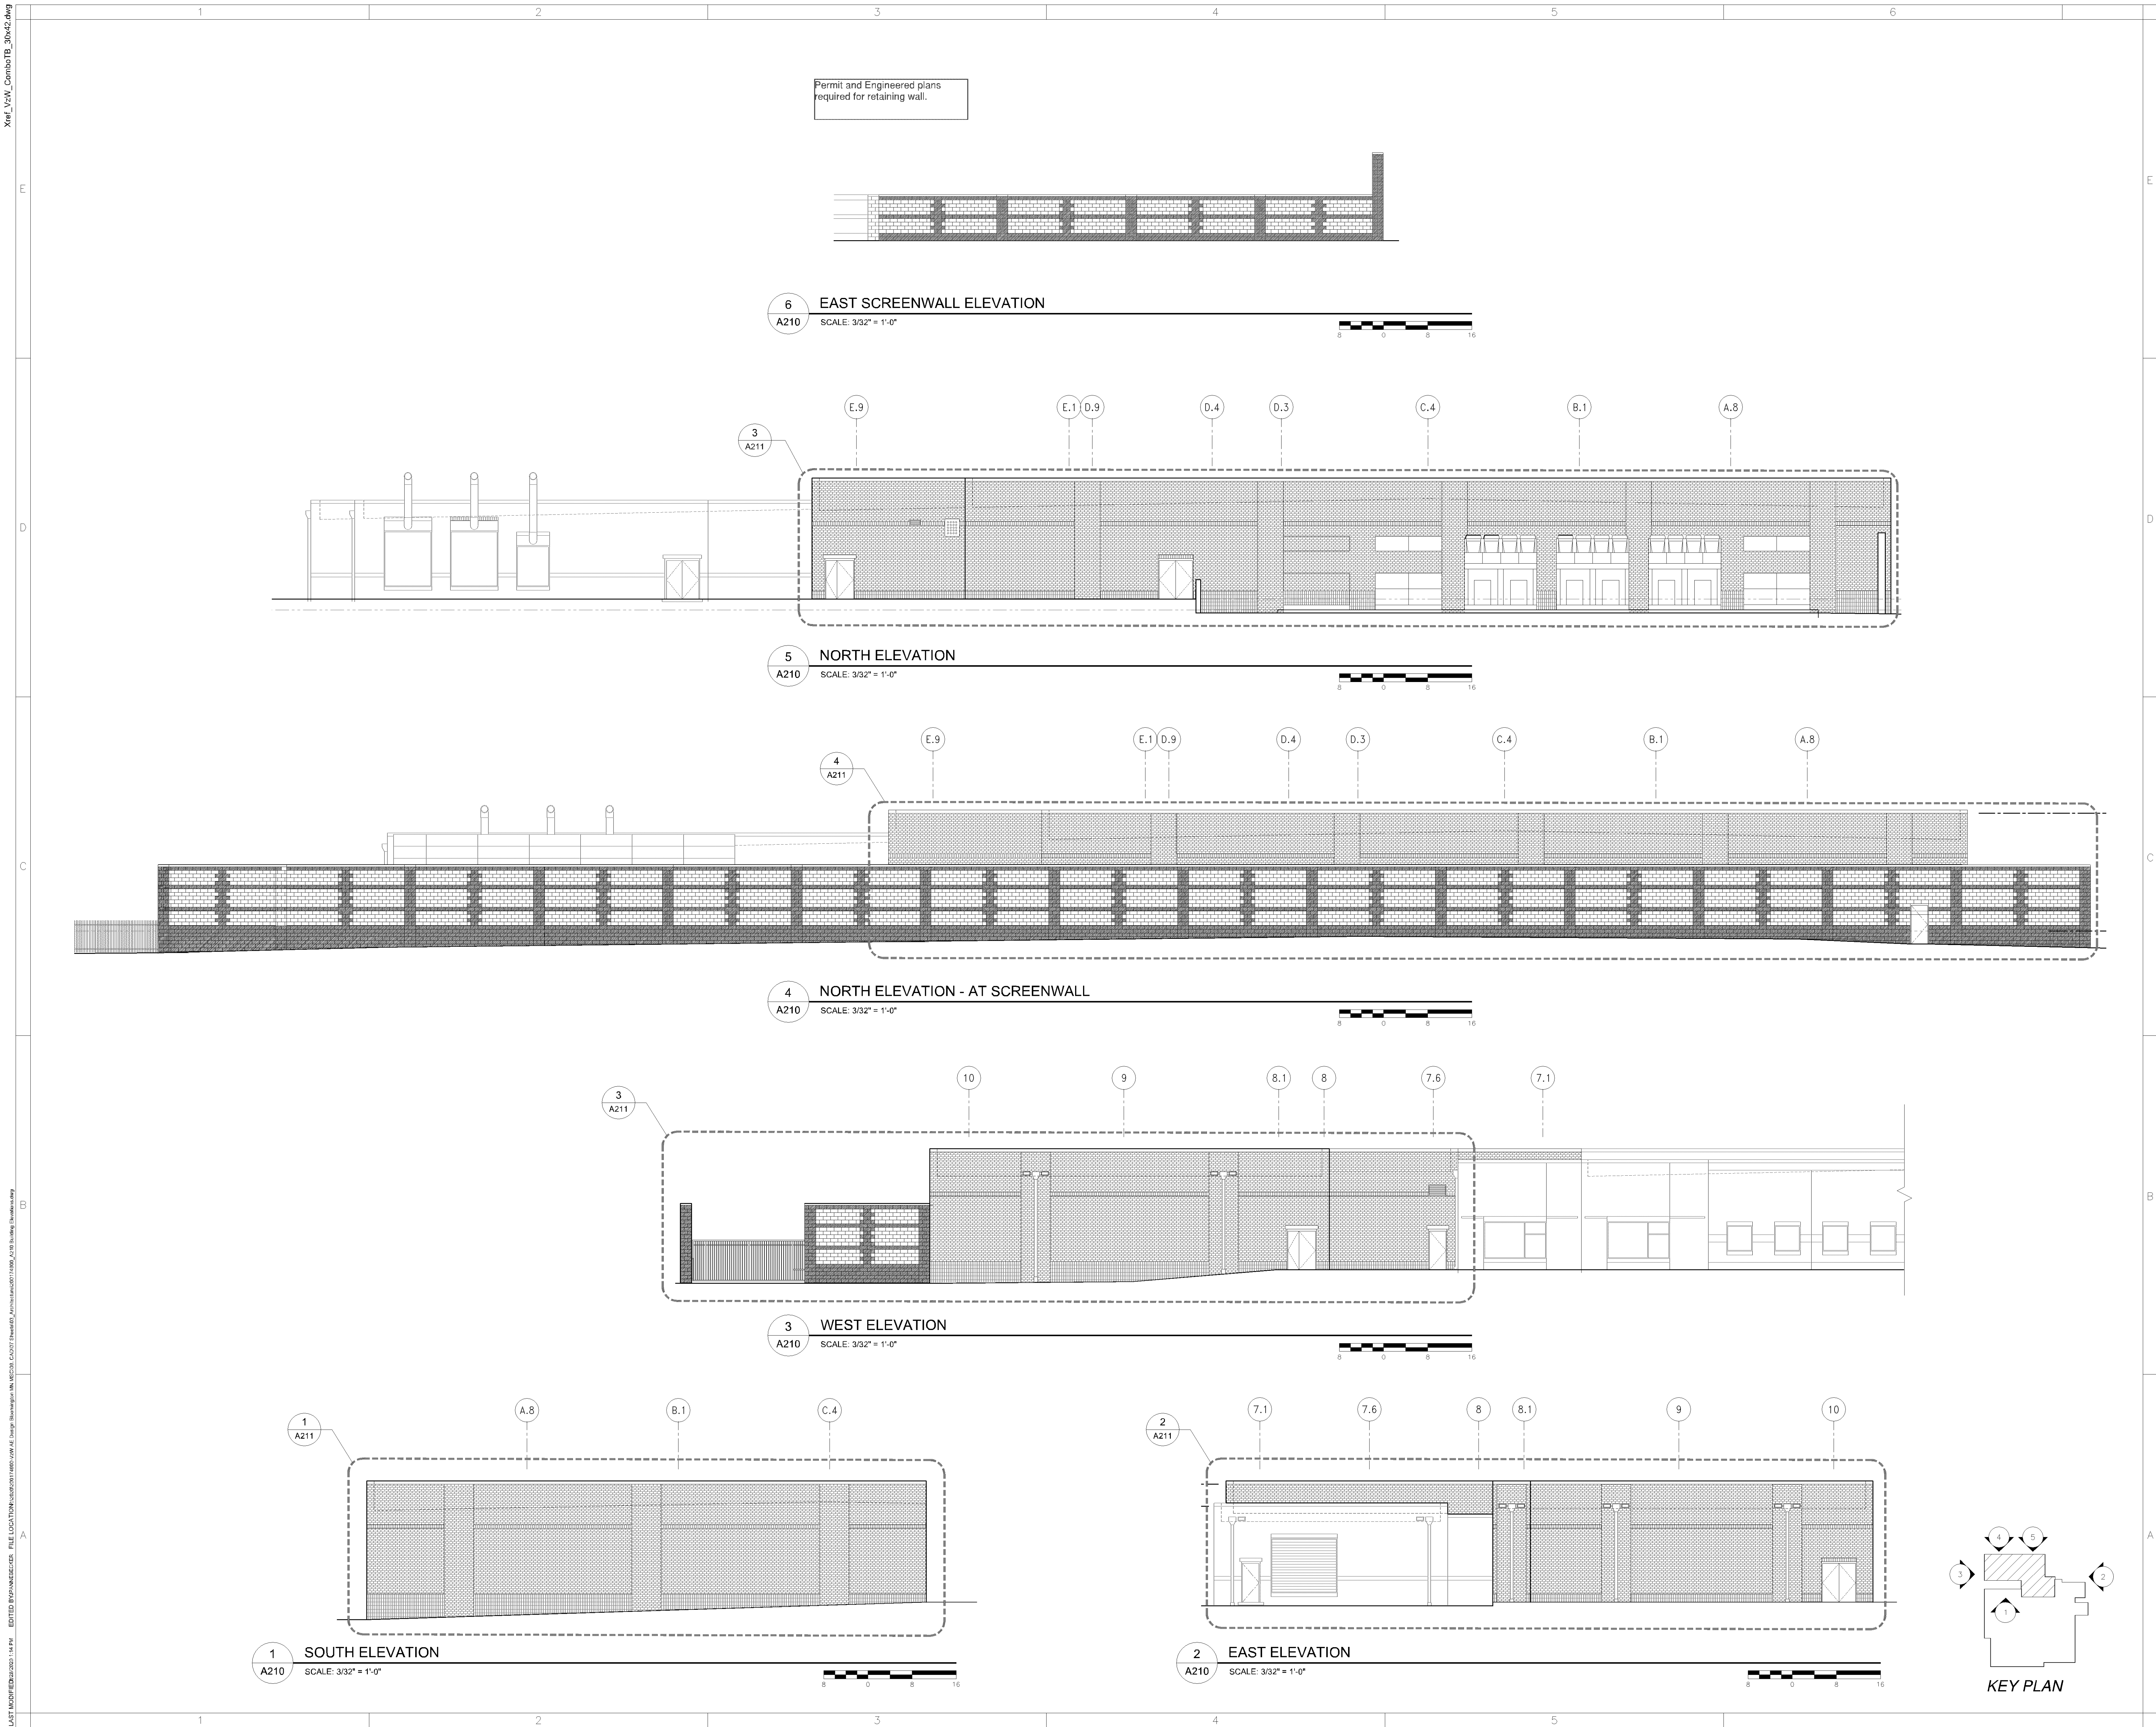

verizon
This drawing was prepared solely for the use of Verizon Wireless, and must only be used by Verizon Wireless employees, contractors, and vendors while performing the work shown on this drawing. Any other use of this drawing is forbidden.

MORRISON HERSHFELD
MISSION CRITICAL
1455 LINCOLN PARKWAY, SUITE 500
ATLANTA, GA 30346
TEL: 770.379.8500 FAX: 770.379.8501
WWW.MORRISONHERSHFIELD.COM

Do not scale drawings. Contractor must verify all dimensions and advise Consultants of any errors or omissions. No variations or modifications to work shown shall be implemented without prior written approval. All previous issues of this drawing are superseded by the latest revision. All drawings and specifications remain the property of Morrison Hershfield Corporation.

SUBCONSULTANT


verizon
BLOOMINGTON MSC EXPANSION
10801 BUSH LAKE ROAD
BLOOMINGTON, MN.

REV	DESCRIPTION	DATE

NETWORK COMPLIANCE SUBMITTALS	DATE
ISSUED FOR PRELIMINARY REVIEW	04/24/2010
ISSUED FOR 30% SUBMISSION	05/29/2010
ISSUED FOR 60% SUBMISSION	07/24/2010
ISSUED FOR 90% SUBMISSION	08/21/2010

PROJECT NO:	201174000	STAMP
CAD DWG FILE:	A210	
DESIGNED BY:	JP	
DRAWN BY:	KNC	
CHECKED BY:	KM	
COPYRIGHT:	MAY 2010	

SHEET TITLE
BUILDING ELEVATIONS
SHEET NUMBER
A210

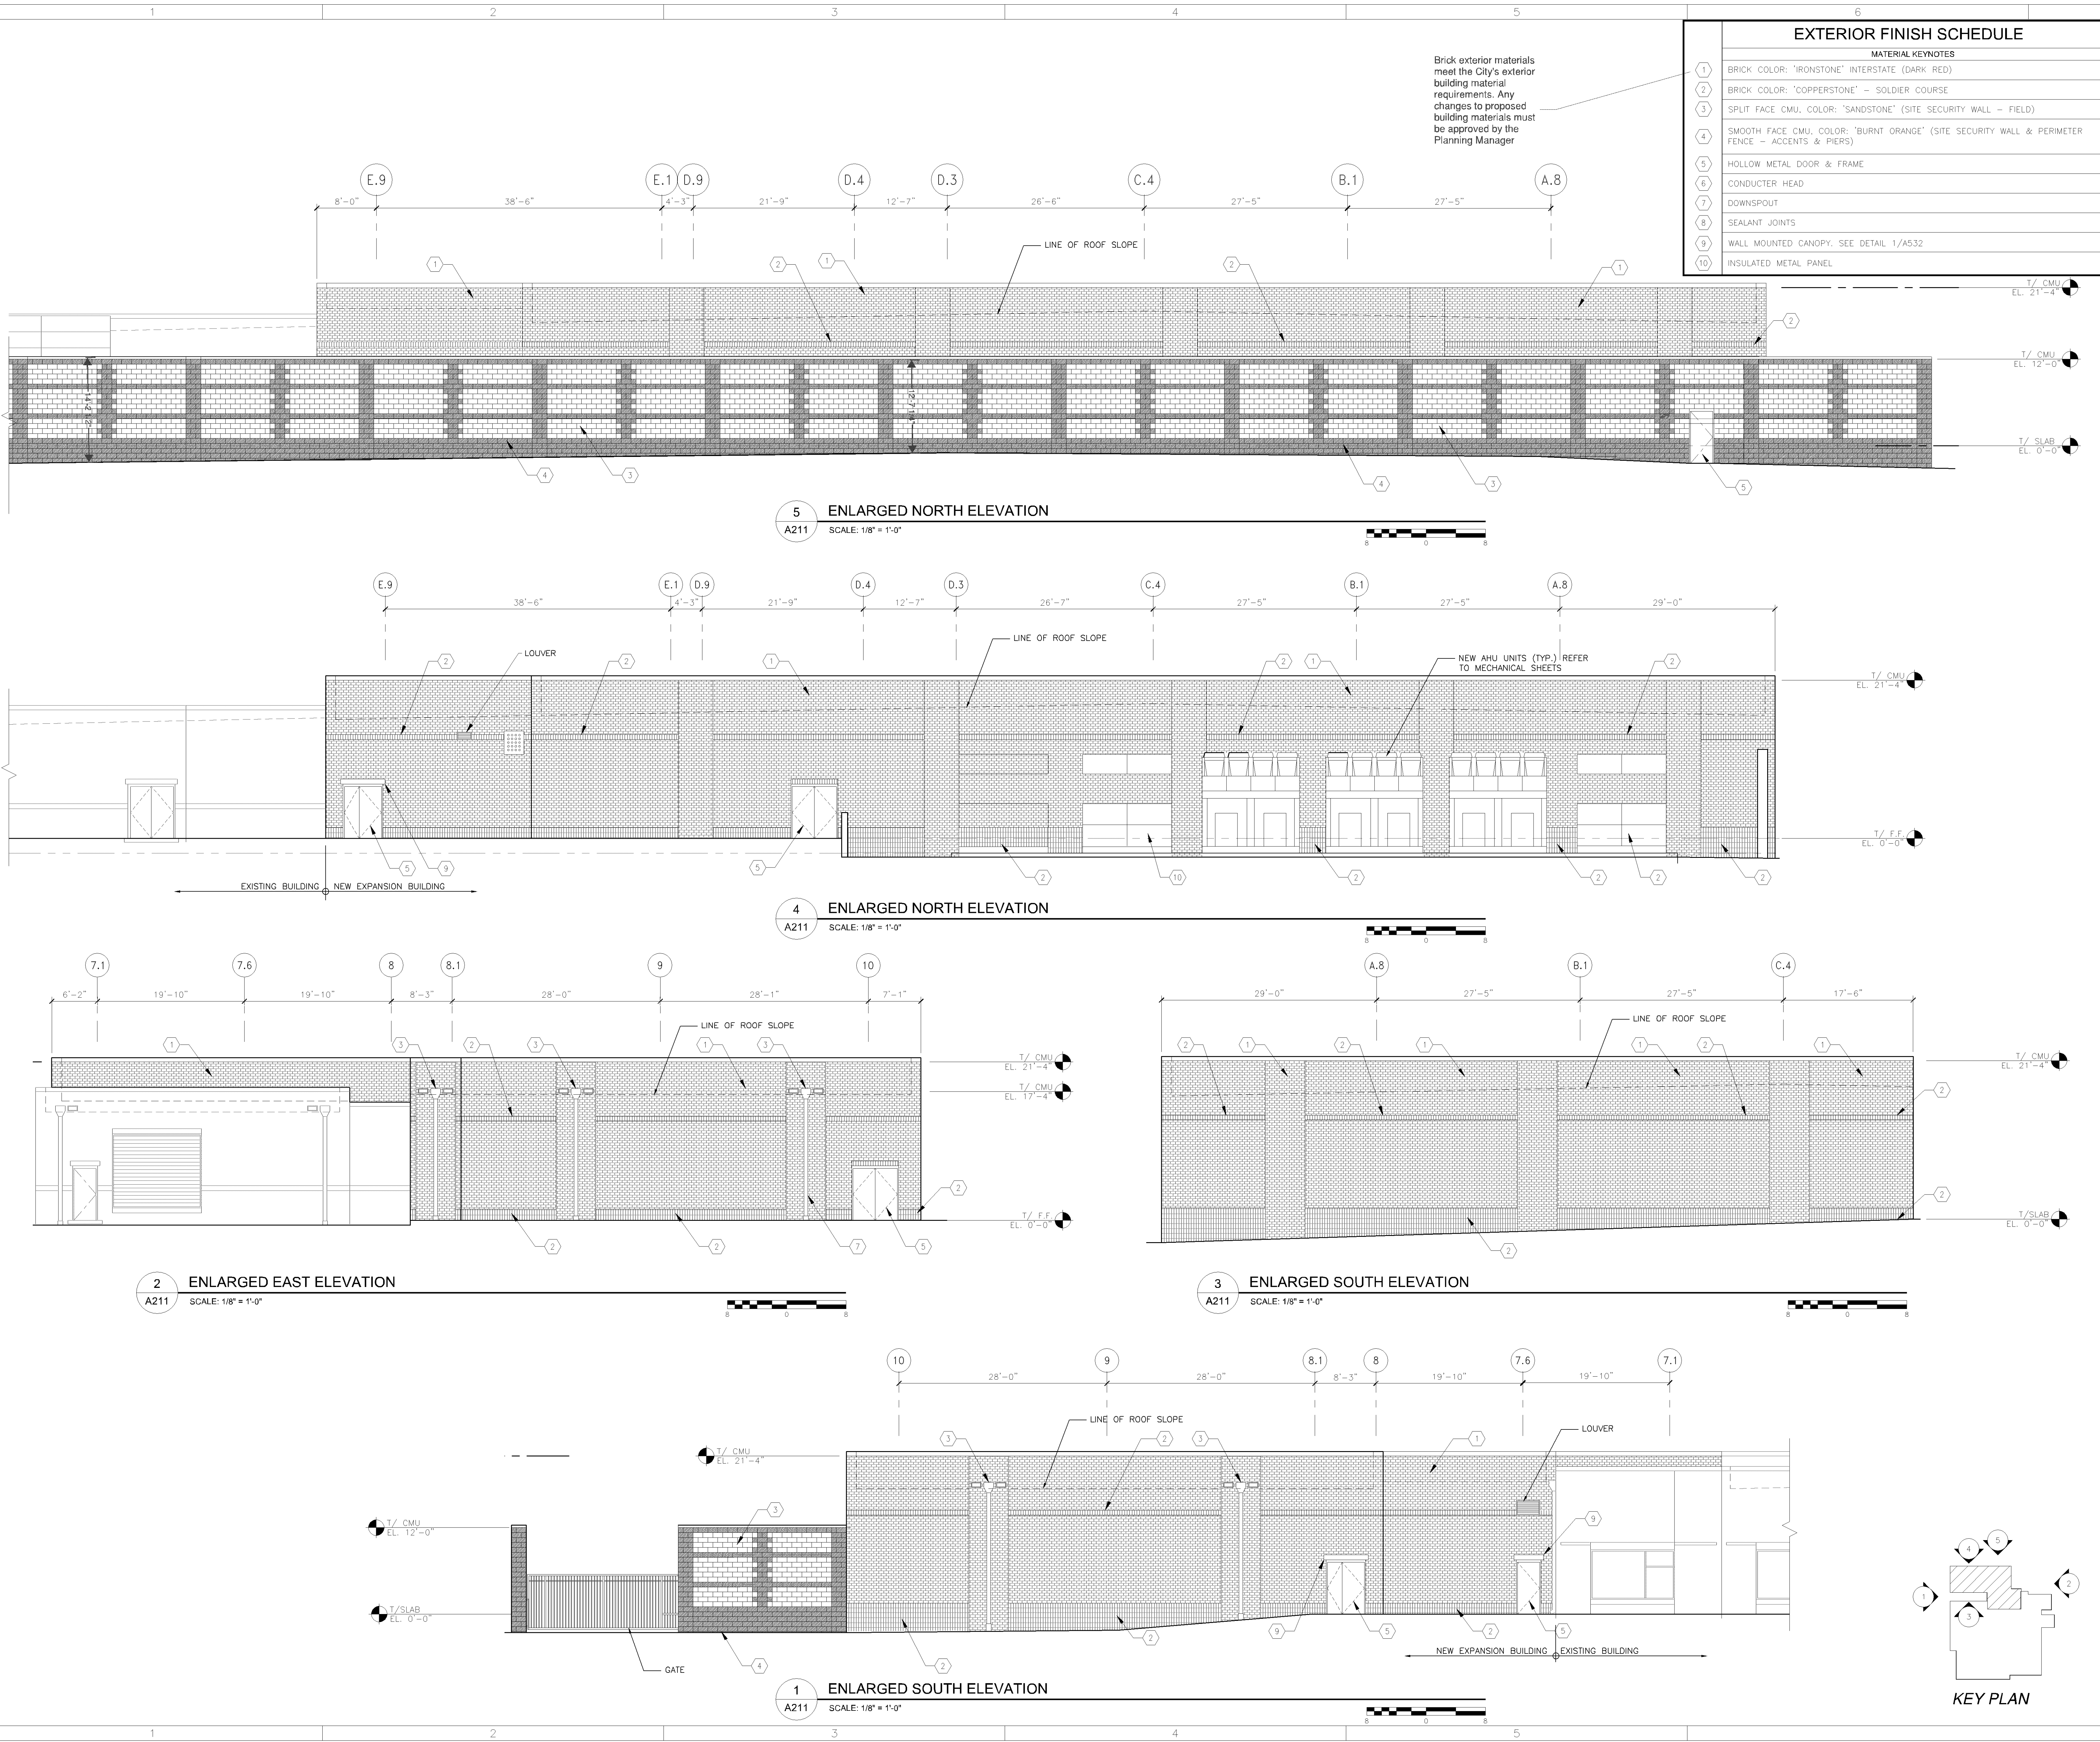

EXTERIOR FINISH SCHEDULE	
MATERIAL KEYNOTES	
1	BRICK COLOR: "IRONSTONE" INTERSTATE (DARK RED)
2	BRICK COLOR: "COPPERSTONE" - SOLDIER COURSE
3	SPLIT FACE CMU, COLOR: "SANDSTONE" (SITE SECURITY WALL - FIELD)
4	SMOOTH FACE CMU, COLOR: "BURNT ORANGE" (SITE SECURITY WALL & PERIMETER FENCE - ACCENTS & PIERS)
5	HOLLOW METAL DOOR & FRAME
6	CONDUCTOR HEAD
7	DOWNSPOUT
8	SEALANT JOINTS
9	WALL MOUNTED CANOPY, SEE DETAIL 1/A532
10	INSULATED METAL PANEL

verizon

This drawing was prepared solely for the use of Verizon Wireless and must only be used by Verizon Wireless employees, contractors, and vendors while performing the work shown on this drawing. Any other use of this drawing is forbidden.

m MORRISON HERSHFIELD
MISSION CRITICAL
1455 LINCOLN PARKWAY, SUITE 500
ATLANTA, GA 30346
TEL: 770.379.8500 FAX: 770.379.8501
WWW.MORRISONHERSFIELD.COM

Do not scale drawings. Contractor must verify all dimensions and advise Consultants of any errors or omissions. No variations or modifications to work shown shall be implemented without prior written approval. All previous issues of this drawing are superseded by the latest revision. All drawings and specifications remain the property of Morrison Hershfield Corporation.

SUBCONSULTANT

verizon

BLOOMINGTON MSC EXPANSION
10801 BUSH LAKE ROAD
BLOOMINGTON, MN.

REV	DESCRIPTION	DATE

NETWORK COMPLIANCE SUBMITTALS	DATE
ISSUED FOR PRELIMINARY REVIEW	04/24/2016
ISSUED FOR 30% SUBMISSION	05/26/2016
ISSUED FOR 60% SUBMISSION	07/14/2016
ISSUED FOR 80% SUBMISSION	08/21/2016

PROJECT NO: 201174000	STAMP
CAD DWG FILE: A211	
DESIGNED BY: JP	
DRAWN BY: KNC	
CHECKED BY: KM	
COPYRIGHT: MAY 2016	

SHEET TITLE
ENLARGED BUILDING ELEVATIONS
SHEET NUMBER
A211