



PL202000166
PL2020-166

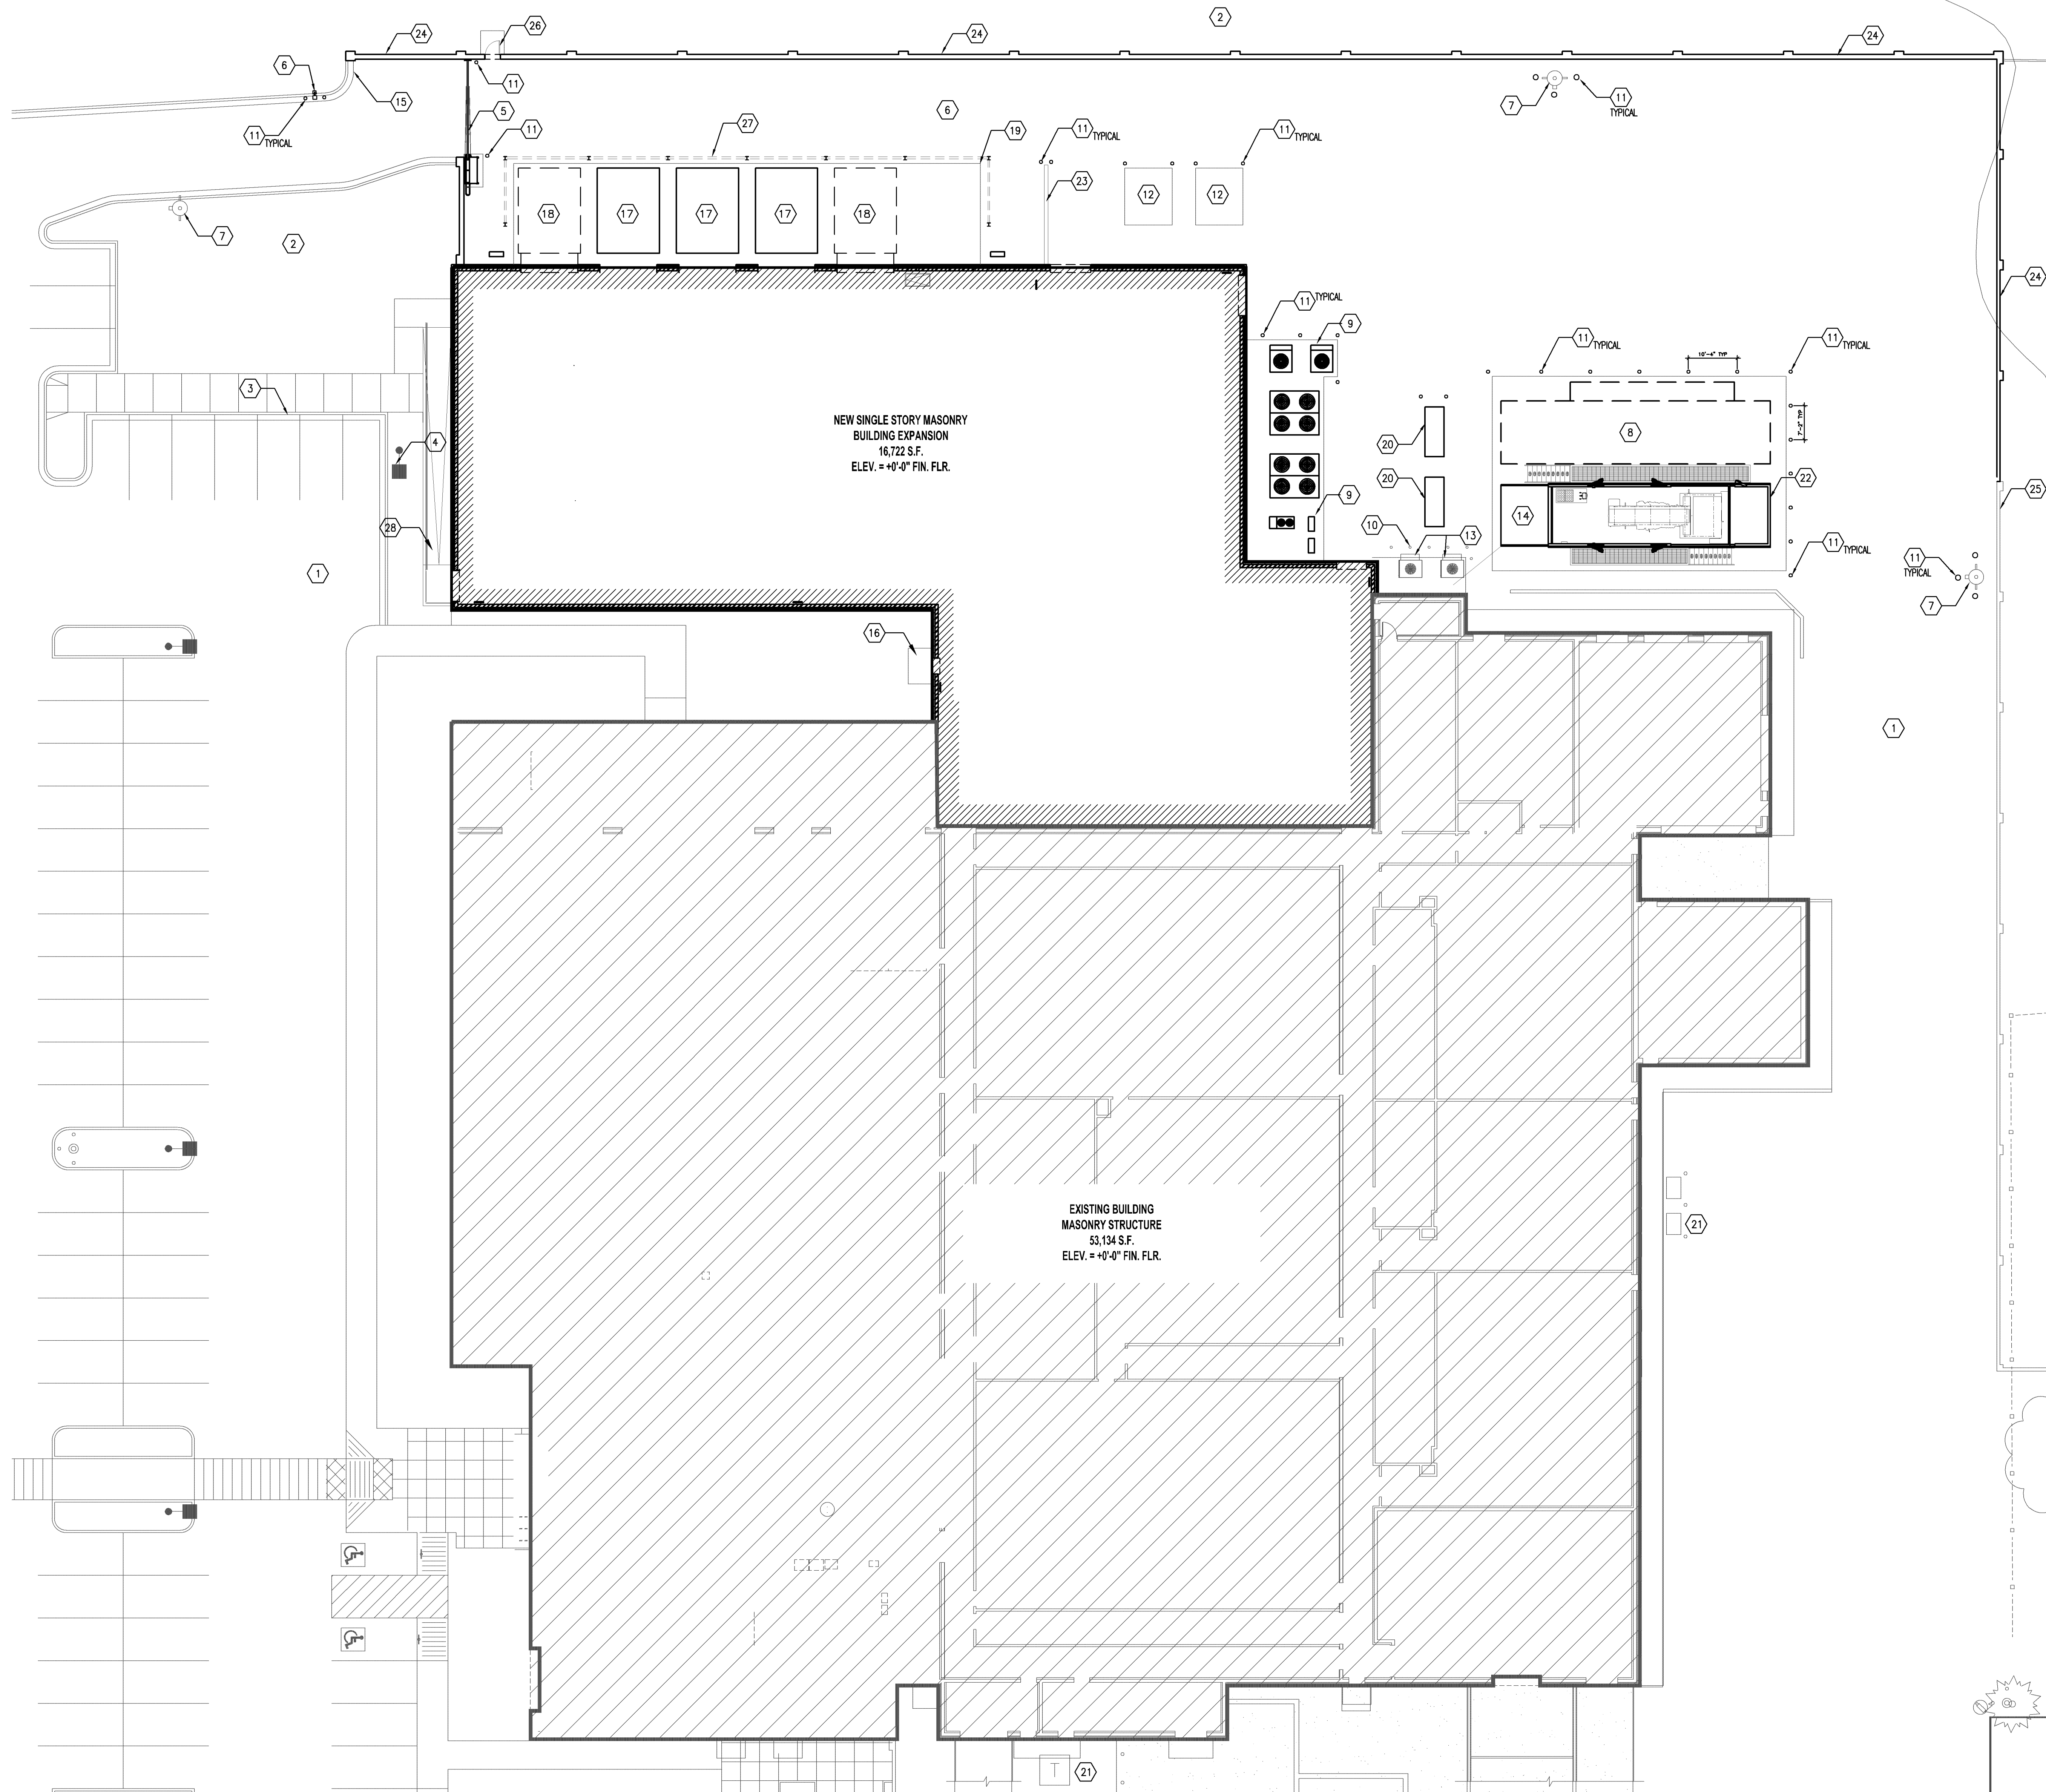

KEY NOTES

- 1 EXISTING ASPHALT PAVING.
- 2 EXISTING GRASS AREA.
- 3 EXISTING CURB.
- 4 EXISTING LIGHT POLE.
- 5 VERTICAL PIVOT GATE, HARDWARE AND OPERATOR.
- 6 CARD READER AND PEDESTAL. REFER TO ELECTRICAL DRAWINGS FOR ADDITIONAL DETAIL.
- 7 NEW FIRE HYDRANT. - SEE CIVIL DRAWINGS
- 8 NEW ADD ALTERNATE GENERATOR ENCLOSURE AND BELLY TANK.
- 9 NEW CONDENSING UNITS ON CONCRETE PAD. - REFER TO MECHANICAL & STRUCTURAL DRAWINGS FOR DETAILS.
- 10 EXISTING BOLLARD.
- 11 NEW 6" DIA. BOLLARD, TYP.
- 12 NEW UTILITY TRANSFORMER-REFER TO ELECTRICAL DRAWINGS.
- 13 EXISTING CONDENSER UNIT
- 14 NEW BACK-UP GENERATOR ENCLOSURE WITH BELLY TANK.
- 15 NEW CONCRETE CURB. - REFER TO CIVIL DRAWINGS FOR DETAILS.
- 16 NEW CONCRETE PAD AT DOOR - REFER TO CIVIL DRAWINGS FOR DETAILS.
- 17 DAY ONE HVAC UNIT- REFER TO MECHANICAL DRAWINGS.
- 18 "ADD ALTERNATE" HVAC UNIT- REFER TO MECHANICAL DRAWINGS
- 19 NEW CONCRETE PAD FOR HVAC'S- REFER TO STRUCTURAL DRAWINGS. TOP OF PAD 832'
- 20 NEW TEMP GEN TAP BOXES - REFER TO ELECTRICAL DRAWINGS FOR ADD'L INFORMATION
- 21 EXISTING UTILITY TRANSFORMER
- 22 FUEL FILL PORTS MOUNTED AT NEW GEN PAD AND BELLY TANKS.
- 23 CONCRETE RETAINING WALL, SEE DETAIL 8/SS11
- 24 NEW CMU SCREENWALL
- 25 EXISTING CMU SCREENWALL
- 26 NEW HW DOOR
- 27 SOUND CONTROL BARRIER - SEE DETAIL 8/212 AND SPECIFICATION 323516
- 28 NEW RAMP - SEE DETAILS 4213


LEGEND

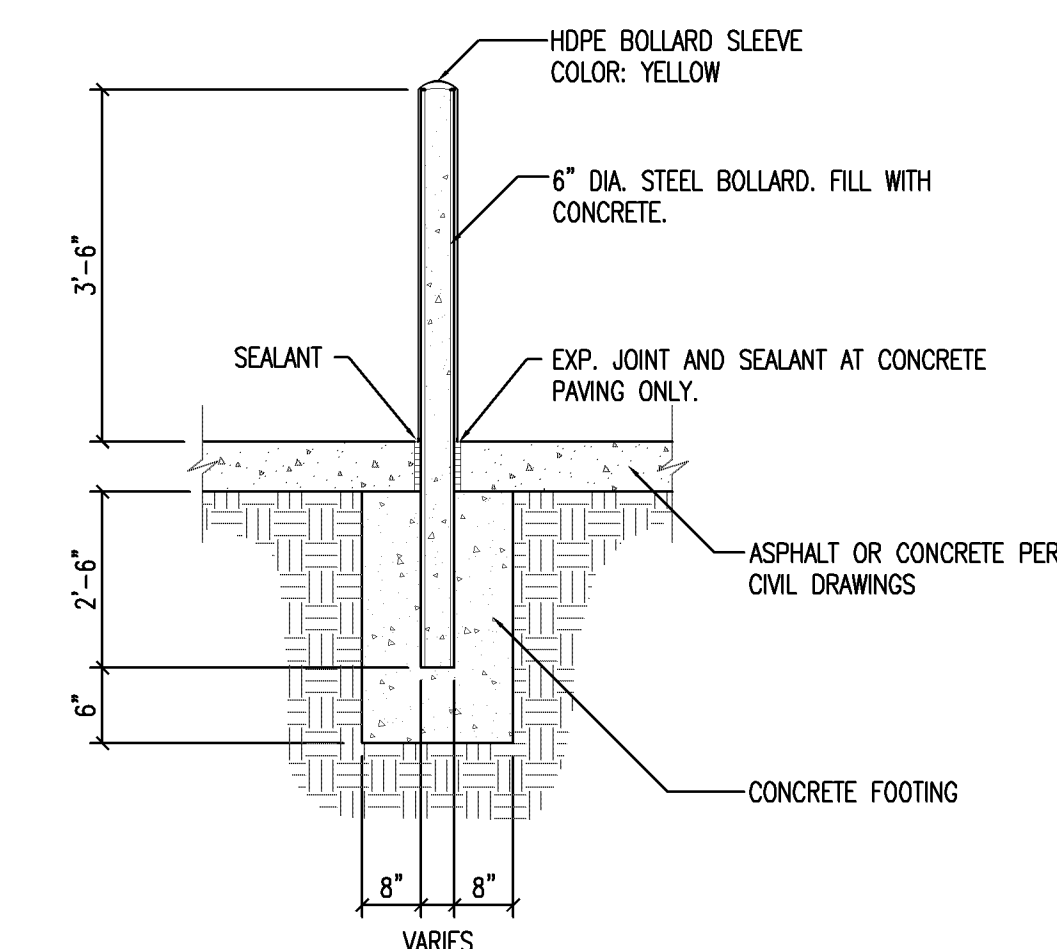

2 BOLLARD DETAIL
A101 SCALE: 1/2" = 1'-0"


I hereby certify that this plan, specifications, or report was prepared by me or under my direct supervision, and that I am a duly licensed Architect under the laws of the state of Minnesota.

Signature: 2021.10.28 17:56:31-04'00'
Typed or Printed Name: Robert Jerry Lara
Date: 10/28/2021 License Number: 59397

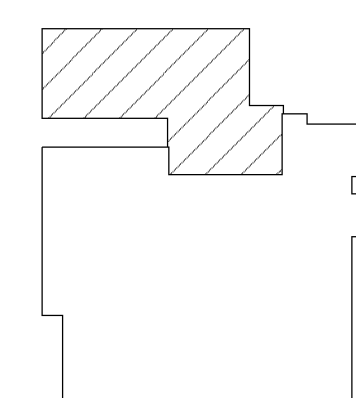

KEY PLAN

1 ARCHITECTURAL ENLARGE SITE PLAN
A101 SCALE: 1/16" = 1'-0"

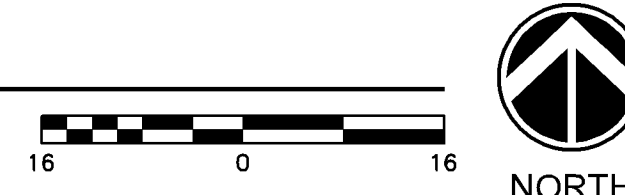

This drawing was prepared solely for the use of Verizon Wireless and must only be used by Verizon Wireless employees, contractors, and vendors while performing the work shown on this drawing. Any other use of this drawing is forbidden.

 MORRISON HERSHFIELD
MISSION CRITICAL

1455 LINCOLN PARKWAY, SUITE 500
ATLANTA, GA 30346
TEL: 770.379.8500 FAX: 770.379.8501
WWW.MORRISONHERSHFIELD.COM

Do not scale drawings. Contractor must verify all dimensions and advise Consultants of any errors or omissions. No variations or modifications to work shown shall be implemented without prior written approval. All previous issues of this drawing are superseded by the latest revision. All drawings and specifications remain the property of Morrison Hershfield Corporation.

SUBCONSULTANT

verizon[✓]
BLOOMINGTON MSC EXPANSION
10801 BUSH LAKE ROAD
BLOOMINGTON, MN.

[illegible]

NETWORK COMPLIANCE SUBMITTALS	DATE
ISSUED FOR PRELIMINARY REVIEW	04/24/2020
ISSUED FOR 30% SUBMISSION	05/28/2020
ISSUED FOR 60% SUBMISSION	07/24/2020
ISSUED FOR 90% SUBMISSION	08/21/2020
ISSUED FOR 100% SUBMISSION	11/11/2020
REISSUED FOR 100% REVIEW	01/08/2021
ISSUED FOR FINAL DESIGN ACCEPTANCE	05/17/2021
ISSUED FOR BIDDING	05/17/2021
ISSUED FOR PERMIT	07/09/2021
ISSUED FOR PERMIT REVISIONS	08/04/2021
ISSUED FOR PERMIT REVISIONS	10/28/2021

PROJECT NO:	200174900	STAMP
CAD DWG FILE:	A101	
DESIGNED BY:	JP	
DRAWN BY:	KNC	
CHECKED BY:	KM	
COPYRIGHT:	MAY 2020	

SHEET TITLE

ARCHITECTURAL ENLARGED
SITE PLAN

SHEET NUMBER

A101