


PL202200067

0.25 fc

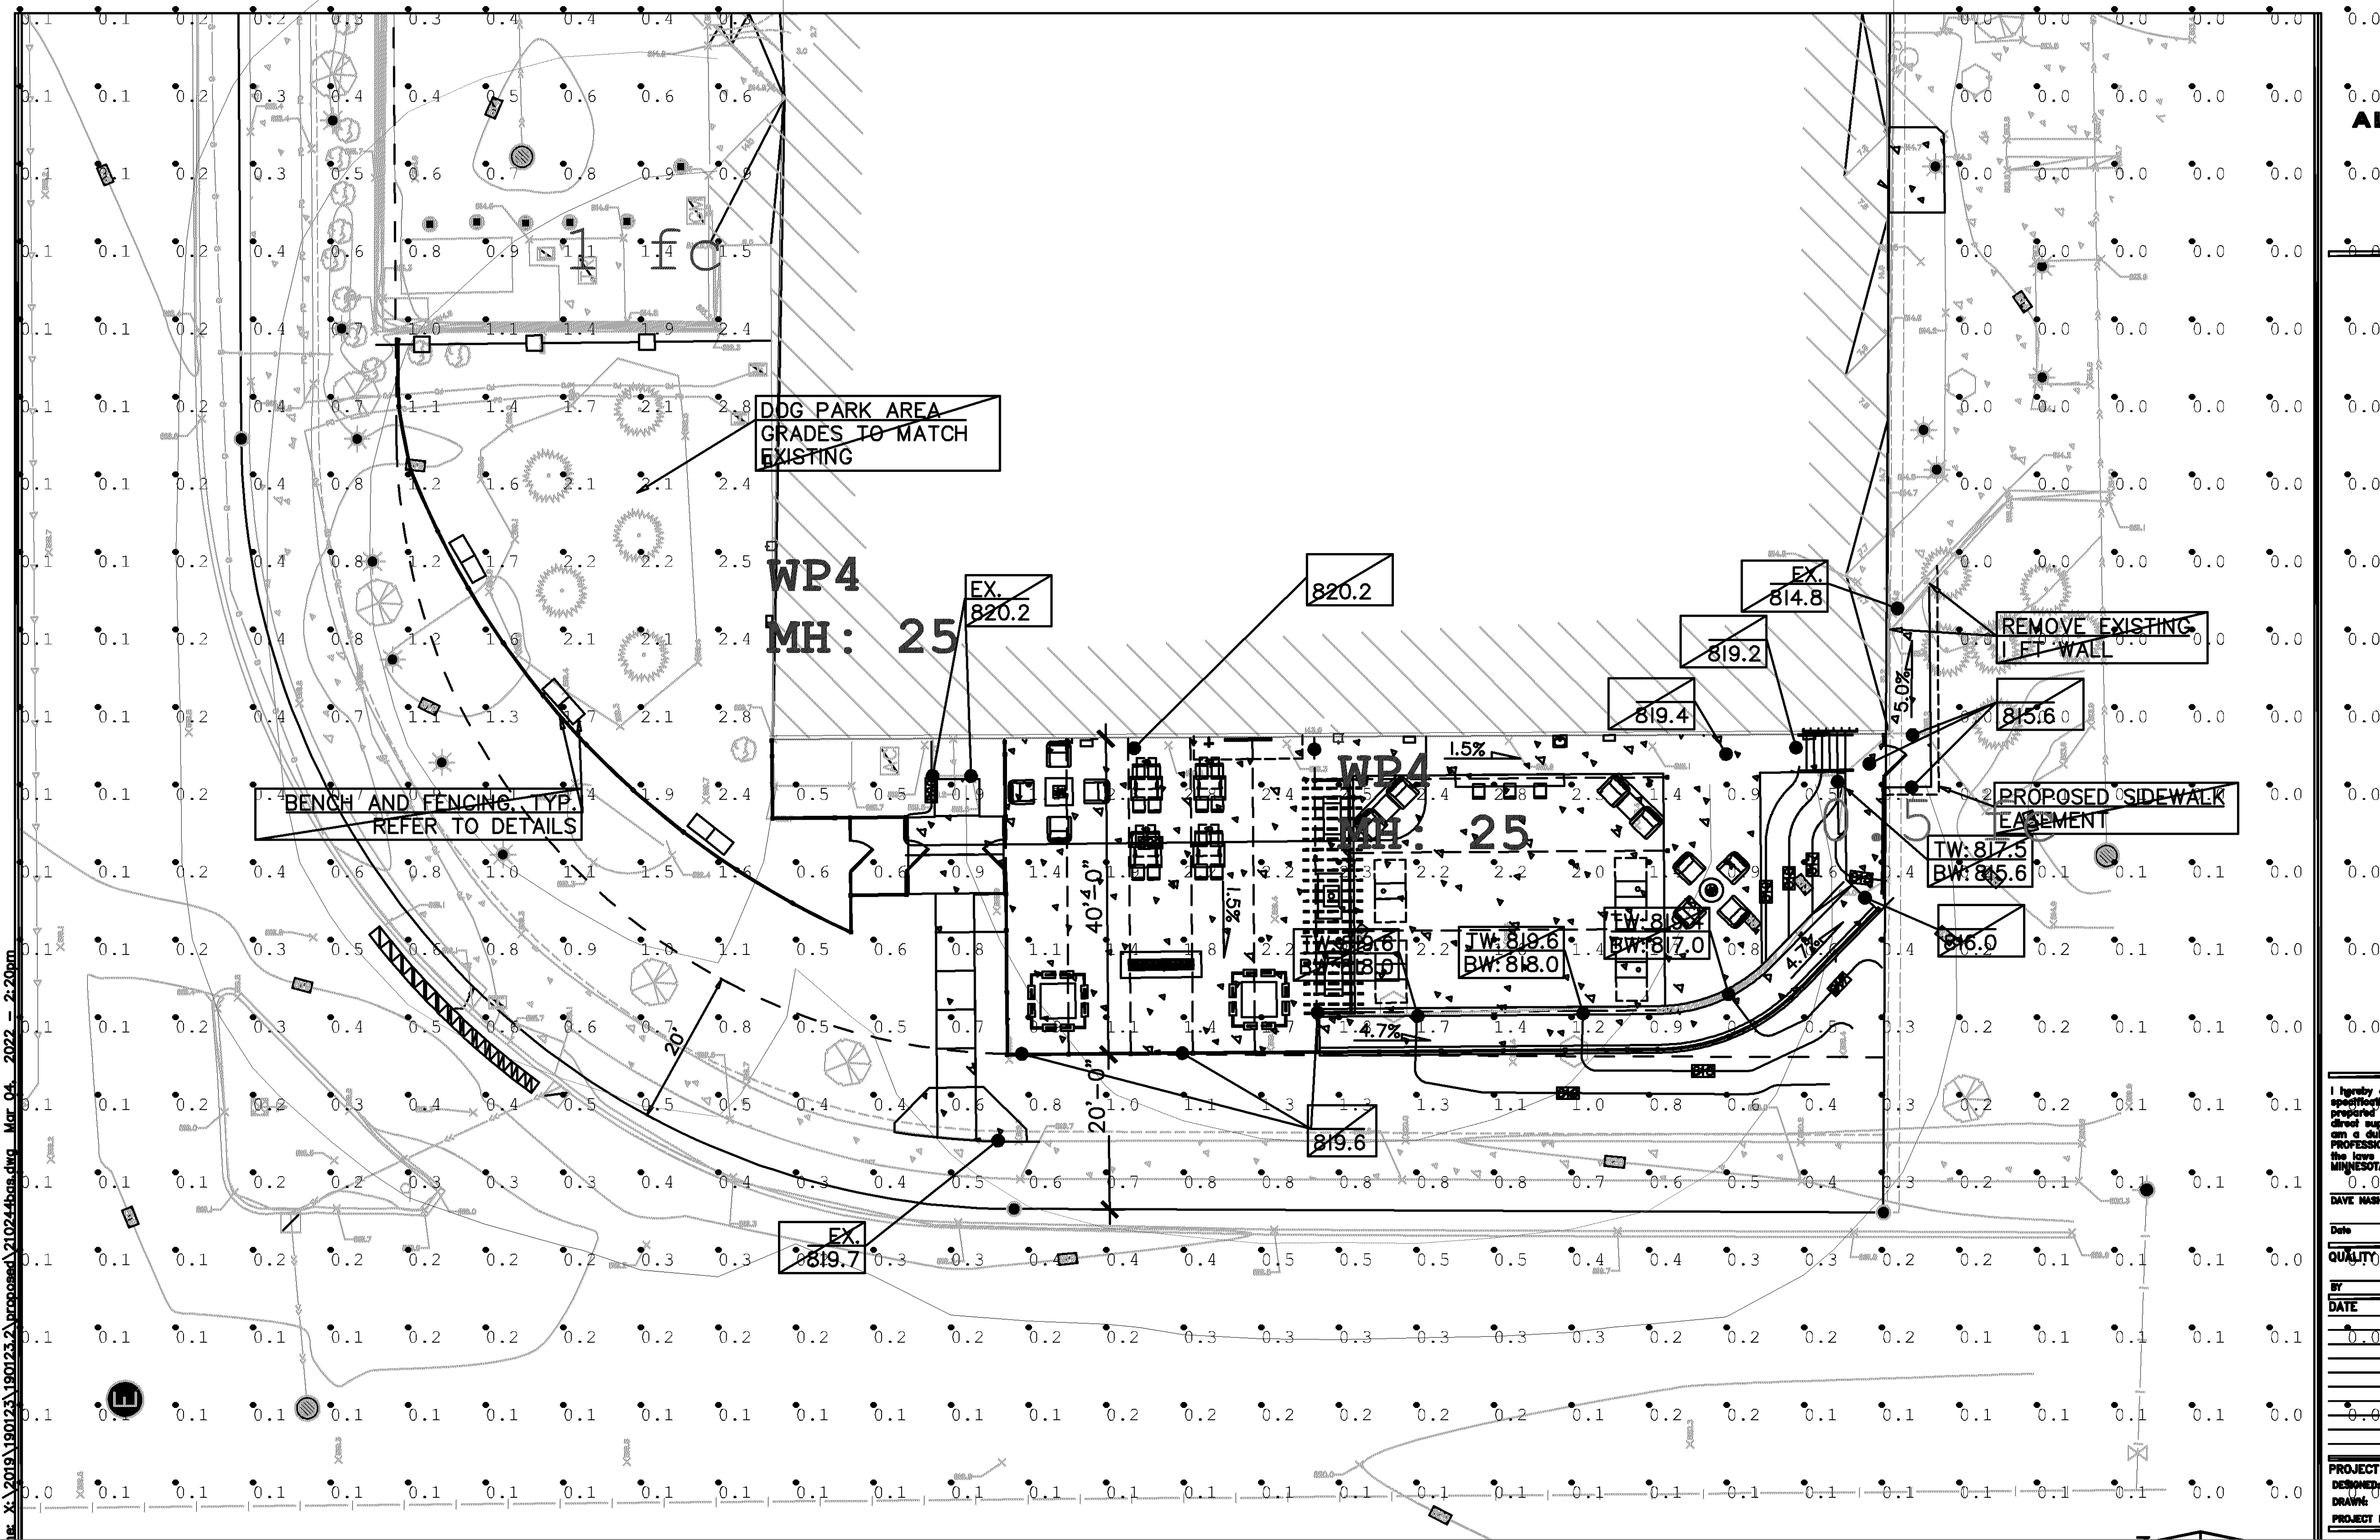

I hereby certify that the specifications prepared by me are a true and correct copy of the original as shown on the plans of this project.
 PROJECT NO. _____
 DRAWN BY _____
 DATE _____
 DESIGNED BY _____
 PROJECT NO. _____
 DATE _____
 DRAWN BY _____
 PROJECT NO. _____

Calculation Summary

Label	CalcType	Units	Avg	Max	Min	Avg/Min	Max/Min
Ground_Planar	Illuminanc	Fc	0.24	2.8	0.0	N.A.	N.A.
Luminaire Schedule							
Symbol	Qty	Label	Arrangement	LLF	Description	Lum. Watts	
□	2	WP4	SINGLE	0.810	PRV-C60-D-UNV-T4-BZ	153	

Drawn By: Daniel Budke
 Checked By:
 Date: 3/18/2022

#	Date	Comments

Revisions

Aire Hotel and Apartments

Scale:

