


Schedule									
Symbol	Label	Quantity	Manufacturer	Catalog Number	Description	Lamp	Lumens Per Lamp	Light Loss Factor	Wattage
□ • □	AA	2	EATON - MCGRAW-EDISON (FORMER COOPER LIGHTING)	GLEON-AF-04-LED-E1-SL3	GALLEON AREA AND ROADWAY LUMINAIRE (4) 70 CRI, 4000K, 1050mA LIGHTSQUARES WITH 16 LEDS EACH AND TYPE III SPILL LIGHT ELIMINATOR OPTICS		375	0.81	450
□	BB	2	EATON - MCGRAW-EDISON (FORMER COOPER LIGHTING)	GWC-AF-02-LED-E1-T4FT-1200	GALLEON WALL LUMINAIRE (2) 70 CRI, 4000K, 1200mA LIGHTSQUARES WITH 16 LEDS EACH AND TYPE IV FORWARD THROW OPTICS		428	0.81	129

Statistics						
Description	Symbol	Avg	Max	Min	Max/Min	Avg/Min
Parking	+	1.6 fc	3.2 fc	0.8 fc	4.0:1	2.0:1
Parking	+	1.6 fc	3.2 fc	0.8 fc	4.0:1	2.0:1

Lighting Plan Approved
Zoning Review Only
By Liz O'Day on Sept. 20, 2018

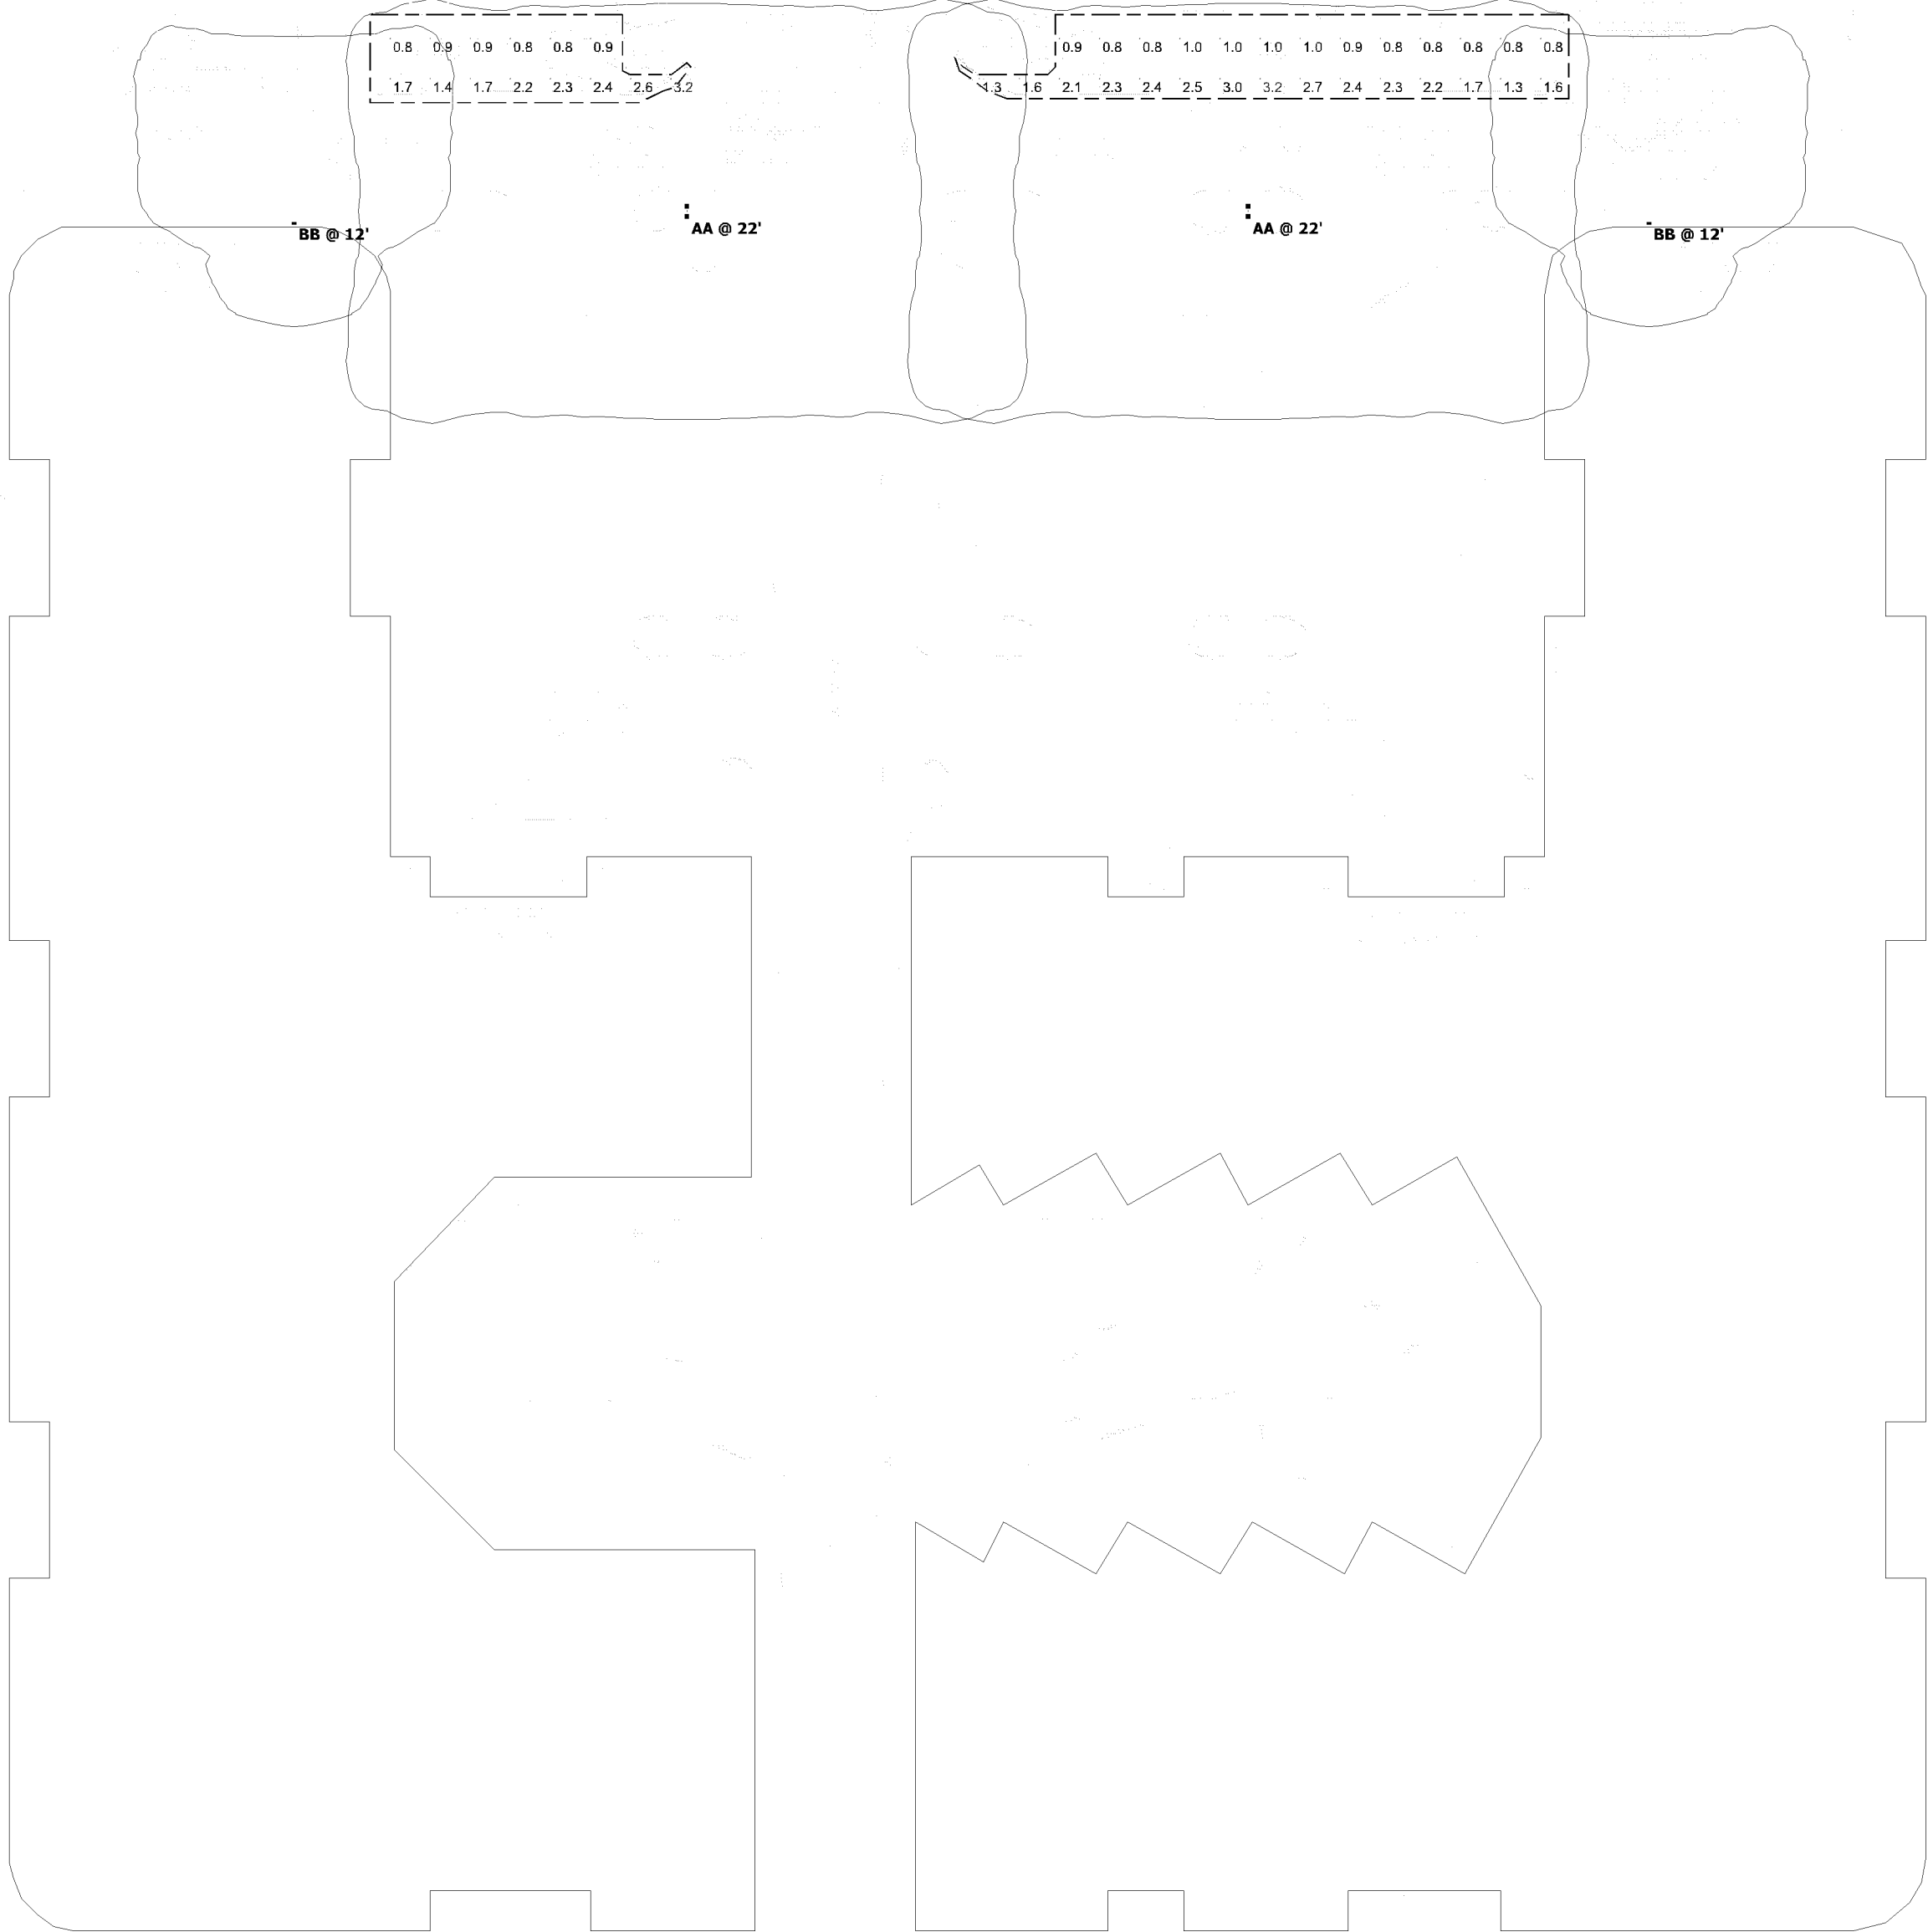

Plan View
Scale - 1" = 40ft

Cedar Business Center
1701 & 1801 American Blvd. E.
Bloomington, MN

Amber Forester

Designer	Amber Forester
Date	9/18/2018
Scale	Not to Scale
Drawing No.	L0
Summary	Maintained Lighting Calculations