



CASE FILE #PL201800344

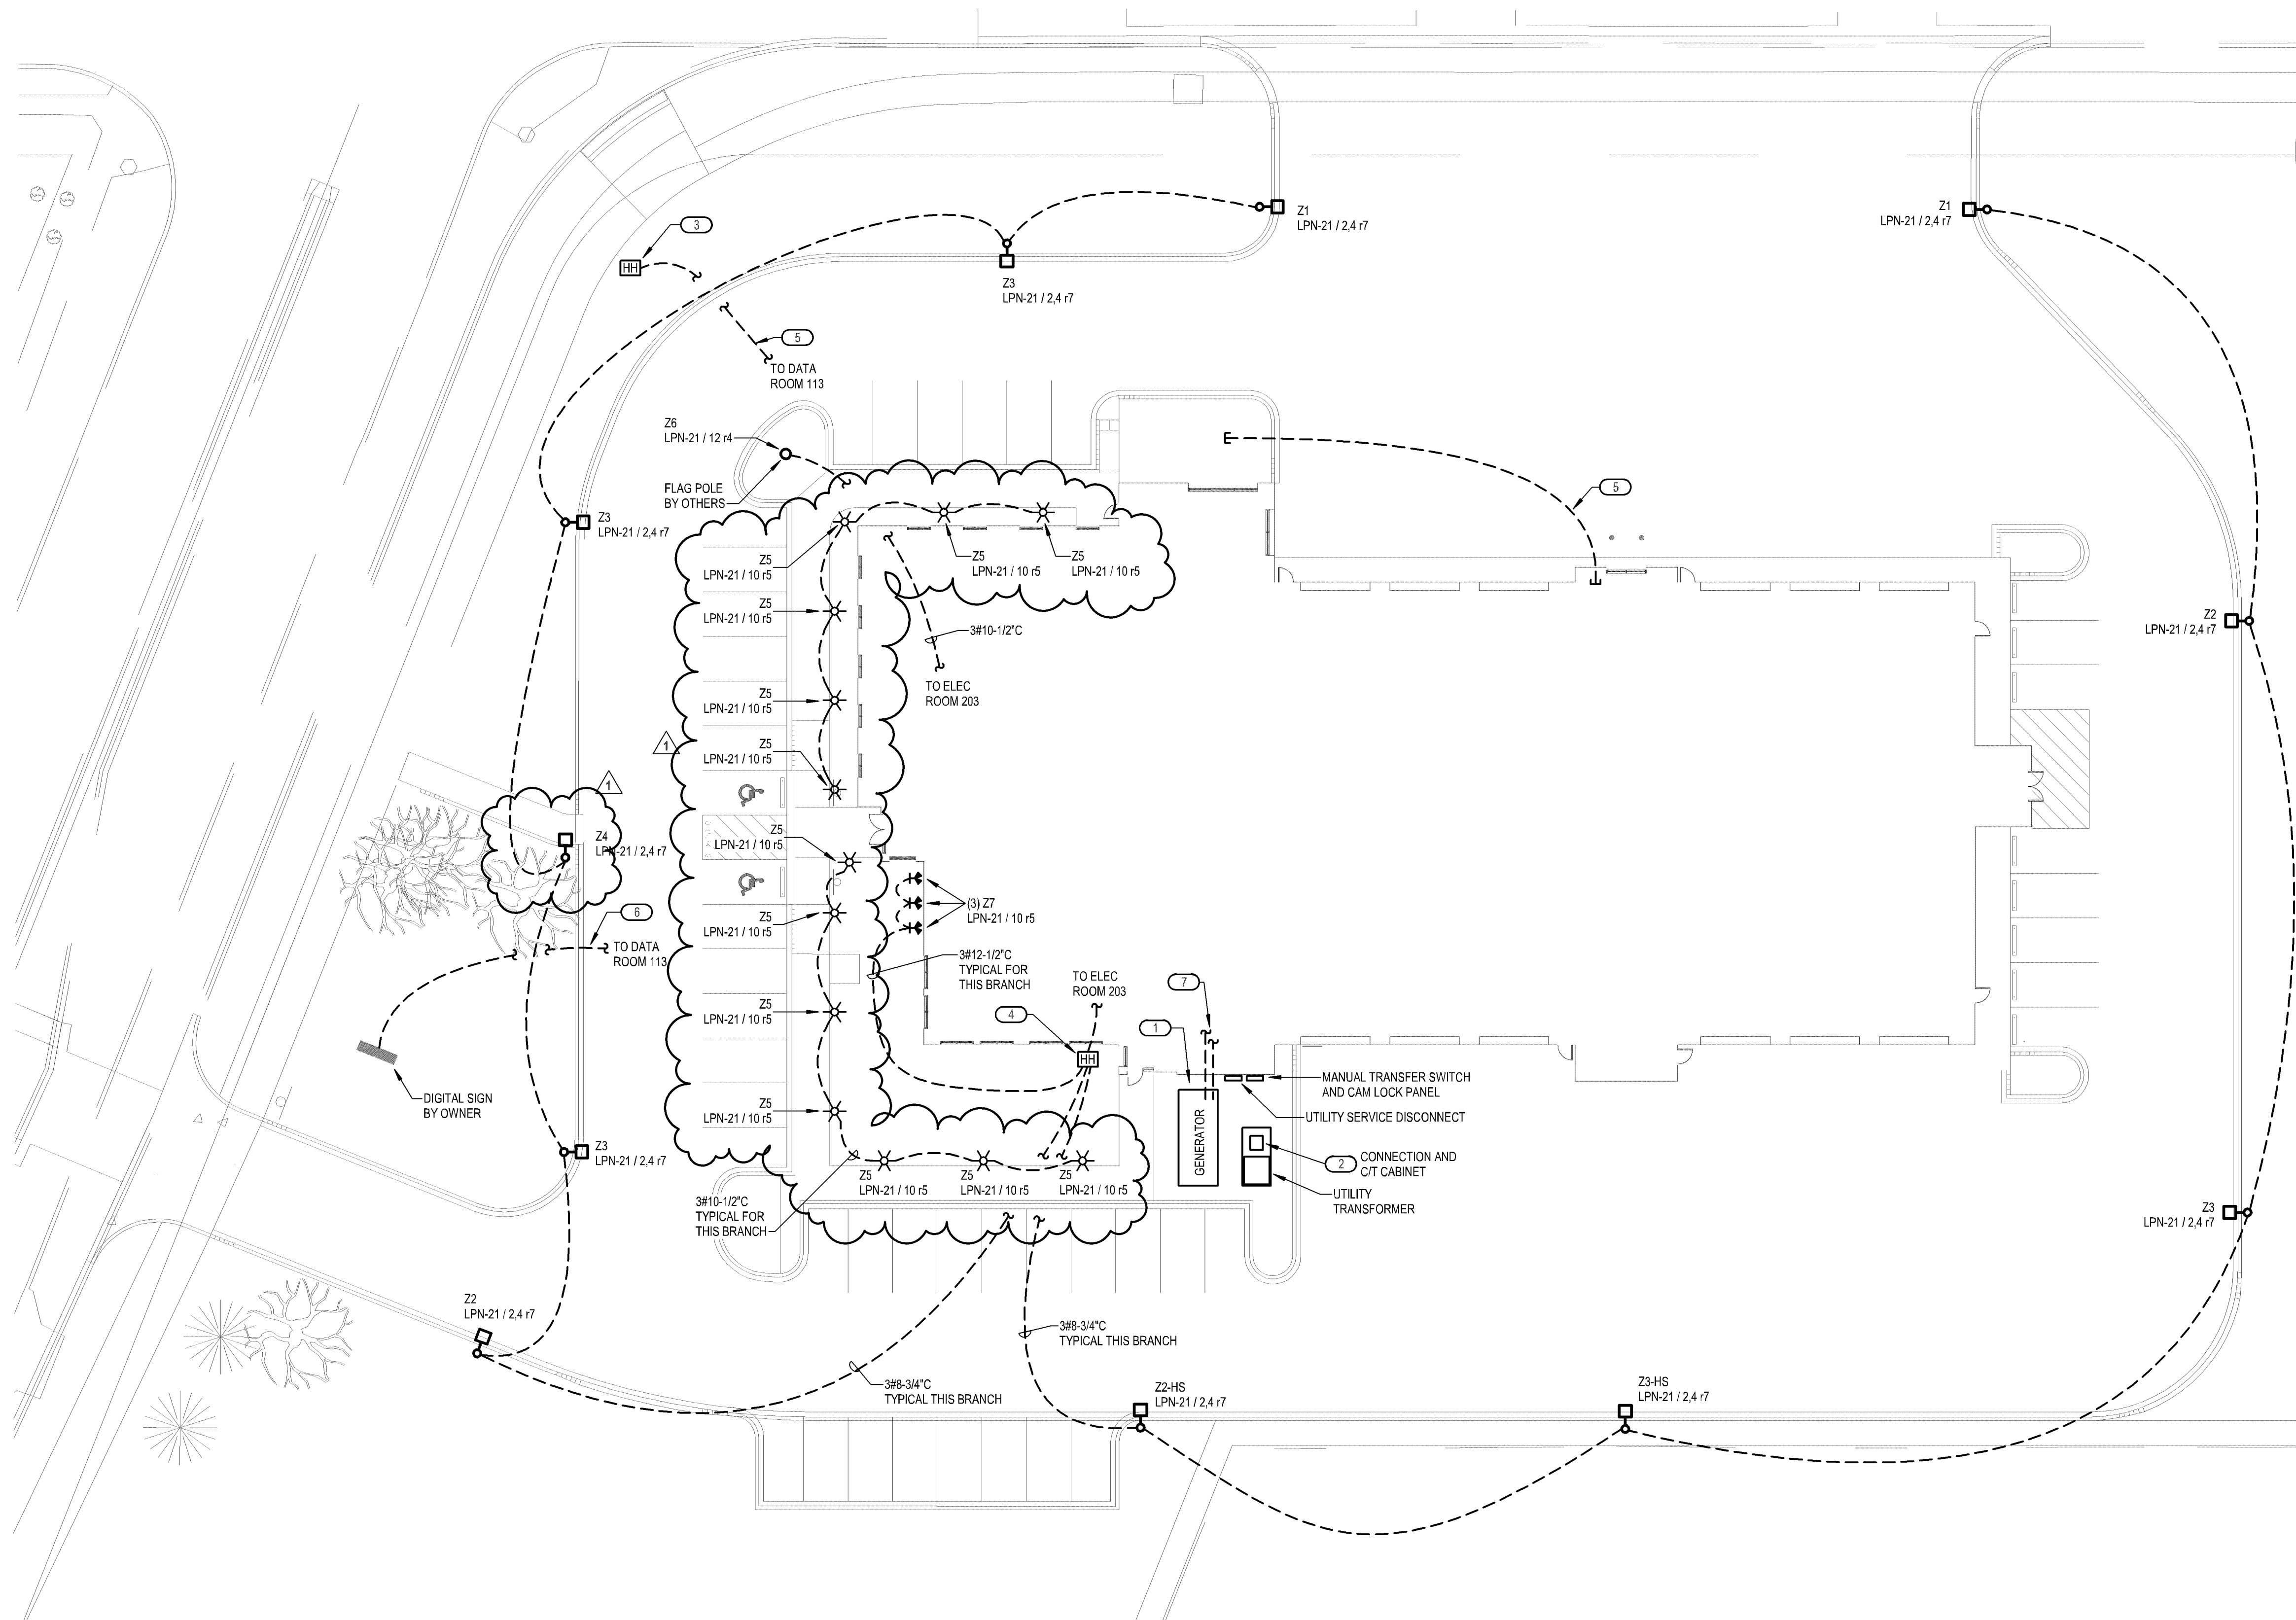

1 ELECTRICAL SITE PLAN

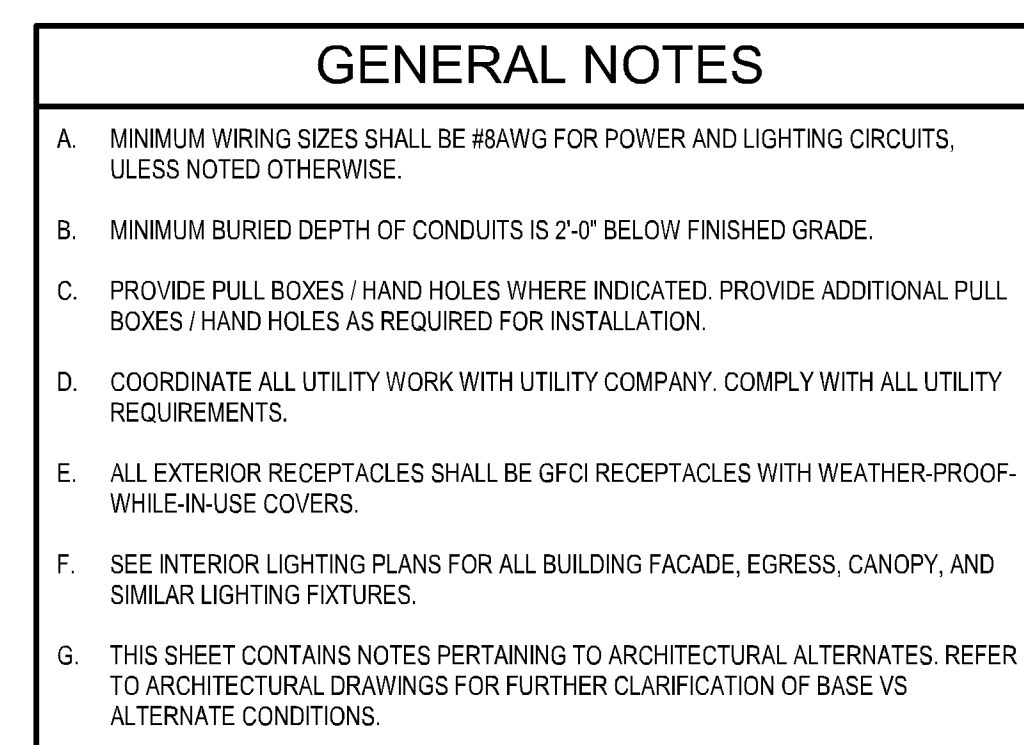

CASE FILE #PL201800344



THE CITY OF
BLOOMINGTON,
MINNESOTA
2301 EAST 86TH STREET
BLOOMINGTON, MN 55425

BLOOMINGTON FIRE
STATION NO. 3

BID SET

wendel
401 2nd Avenue North, Suite 206
Minneapolis, MN 55401
www.wendelcompanies.com
612.401.1401

Wendel W.D. Architects, Engineering, Surveying and
Landscape Architecture, P.C.

Five Bugles Design


MEP
ASSOCIATES, LLC

engineers | consultants | commissioning
800 Blue Garden Rd. Suite #175 | Eden, MN 55121
P: 612.379.9122 | F: 612.379.9125 | mepassociates.com


I hereby certify that this plan, specification, or report was
prepared by me or under my direct supervision and that I am a
duly Licensed Engineer under the laws of the State of Minnesota.

Engineer: Darren Dickenson

Date: 02/28/2019 Reg. No.: 41678

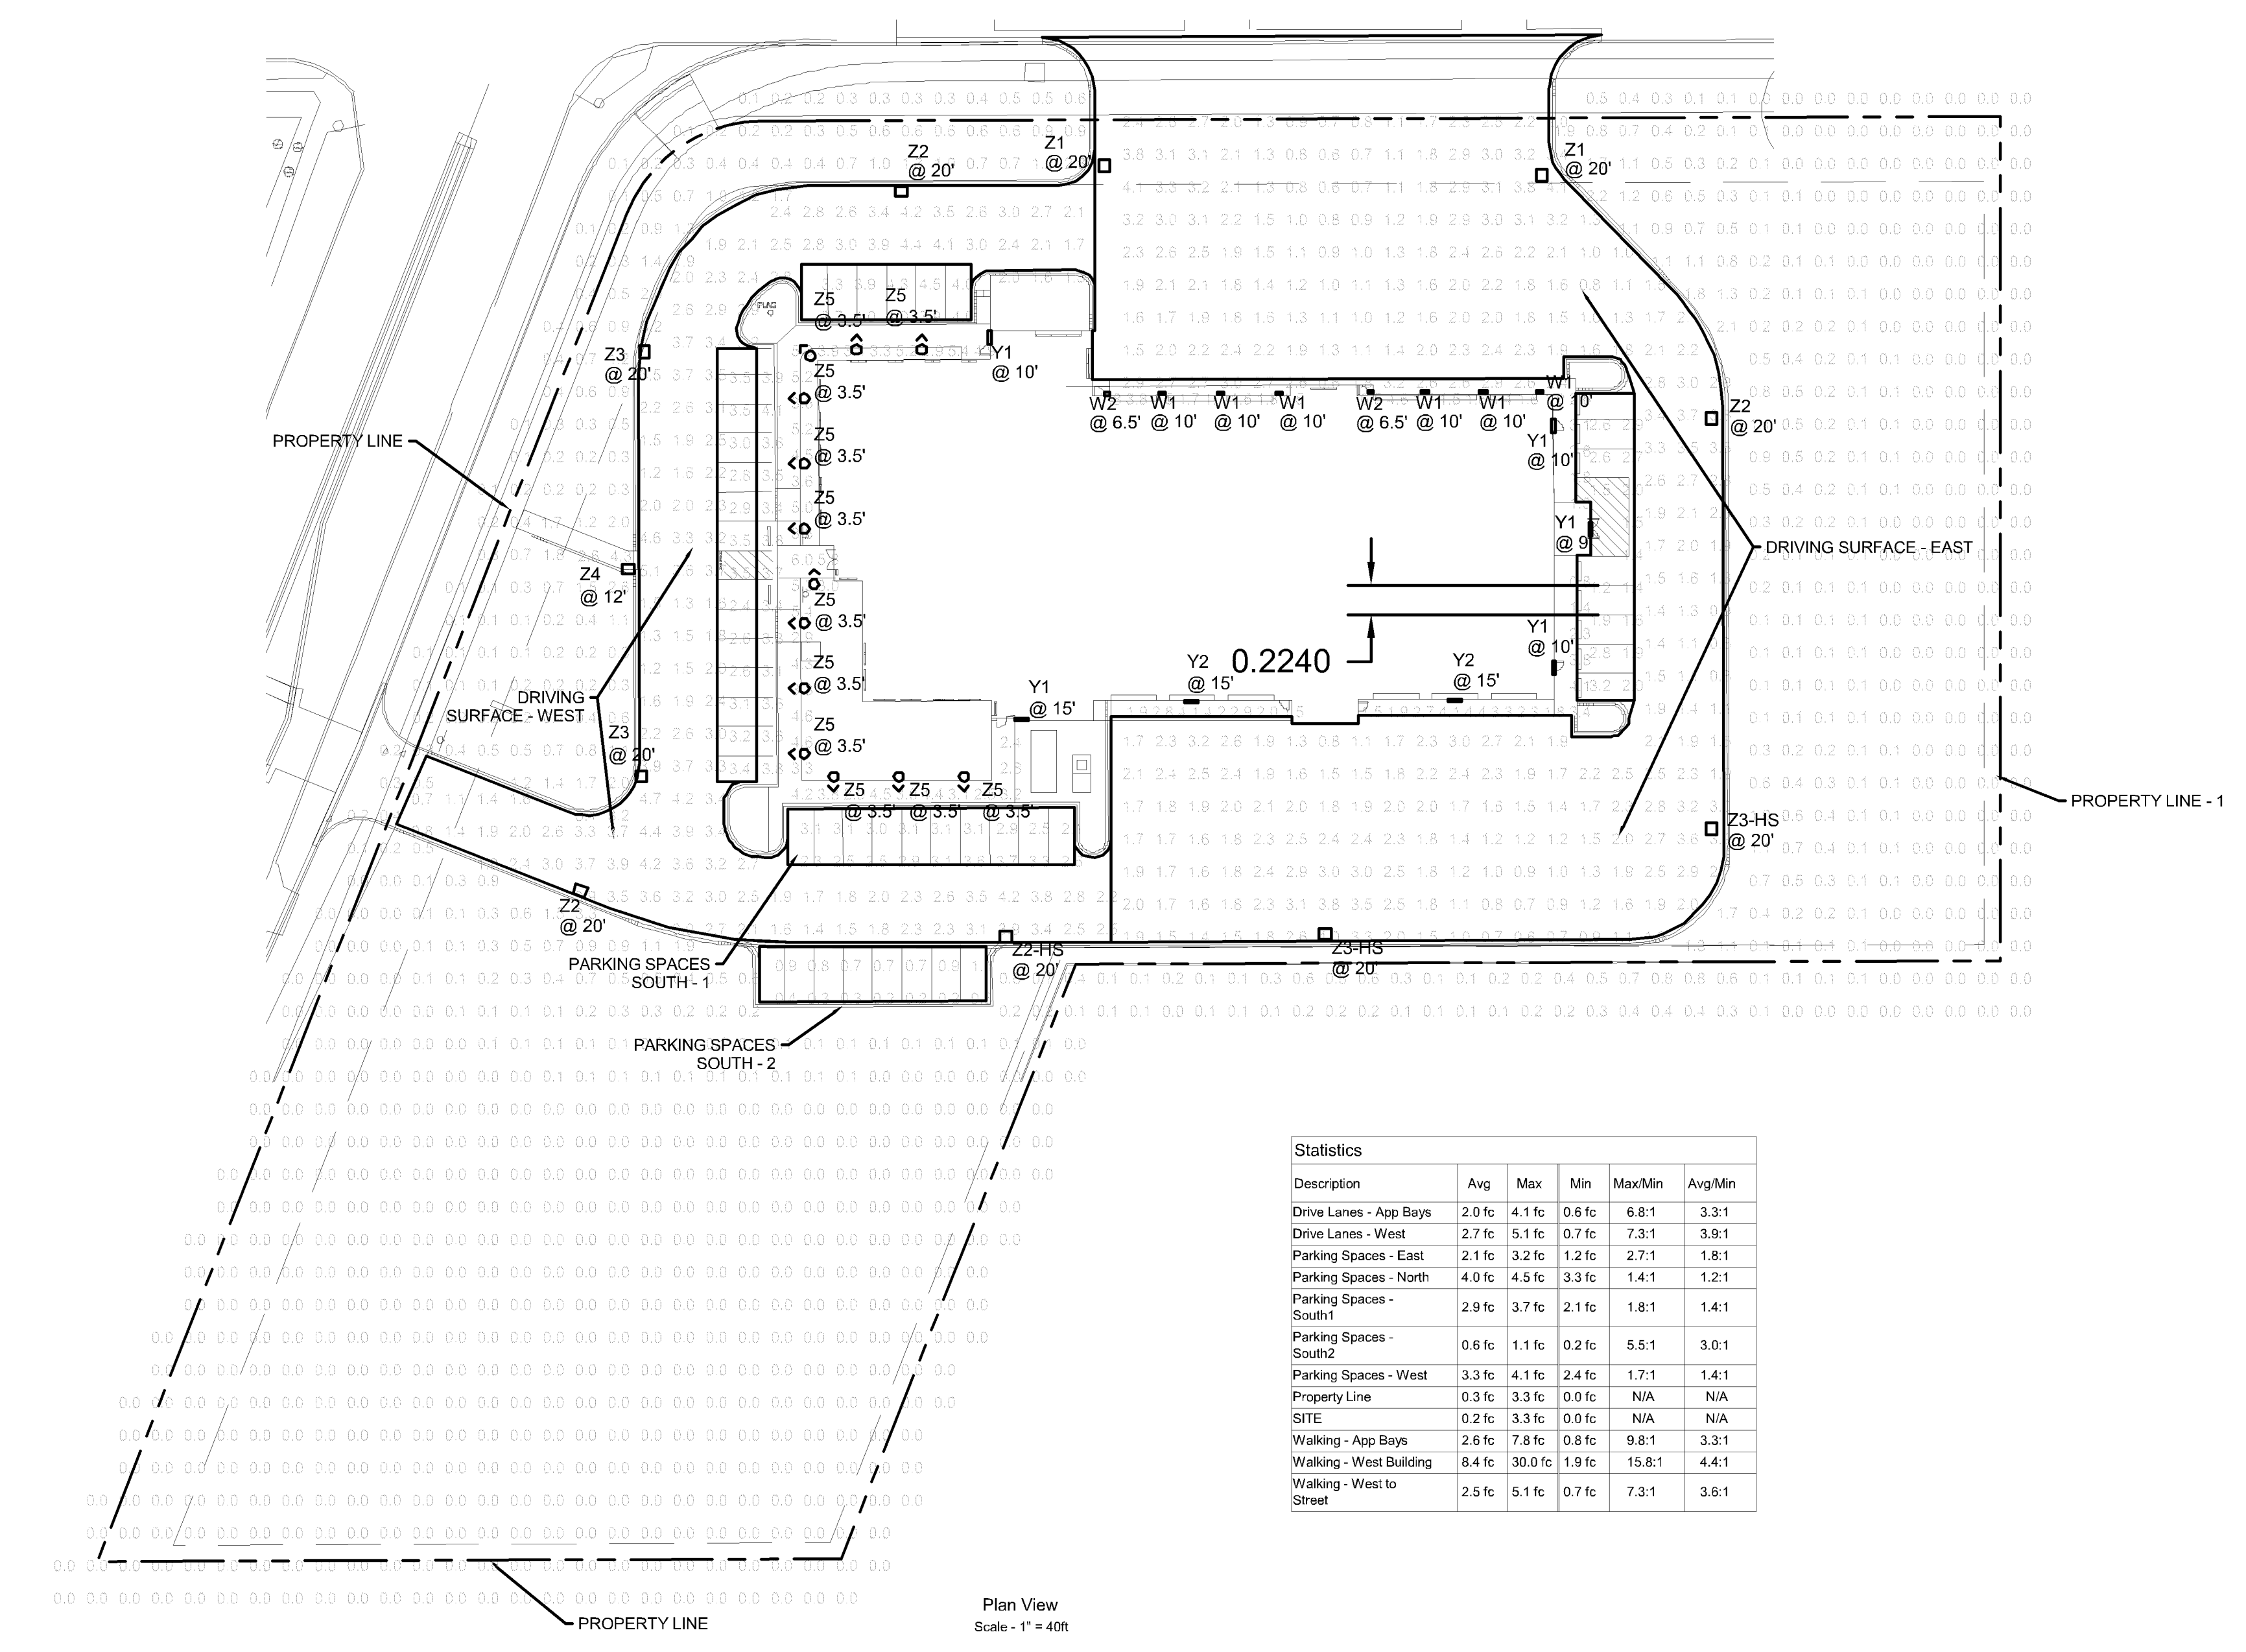

1 SITE PHOTOMETRICS - INITIAL (LLF = 1.0)
1" = 40'-0"

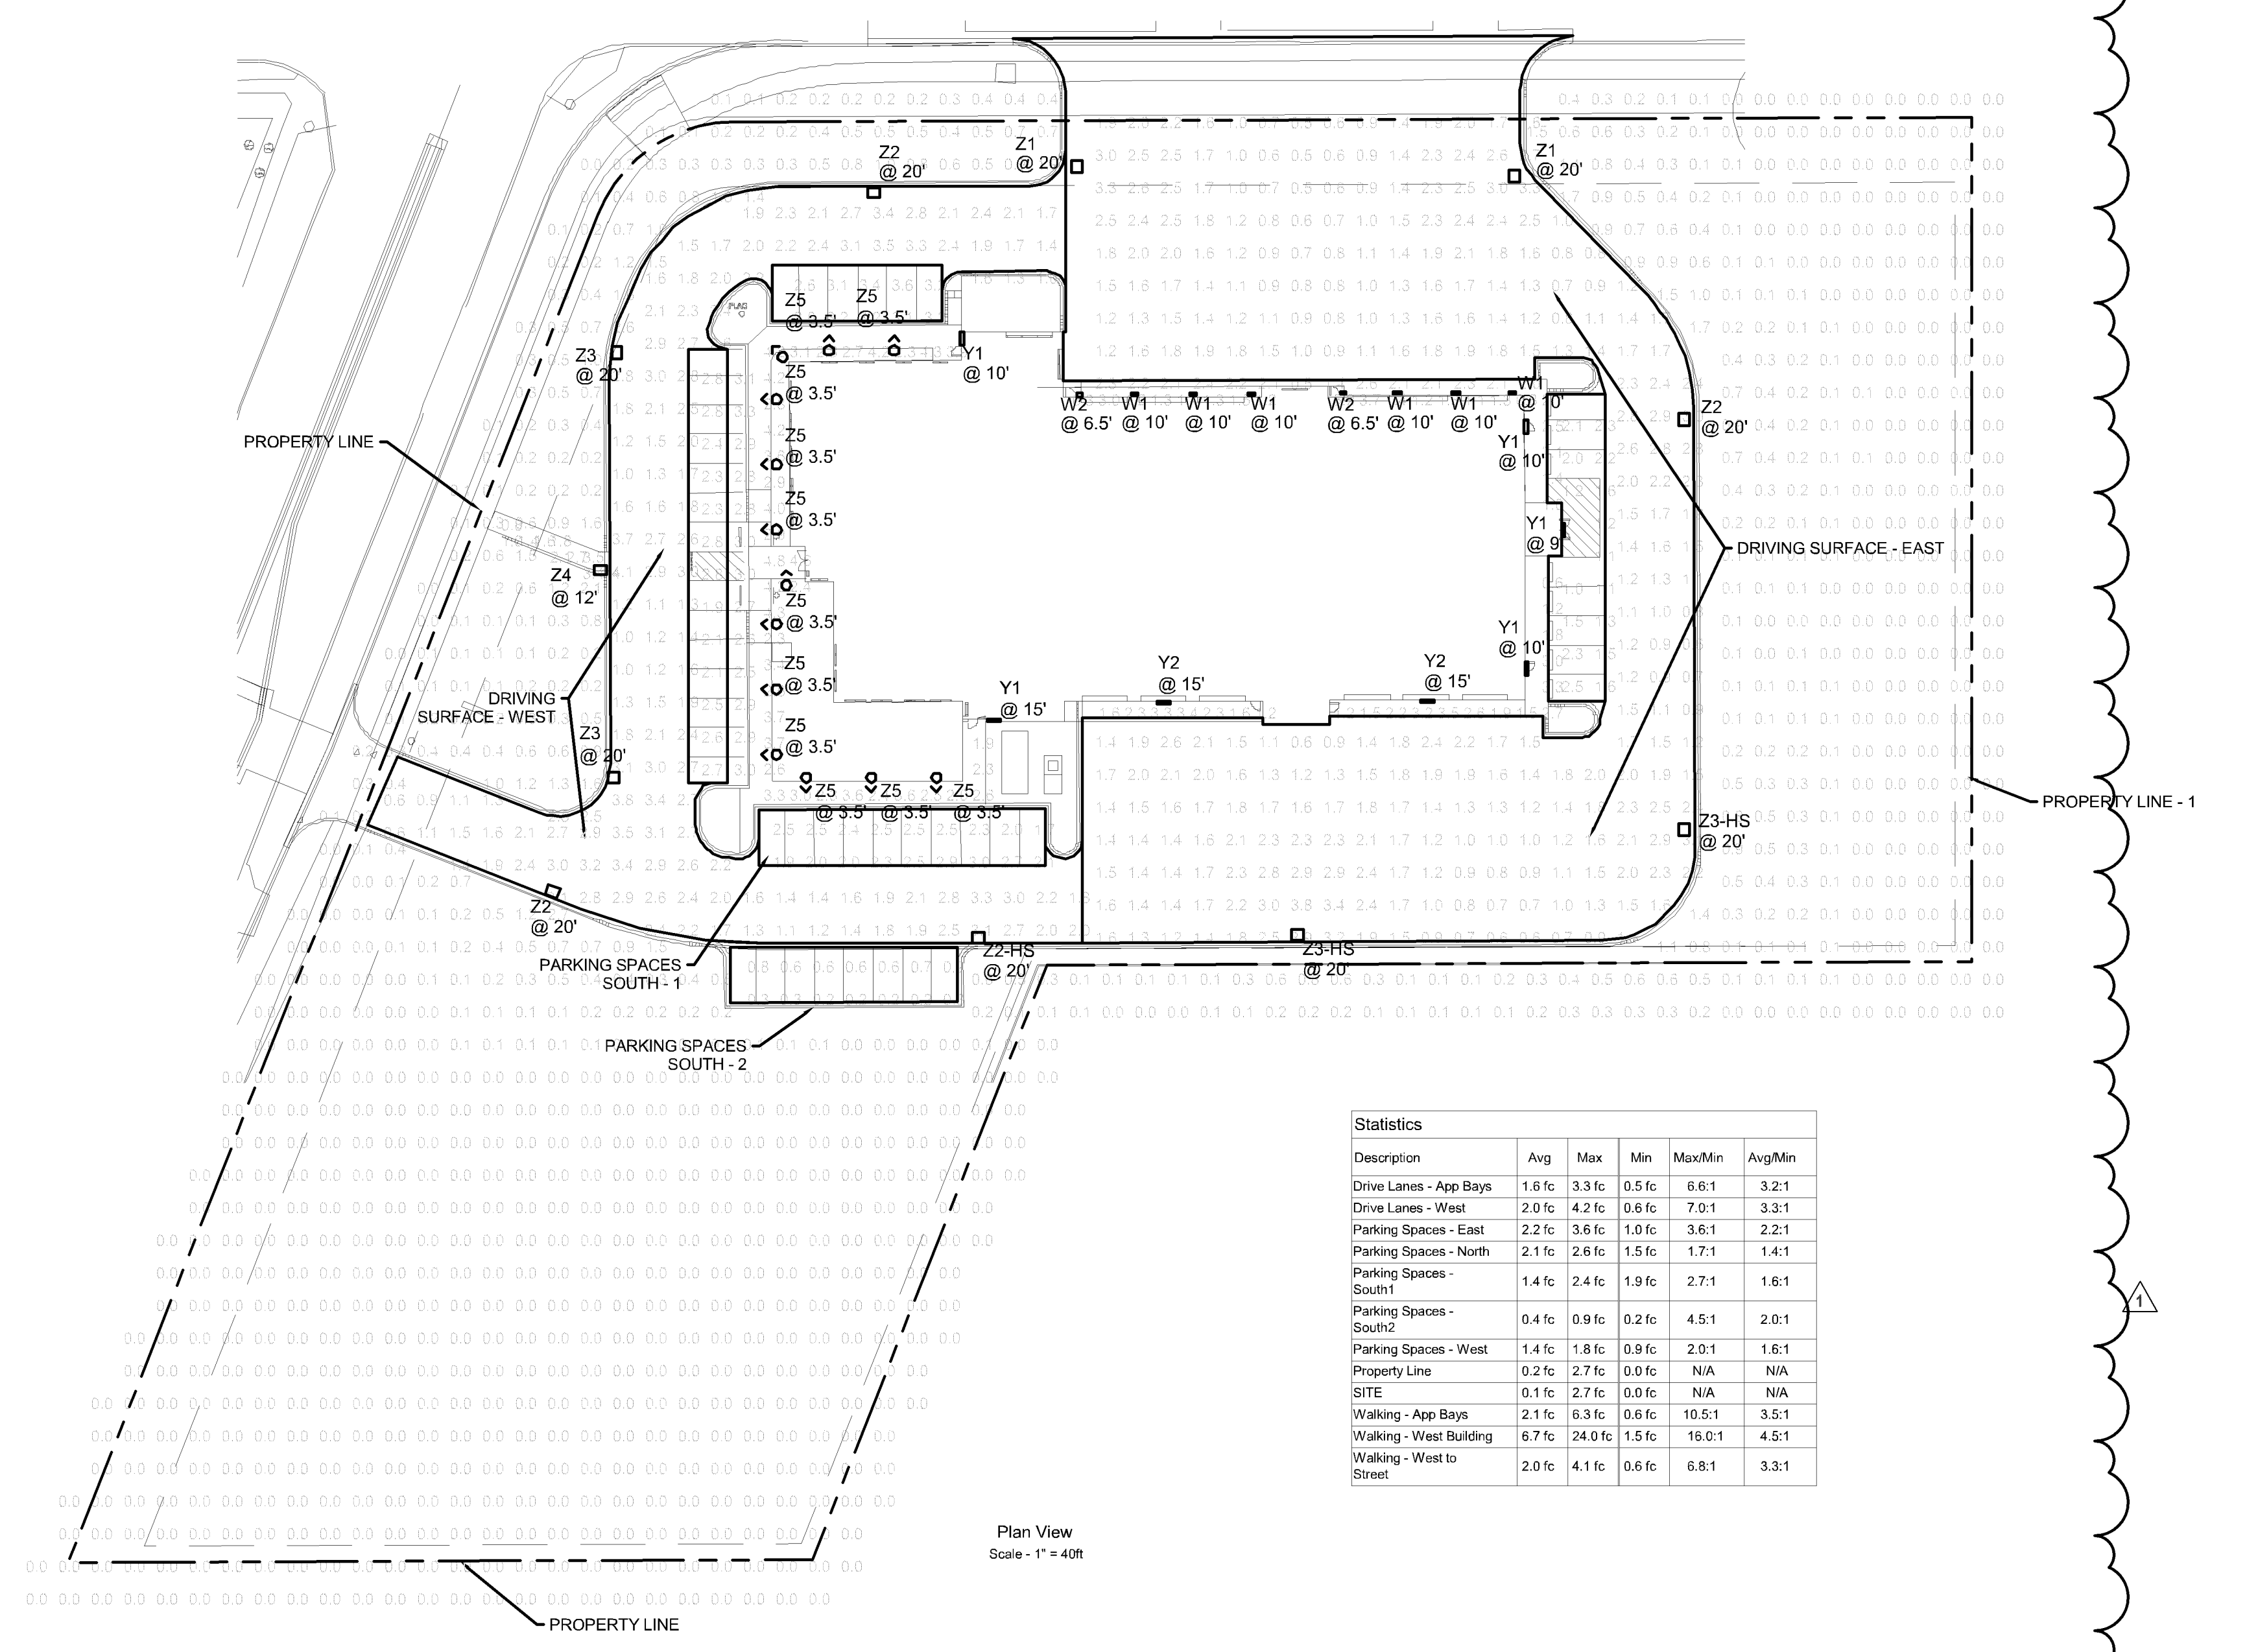

2 SITE PHOTOMETRICS - MAINTAINED (LLF = 0.8)
1" = 40'-0"

LIGHTING PLAN APPROVED



NMJ

NMJ
05/24/2019

NOTE:
THIS DOCUMENT AND THE IDEAS AND DESIGN INCORPORATED HEREIN, AS AN
INSTRUMENT OF PROFESSIONAL SERVICE, ARE THE PROPERTY OF THE ARCHITECT
AND ENGINEER AND ARE NOT TO BE REPRODUCED OR COPIED IN WHOLE OR IN PART
FOR ANY OTHER PROJECT WITHOUT THE WRITTEN PERMISSION OF THE ARCHITECT AND
ENGINEER. UNAUTHORIZED ALTERATION OR ADDITION TO ANY SURVEY
DRAWING, DESIGN, SPECIFICATION, PLAN OR REPORT IS PROHIBITED IN
ACCORDANCE WITH STATE LAW, CODE AND RULES.

NO.	REVISIONS	DATE
1	PR-002	09/10/2019

DWG. TITLE
**ELECTRICAL SITE
PHOTOMETRY**

GENERIC SCALE BAR
SCALE BAR SHOWN IS TWO INCHES ON THE ORIGINAL DRAWING.
PRINT THIS BAR ON THIS SHEET, ADJUST ACCORDINGLY.

DATE: 02-28-2019
SCALE: 1" = 40'-0"
DWG: CAJ CHK: DRD
PROJ. No.: 484401 CLIENT: No.: 2017-56
DWG. No.:

E101

