


PL201900150


PL2019-150

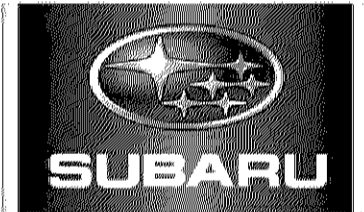


P48
6' 2" H X 7' 7"
X 16' 4" OAH




P30
4' 4" H X 7' 7"
X 15' 3" OAH

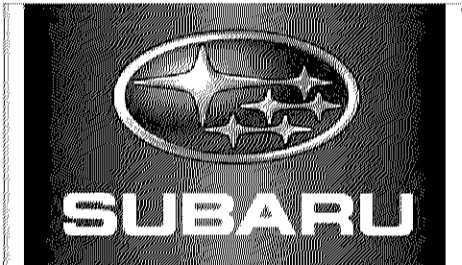


P50
5' 7" H X 9' 9"
X 20' 3" OAH

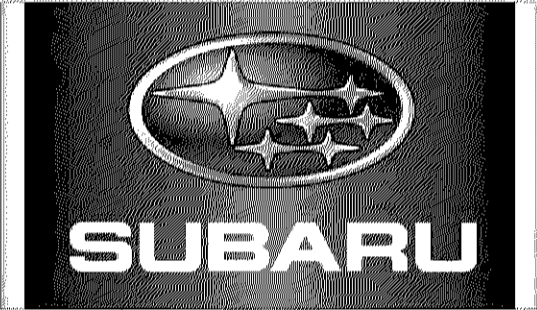

P65
6' 4" H X 11' 2"
X 21' 0" OAH

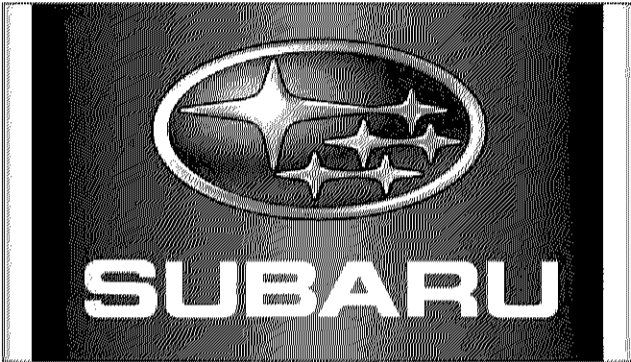


P90
7' 6" H X 13' 1"
X 25' 9" OAH

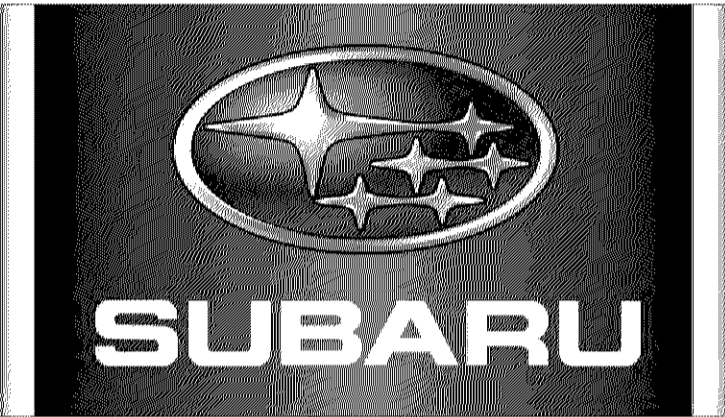


P120
8' 8" H X 15' 2"
X 26' 11" OAH

PL201900150


PL2019-150

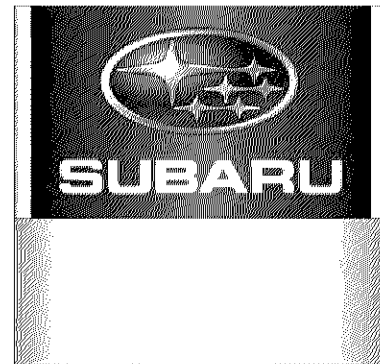

M30
4' 4" H X 7' 10"
X 6' 10" OAH

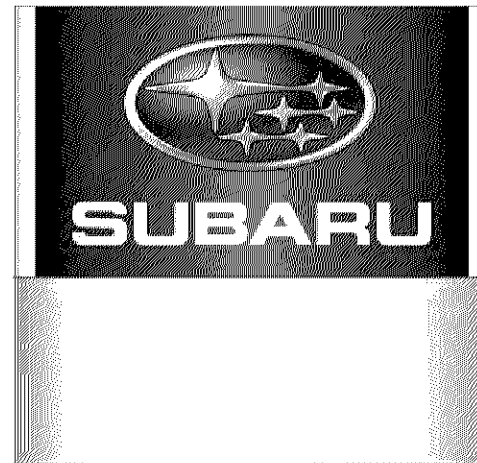

M50
5' 7-1/2" H X 9' 11"
X 8' 1-1/2" OAH

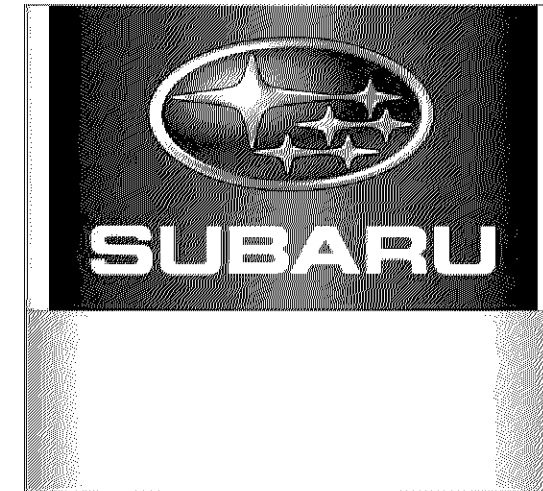


M65
6' 4" H X 11' 1"
X 8' 10" OAH

PL201900150

PL2019-150

30" DIRECTIONAL


DIRECTIONAL SIGN 19"H X 30"W
SINGLE OR DOUBLE SIDED W/ TWIN POLES AND
WHITE REFLECTIVE GRAPHICS.
OPTION FOR INTERNALLY ILLUMINATED WITH LIT
WHITE ACRYLIC GRAPHICS.
SAMPLE COPY SHOWN; TO VARY PER
DAELER'S NEEDS

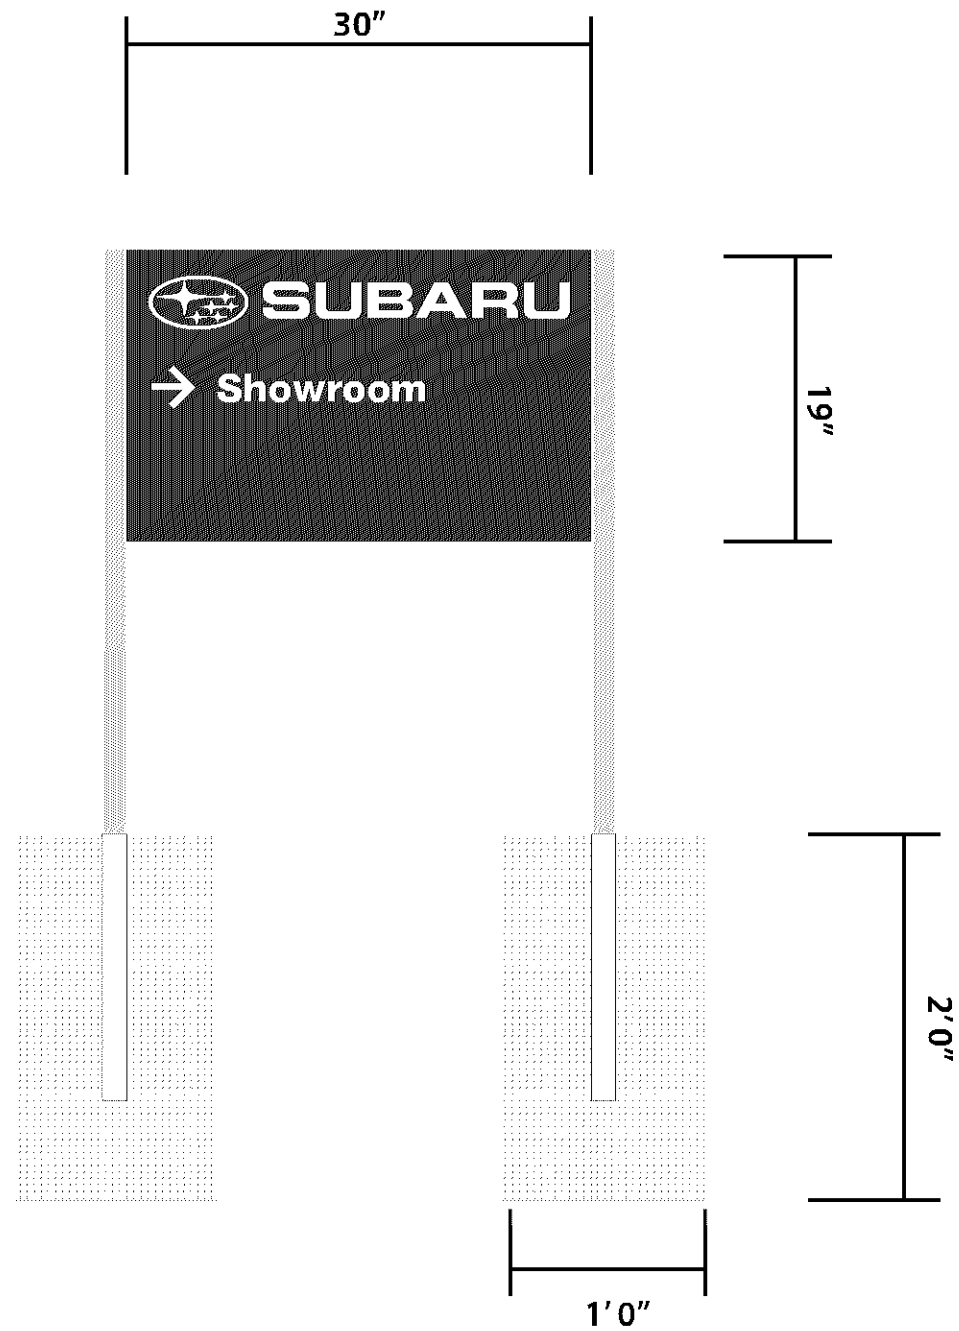

Side A



Side B


 PHILADELPHIASIGN BRINGING THE WORLD'S BRANDS TO LIFE	TITLE	Subaru	DWG BY	AFR	DATE	12.17.14	DATE	REVISION	BY <small>THIS IS AN ORIGINAL UNPUBLISHED DRAWING CREATED BY P.S.C.O. IT IS SUBMITTED FOR YOUR PERSONAL USE IN CONNECTION WITH A PROJECT BEING PLANNED FOR YOU BY P.S.C.O. IT IS NOT TO BE SHOWN TO ANYONE OUTSIDE YOUR ORGANIZATION NOR IS IT TO BE USED, COPIED, REPRODUCED, OR EXHIBITED IN ANY FASHION.</small>
	ADDRESS	SUB_Regulatories Samples		DWG NUM	B58649				
				SHEET	1				

PL201900150

PL2019-150

36" DIRECTIONAL

DIRECTIONAL SIGN 24"H X 36"W
SINGLE OR DOUBLE SIDED W/ TWIN POLES AND
WHITE REFLECTIVE GRAPHICS.
OPTION FOR INTERNALLY ILLUMINATED WITH LIT
WHITE ACRYLIC GRAPHICS.
SAMPLE COPY SHOWN; TO VARY PER
DAELER'S NEEDS

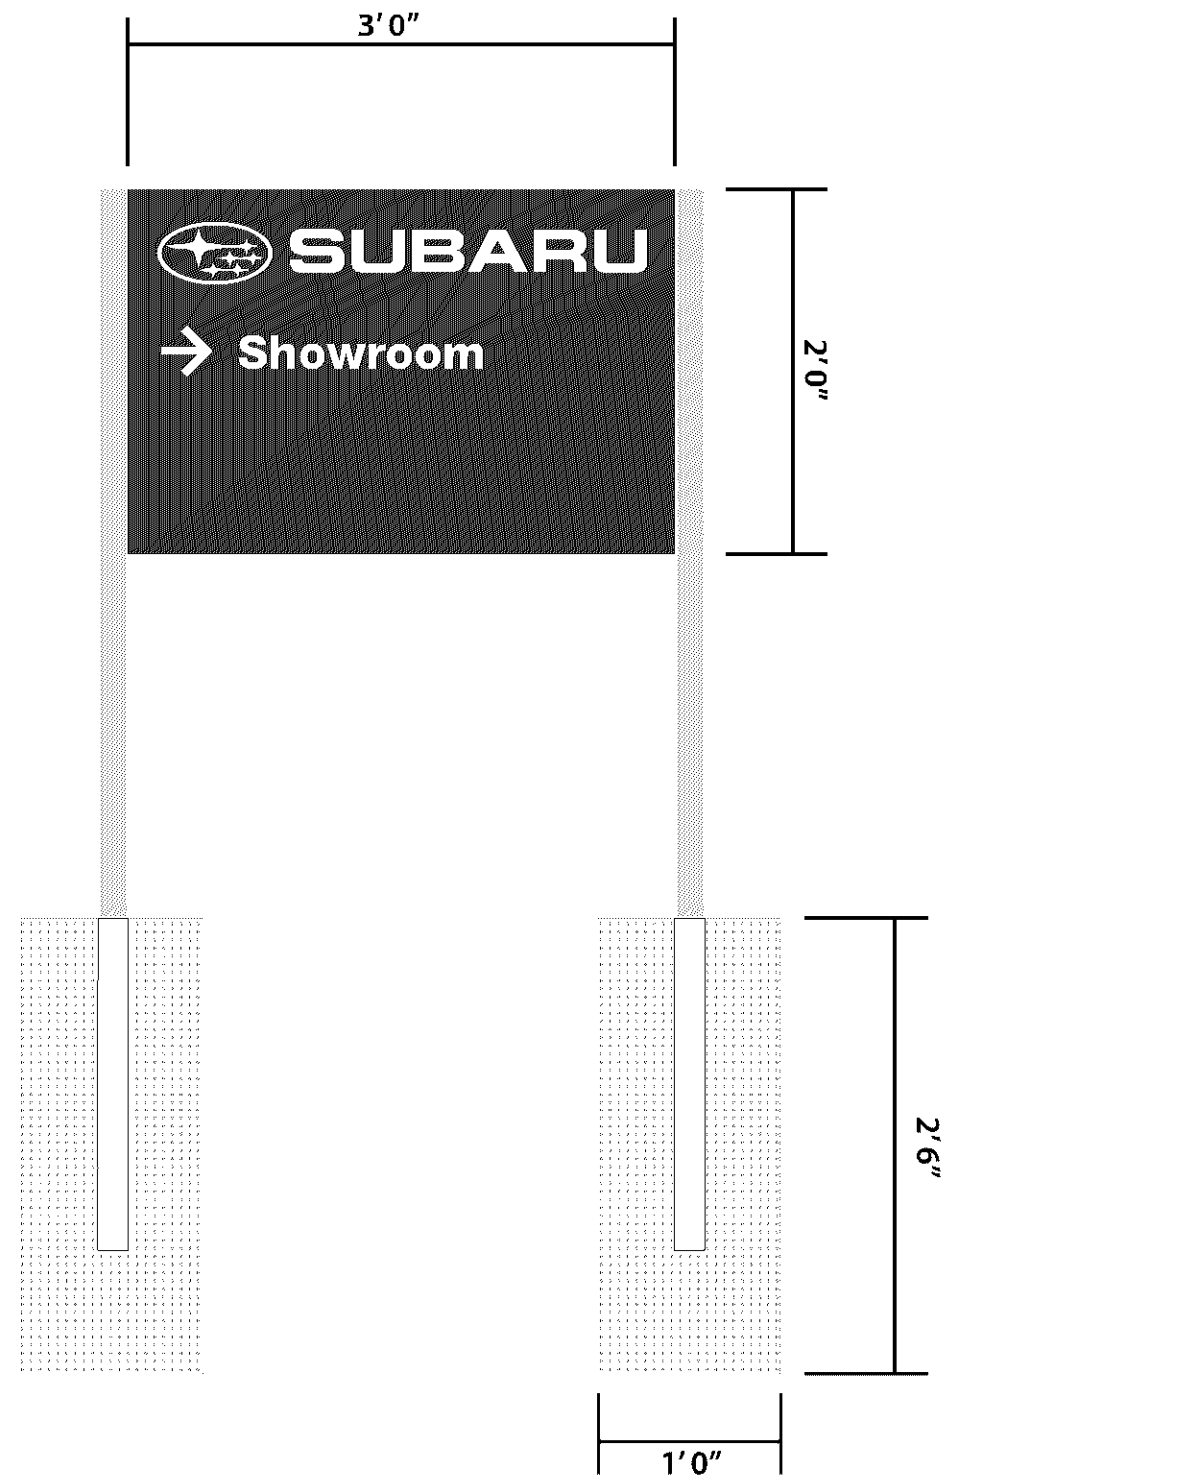

Side A



Side B



TITLE	Subaru	DWG BY	AFR	DATE	12.17.14	DATE	REVISION	BY	
ADDRESS	SUB_Regulatories Samples			DWG NUM	B58649				
				SHEET	2				


THIS IS AN ORIGINAL UNPUBLISHED DRAWING CREATED BY P.S.C.O. IT IS SUBMITTED FOR YOUR PERSONAL USE IN CONNECTION WITH A PROJECT BEING PLANNED FOR YOU BY P.S.C.O. IT IS NOT TO BE SHOWN TO ANYONE OUTSIDE YOUR ORGANIZATION NOR IS IT TO BE USED, COPIED, REPRODUCED, OR EXHIBITED IN ANY FASHION.

PL201900150

PL2019-150

48" DIRECTIONAL


DIRECTIONAL SIGN 2' 4-1/2"H X 4' 0"W
SINGLE OR DOUBLE SIDED W/ TWIN POLES AND
WHITE REFLECTIVE GRAPHICS.
OPTION FOR INTERNALLY ILLUMINATED WITH LIT
WHITE ACRYLIC GRAPHICS.
SAMPLE COPY SHOWN; TO VARY PER
DAELER'S NEEDS

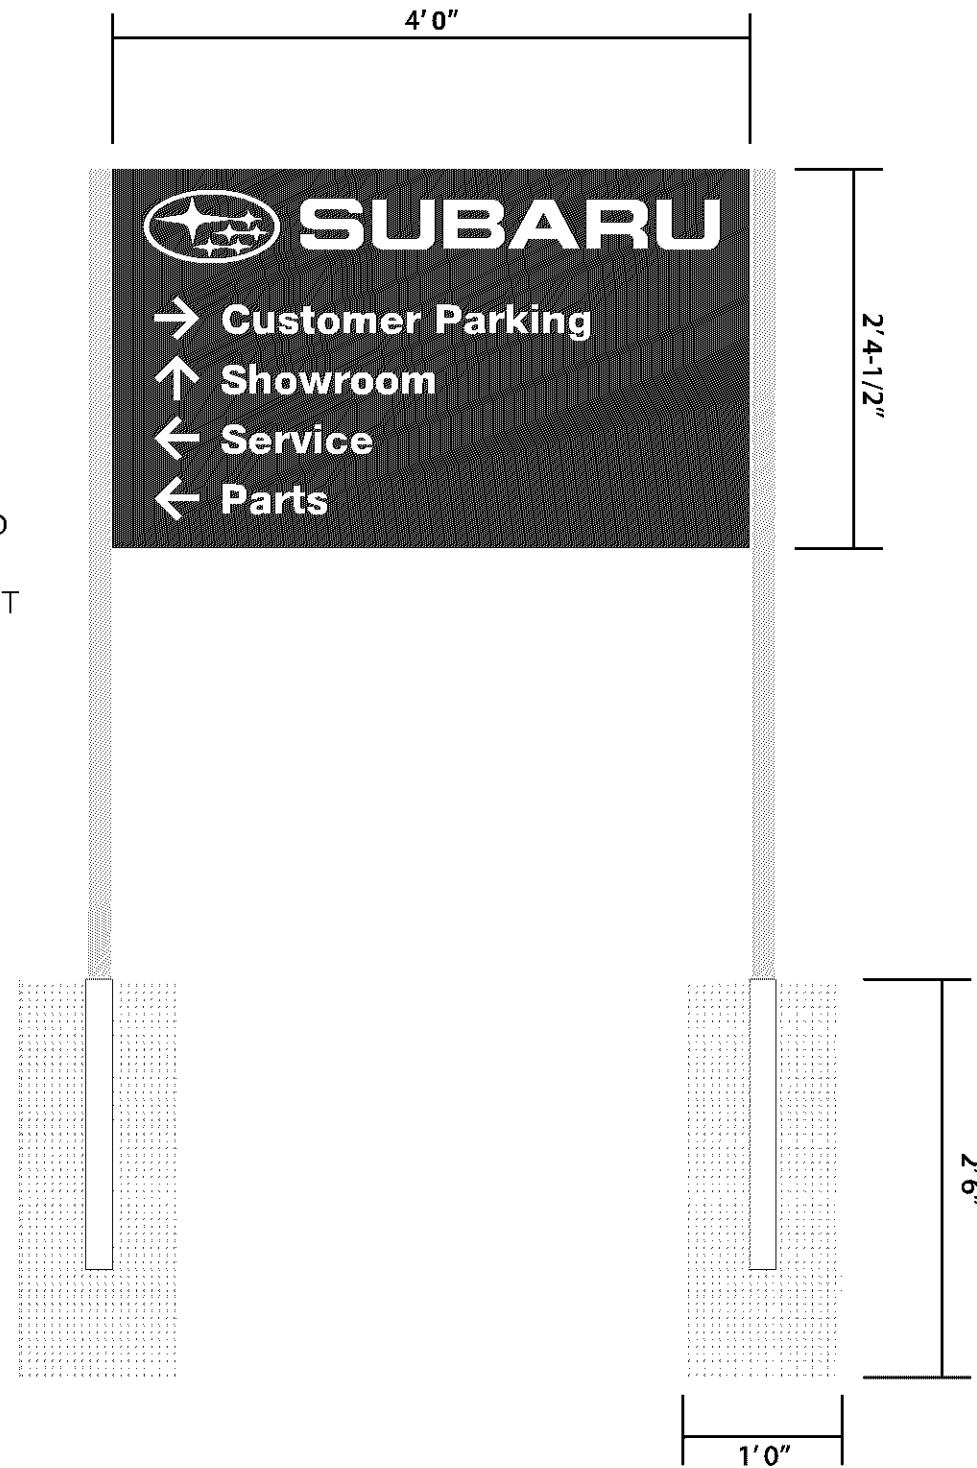

Side A




Side B


 PHILADELPHIASIGN <small>BRINGING THE WORLD'S BRANDS TO LIFE</small>	TITLE	Subaru	DWG BY	AFR	DATE	12.17.14	DATE	REVISION	BY	<small>THIS IS AN ORIGINAL UNPUBLISHED DRAWING CREATED BY P.S.C.O. IT IS SUBMITTED FOR YOUR PERSONAL USE IN CONNECTION WITH A PROJECT BEING PLANNED FOR YOU BY P.S.C.O. IT IS NOT TO BE SHOWN TO ANYONE OUTSIDE YOUR ORGANIZATION NOR IS IT TO BE USED, COPIED, REPRODUCED, OR EXHIBITED IN ANY FASHION.</small>	
	ADDRESS	SUB_Regulatories Samples		DWG NUM	B58649						
					SHEET	3					

PL201900150

PL2019-150

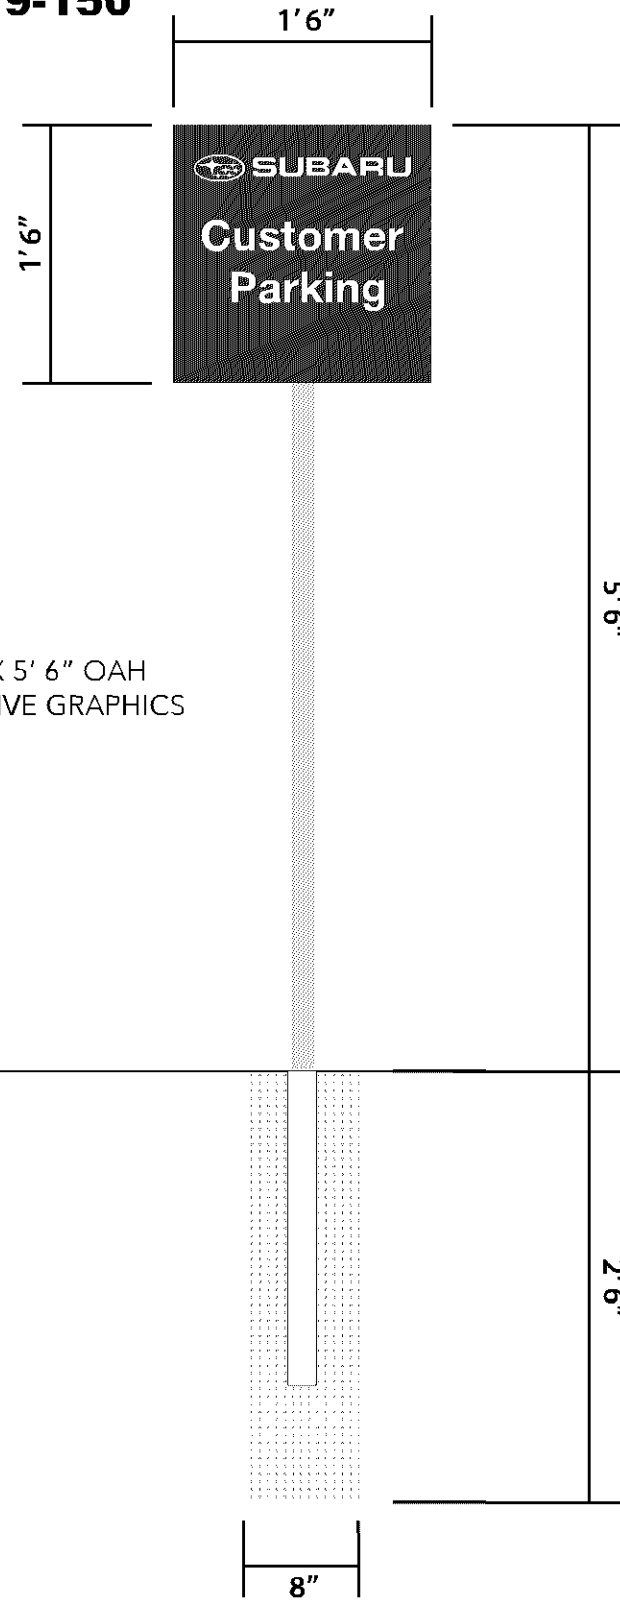

INFO BLADE SIGN SIGN 18" H X 18" W X 5' 6" OAH
POLE MOUNTED WITH WHITE REFLECTIVE GRAPHICS
SAMPE COPY: CUSTOMER PARKING

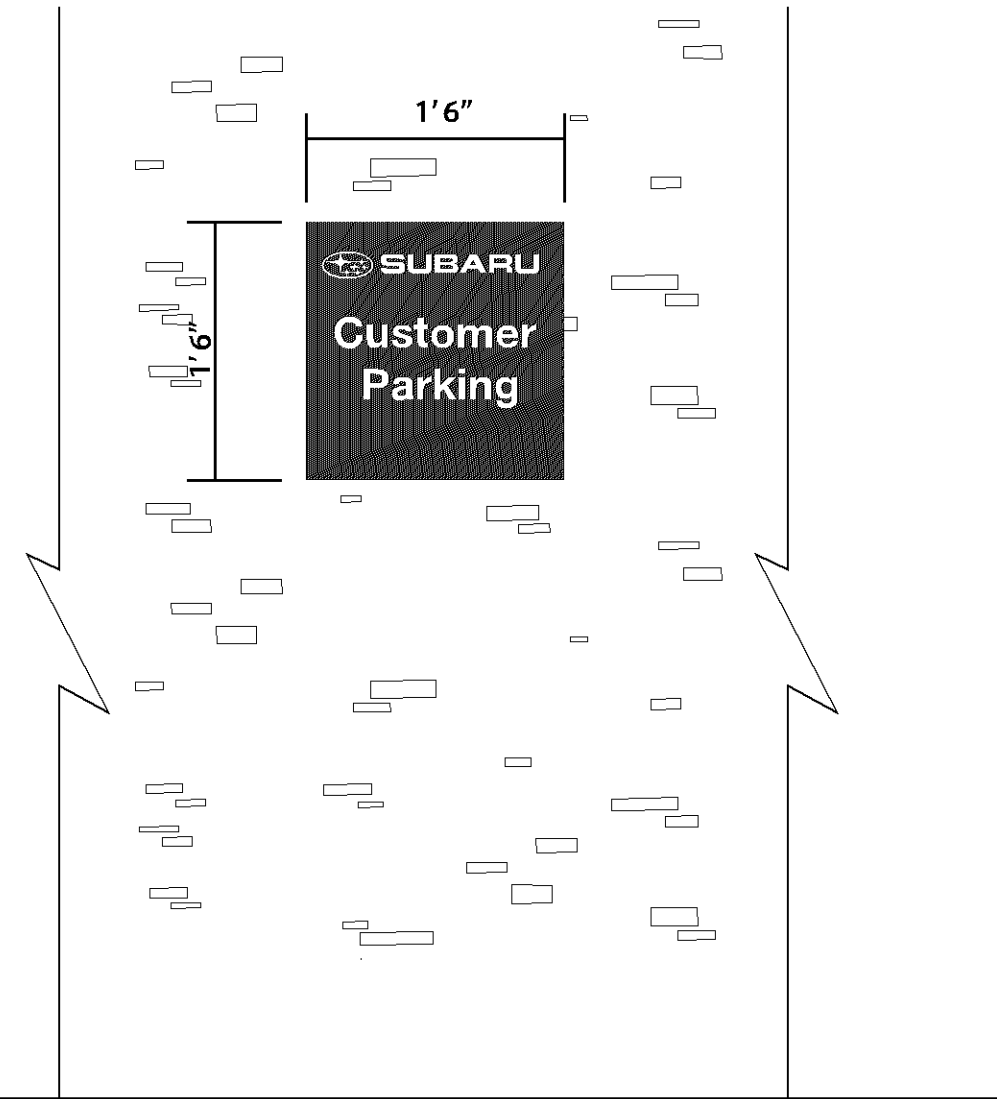

INFO WALL PLAQUE SIGN 18" H X 18"
WALL MOUNTED WITH WHITE REFLECTIVE GRAPHICS
SAMPE COPY: CUSTOMER PARKING




TITLE	Subaru	DWG BY	AFR	DATE	12.17.14	DATE	REVISION	---	BY	
ADDRESS	SUB_Regulatories Samples		DWG NUM	B58649						
			SHEET	4						

THIS IS AN ORIGINAL UNPUBLISHED DRAWING CREATED BY P.S.C.O. IT IS SUBMITTED FOR YOUR PERSONAL USE IN CONNECTION WITH A PROJECT BEING PLANNED FOR YOU BY P.S.C.O. IT IS NOT TO BE SHOWN TO ANYONE OUTSIDE YOUR ORGANIZATION NOR IS IT TO BE USED, COPIED, REPRODUCED, OR EXHIBITED IN ANY FASHION.

PL201900150

PL2019-150



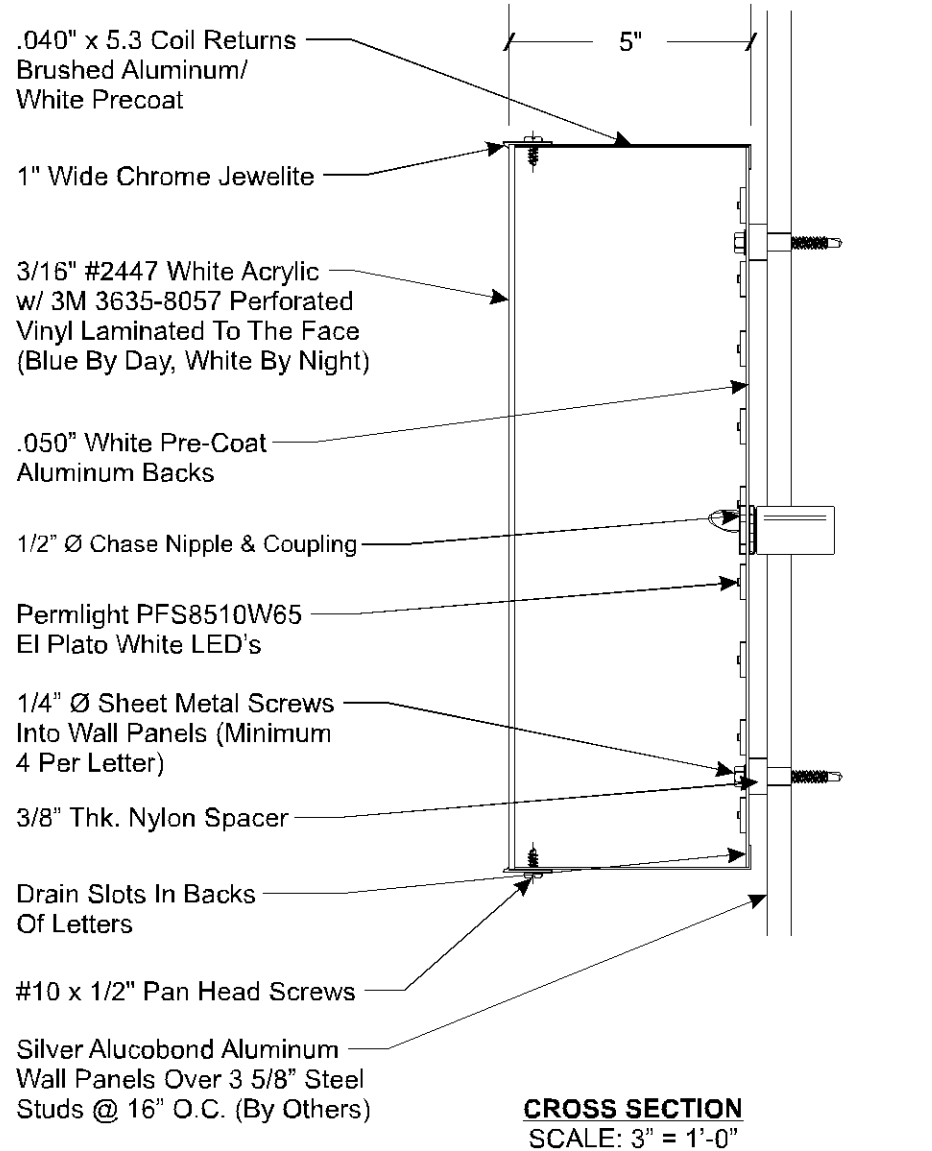


ELECTRICAL LOAD 12" (2.0) Amps @ 120 Volts ELECTRICAL REQ'MTS (1) 20 Amp/120 Volt Circuit	ELECTRICAL LOAD 18" (2.0) Amps @ 120 Volts ELECTRICAL REQ'MTS (1) 20 Amp/120 Volt Circuit	ELECTRICAL LOAD 24" (2.0) Amps @ 120 Volts ELECTRICAL REQ'MTS (1) 20 Amp/120 Volt Circuit
--	--	--

Note: This sign is intended to be installed in accordance with the requirements of Article 600 of the National Electrical Code and/or other applicable local codes. This includes proper grounding and bonding of the sign.

- STANDARD LETTER NOTES:**
1. Sufficient Primary Circuit In Vicinity Of Sign By Others.
 2. Letter To Letter Wiring & Final Primary Hook-up By Sign Installer, Where Allowed By Local Codes.
 3. Sign Shall Be U.L. Listed.
 4. Mounting Hardware By Sign Installer.
 5. Full Size Drilling Template Furnished With Sign.

- WIRING NOTES:**
- Bank 1 - Entire Letter S, E, & R.
 - Bank 2 - Entire Letter V, I, C, & E.
 - Bank 3 - No WIRING to Bank 3
 - Bank 4 - No WIRING to Bank 4

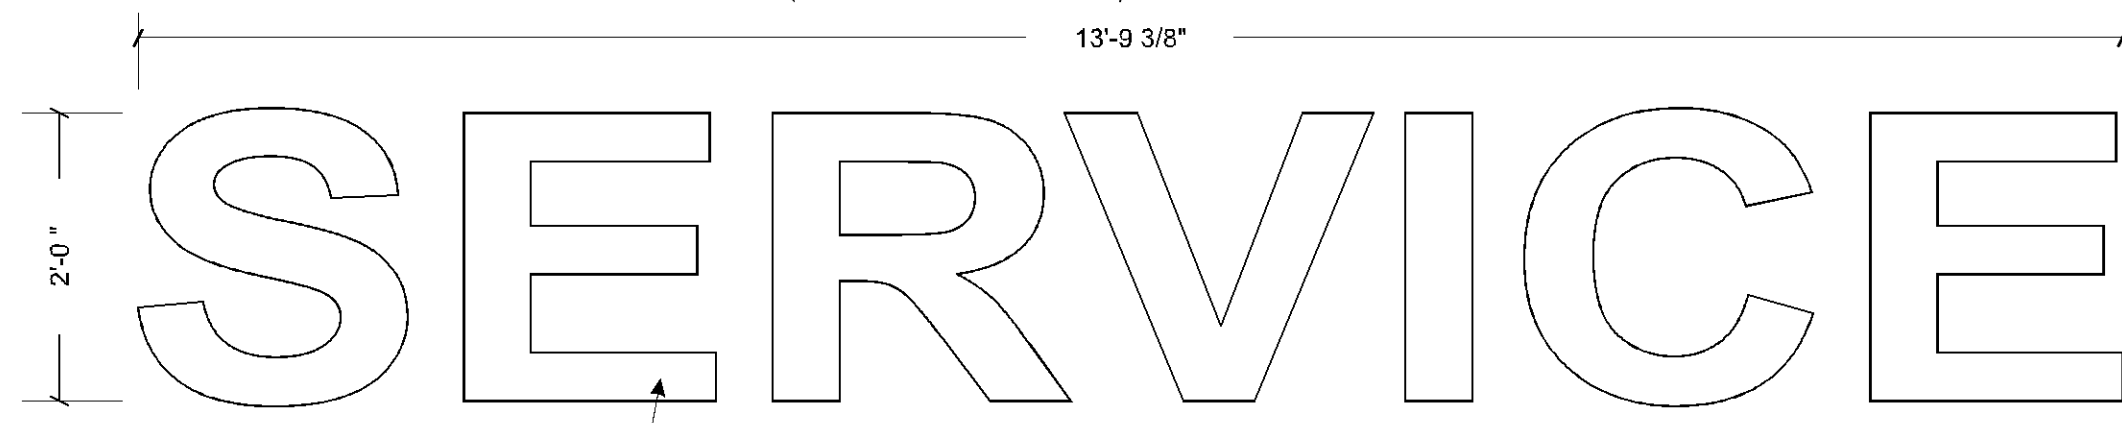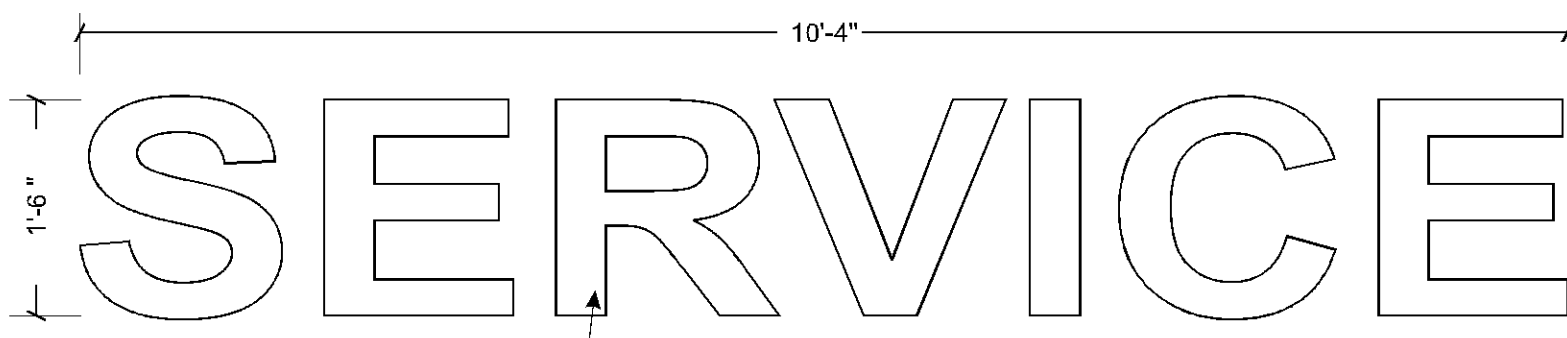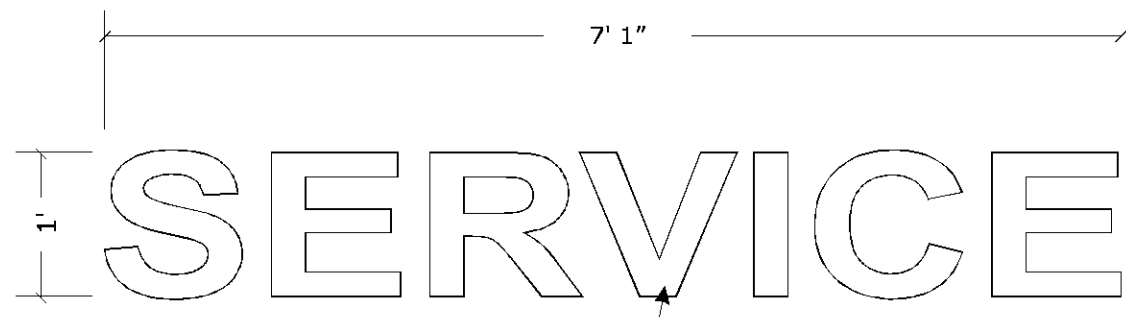

**PERMITS
ONLY**

LETTER ELEVATIONS
SCALE: 3/4" = 1'-0"

**Philadelphia Sign
COMPANY**

707 West Spring Garden Street
Palmyra, New Jersey 08065

Phone: 856 829 1460
Fax: 856 829 8549
E-mail: mail@philadelphiasign.com

CUSTOMER:
SUBARU

JOB NUMBER:

REVISIONS:

Date:	Description:	By:
1.		
2.		
3.		
4.		
5.		
6.		
7.		
8.		
9.		

DRAWING TYPE:
PERMIT DRAWING

SIGN TYPE:
12", 18", 24" T/W LETTERS

LOCATION:
VARIOUS

DATE:
10-25-06

DRAWN BY:
TS

SHEET:
1 of 2

DWG NUMBER:
B-23628

THIS IS AN ORIGINAL UNPUBLISHED DRAWING CREATED BY P.S.C.O. IT IS SUBMITTED FOR YOUR PERSONAL USE IN CONJUNCTION WITH A PROJECT BEING PLANNED FOR YOU BY P.S.C.O. IT IS NOT TO BE SHOWN TO ANYONE OUTSIDE YOUR ORGANIZATION NOR IS IT TO BE USED, COPIED, REPRODUCED, OR EXHIBITED IN ANY FASHION.


PL201900150
PL2019-150

PERMITS
ONLY

ELECTRICAL LOAD 12" (2.0) Amps @ 120 Volts ELECTRICAL REQ'MTS (1) 20 Amp/120 Volt Circuit	ELECTRICAL LOAD 18" (2.0) Amps @ 120 Volts ELECTRICAL REQ'MTS (1) 20 Amp/120 Volt Circuit	ELECTRICAL LOAD 24" (2.0) Amps @ 120 Volts ELECTRICAL REQ'MTS (1) 20 Amp/120 Volt Circuit
--	--	--

Note: This sign is intended to be installed in accordance with the requirements of Article 600 of the National Electrical Code and/or other applicable local codes. This includes proper grounding and bonding of the sign.

- STANDARD LETTER NOTES:**
1. Sufficient Primary Circuit In Vicinity Of Sign By Others.
 2. Letter To Letter Wiring & Final Primary Hook-up By Sign Installer, Where Allowed By Local Codes.
 3. Sign Shall Be U.L. Listed.
 4. Mounting Hardware By Sign Installer.
 5. Full Size Drilling Template Furnished With Sign

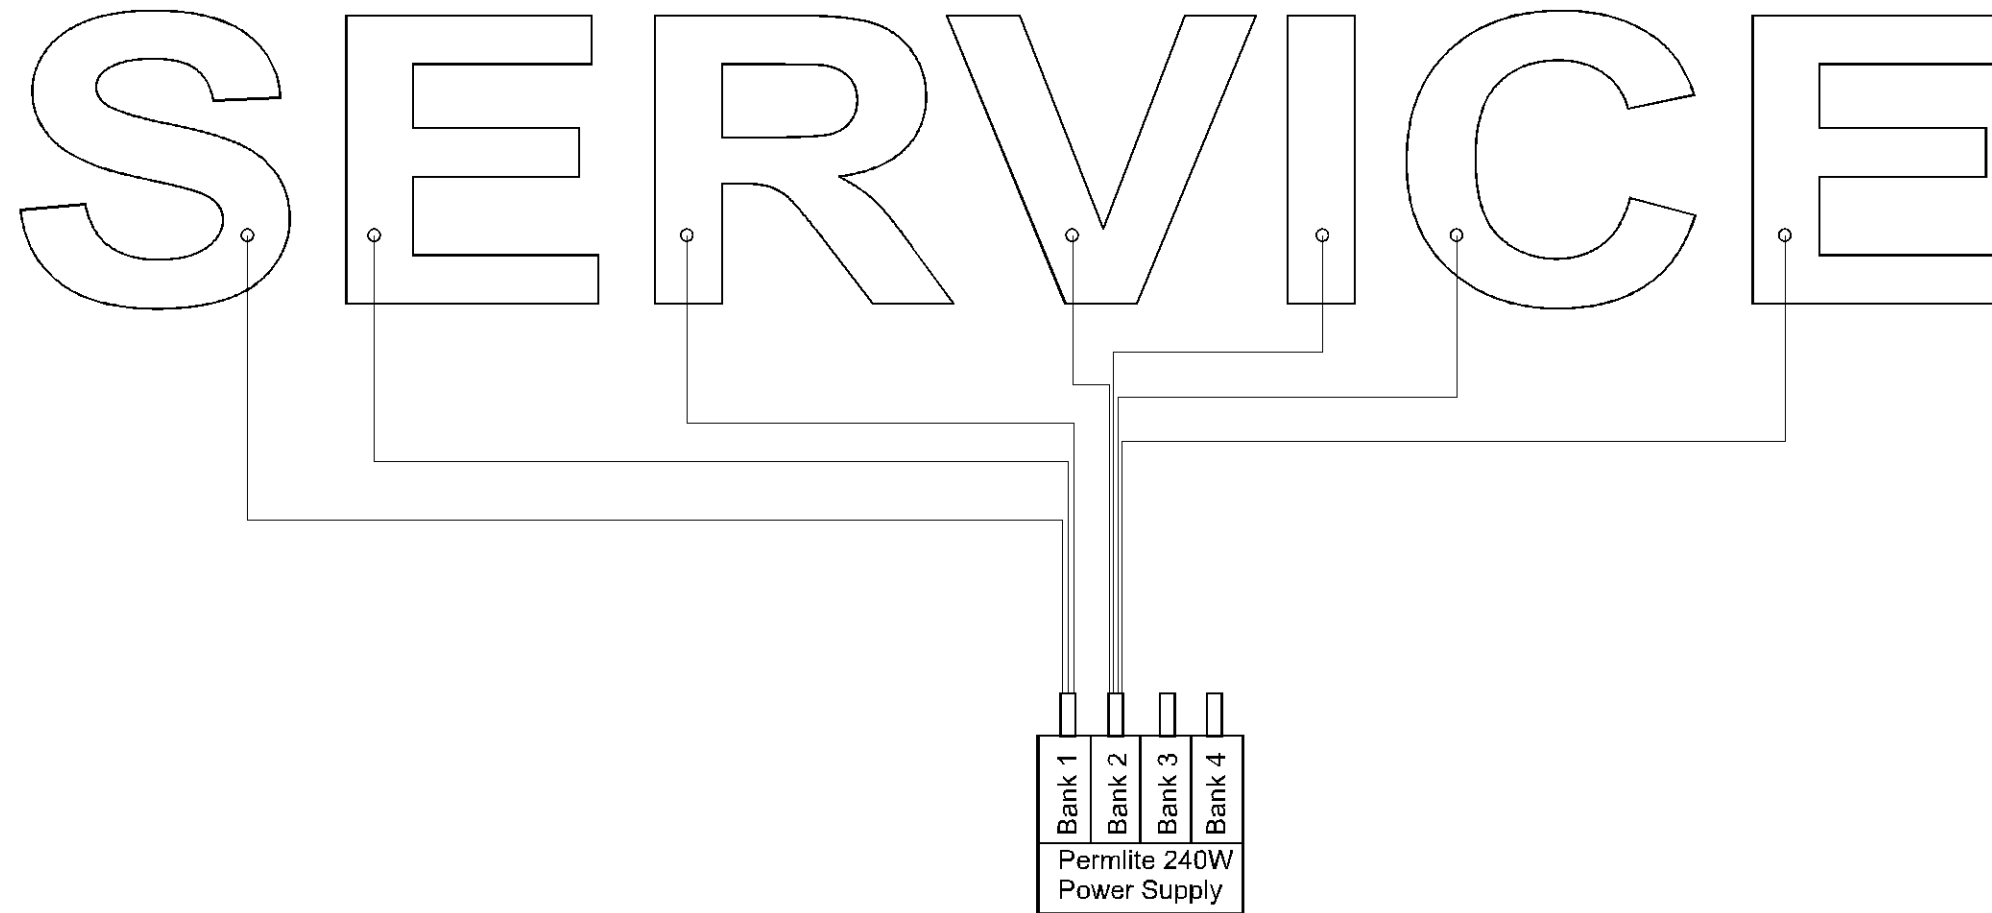

WIRING DIAGRAM LETTER ELEVATION
NOT TO SCALE

- WIRING NOTES:**
- Bank 1 - Entire Letter S, E, & R.
 - Bank 2 - Entire Letter V, I, C, & E.
 - Bank 3 - No WIRING to Bank 3
 - Bank 4 - No WIRING to Bank 4



**Philadelphia Sign
C O M P A N Y**

707 West Spring Garden Street
Palmyra, New Jersey 08065

Phone: 856 829 1460
Fax: 856 829 8549
E-mail: mail@philadelphiasign.com

CUSTOMER:

SUBARU

JOB NUMBER:

REVISIONS:

Date:	Description:	By:
1.		
2.		
3.		
4.		
5.		
6.		
7.		
8.		
9.		

DRAWING TYPE:

PERMIT DRAWING

SIGN TYPE:

12", 18", 24" TW LETTERS

LOCATION:

VARIOUS

DATE:

10-25-06

DRAWN BY:

TS

SHEET:

2 of 2

DWG NUMBER:

B-23628

THIS IS AN ORIGINAL UNPUBLISHED DRAWING CREATED BY P.S.C.O. IT IS SUBMITTED FOR YOUR PERSONAL USE IN CONJUNCTION WITH A PROJECT BEING PLANNED FOR YOU BY P.S.C.O. IT IS NOT TO BE SHOWN TO ANYONE OUTSIDE YOUR ORGANIZATION NOR IS IT TO BE USED, COPIED, REPRODUCED, OR EXHIBITED IN ANY FASHION.

PL201900150

PL2019-150

**CONSTRUCTION
DRAWING**



PHILADELPHIASIGN
BRINGING THE WORLD'S BRANDS TO LIFE

707 West Spring Garden Street
Palmyra, New Jersey 08065

Phone: 856.829.1460
Fax: 856.829.8549
www.philadelphiasign.com

CUSTOMER:

SUBARU

JOB NUMBER:

SUB_CL ILL_15383

SIGN TYPE:

LOGO.CHR.36_SUB_LED

LOCATION:

DATE:

11-17-15

DRAWN BY:

RAB

REVISION:

Number: Date: By:

SHEET:


1 of 1

DWG NUMBER:


B65429

ENGINEER SEAL:

MAX DESIGN WIND SPEED 90 MPH
EXPOSURE C

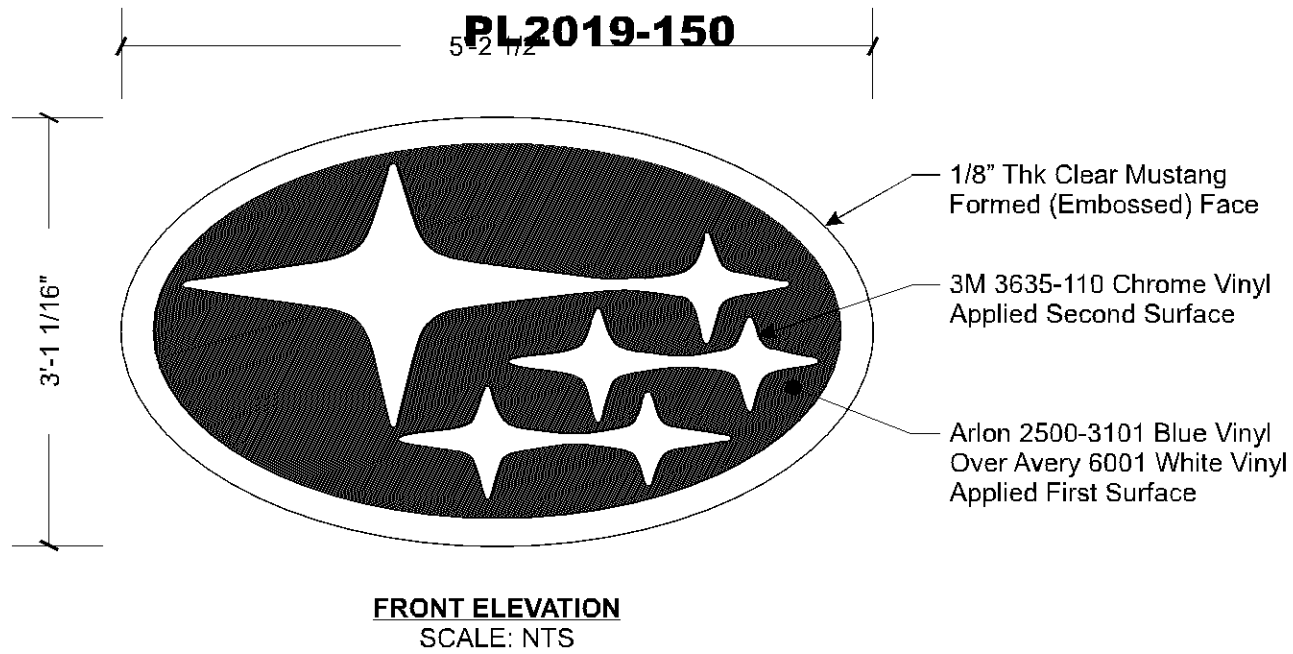

FRONT ELEVATION
SCALE: NTS

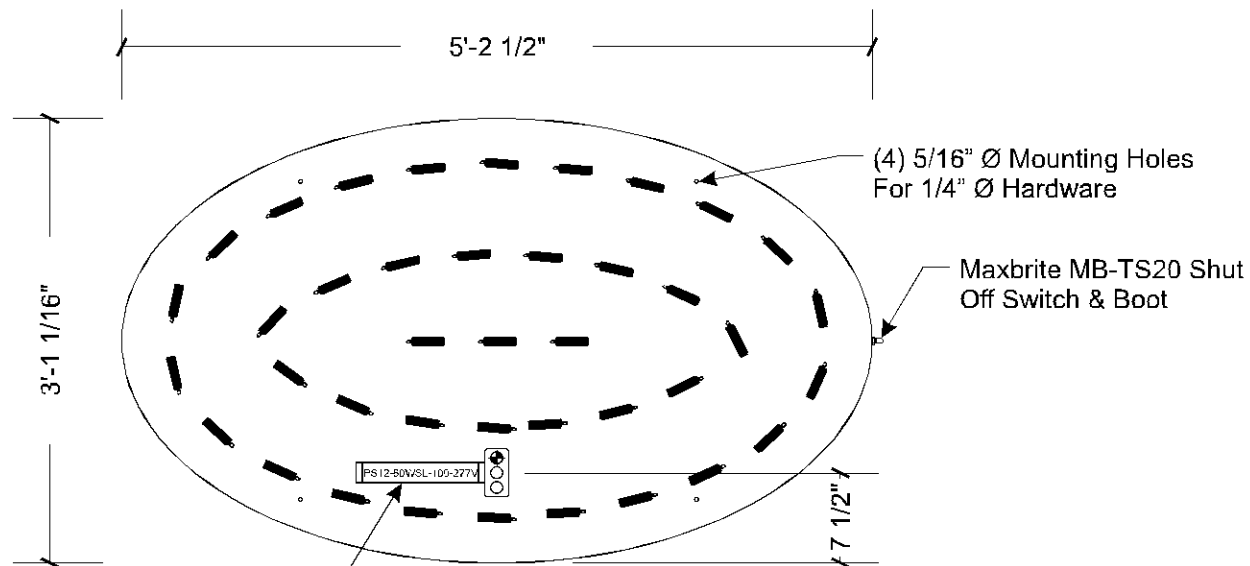

LED LAYOUT
SCALE: 3/4" = 1'-0"


1) PS12-60WSL-100-277V
AgiLight Power Supply

LED Specification

(40) AgiLight Pro215 6500 White
LED's (LS-PRO-215-65K-2G3)

(1) Agilight 60 Watt Power
Supply (PS12-60WSL-100-277V)

**Each 60 Watt Power Supply Will
Run a Maximum of 50 Modules**

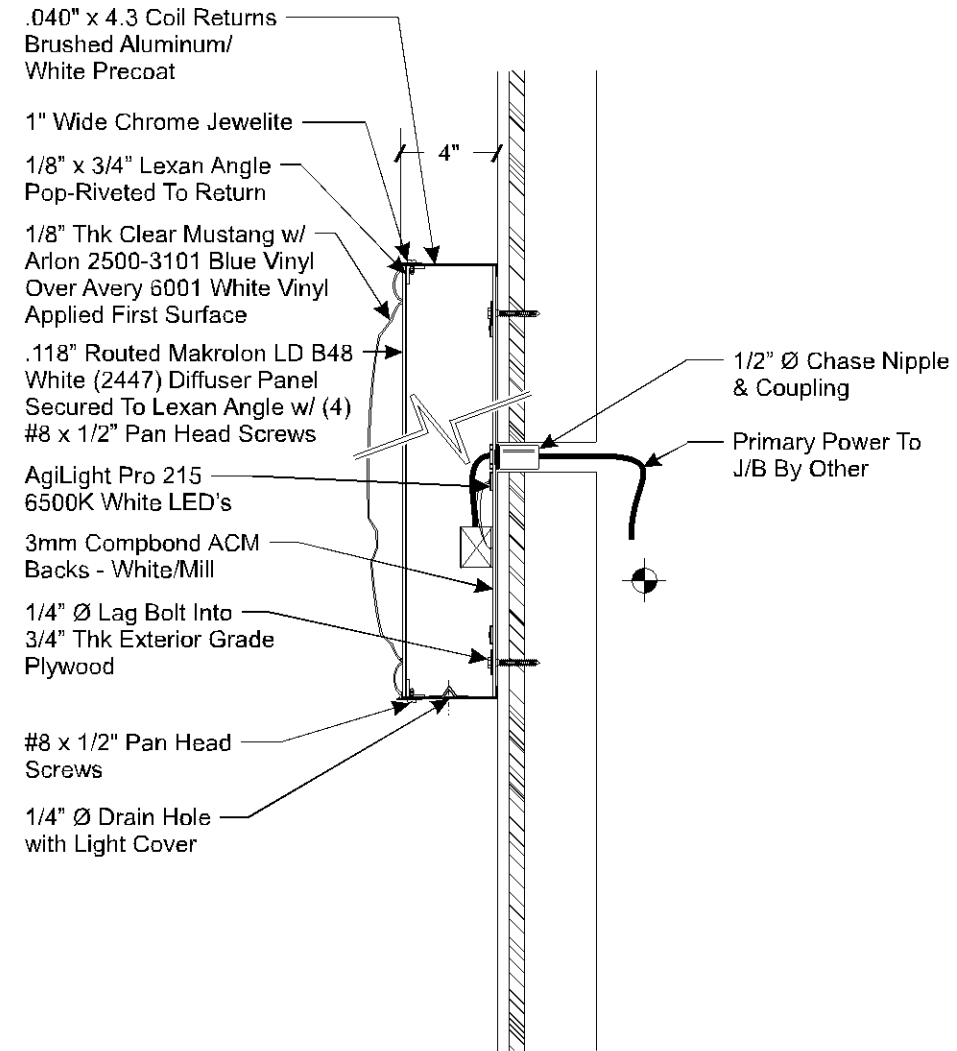

CROSS SECTION
SCALE: 1 1/2" = 1'-0"

Electrical Load
0.63 Amps @ 120 Volts
Electrical Req'ts
(1) 20 Amp/120 Volt Circuits


STANDARD WALL SIGN NOTES:

1. Sufficient Primary Circuit In Vicinity Of Sign By Others.
2. Final Primary Hook-up By Sign Installer, Where Allowed By Local Codes.
3. Sign Shall Be U.L. Listed.
4. Mounting Hardware By Sign Installer.

Note: This sign is intended to be installed in accordance with the requirements of Article 600 of the National Electrical Code and/or other applicable local codes. This includes proper grounding and bonding of the sign.

THIS IS AN ORIGINAL UNPUBLISHED DRAWING CREATED BY PSGO. IT IS SUBMITTED FOR YOUR PERSONAL USE IN CONJUNCTION WITH A PROJECT BEING PLANNED FOR YOU BY PSGO. IT IS NOT TO BE SHOWN TO ANYONE OUTSIDE YOUR ORGANIZATION NOR IS IT TO BE USED, COPIED, REPRODUCED, OR EXHIBITED IN ANY FASHION.

PL201900150

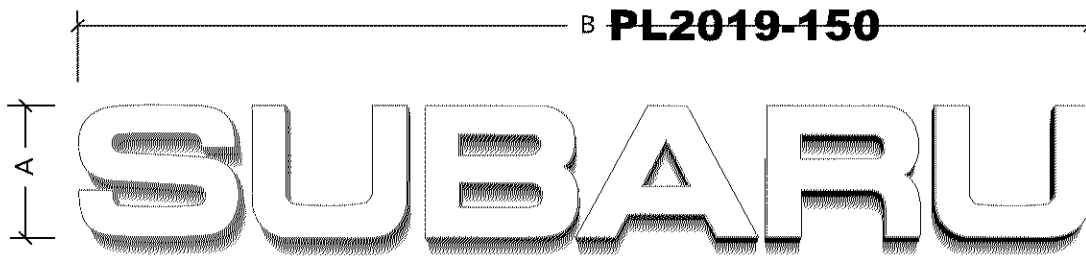

Night Channel Letter Elevation

Scale: NTS

Night Channel Letter Specifications


#2447 White Acrylic w/Perforated 3M Vinyl VDN-10968 3630-137 European Blue/210 White Vinyl Dual Color Film Laminated to Face (Blue By Day, White By Night)

White Precoat Returns Painted Matthews 281342SP Brushed Aluminum

1" Wide Chrome Jewelite


15mm 6500 White Neon Tubes

60ma 120 volt Transformer

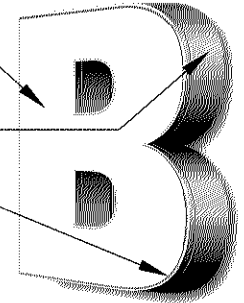

Color Schedule

Letter Faces	3M Vinyl VDN-10968 3630-137 European Blue/210 White Vinyl Dual Color Film Laminated to Face (Day=Blue/Night=White)
Trimcap	Chrome Jewelite
Returns	Matthews 281342SP Brushed Alum.

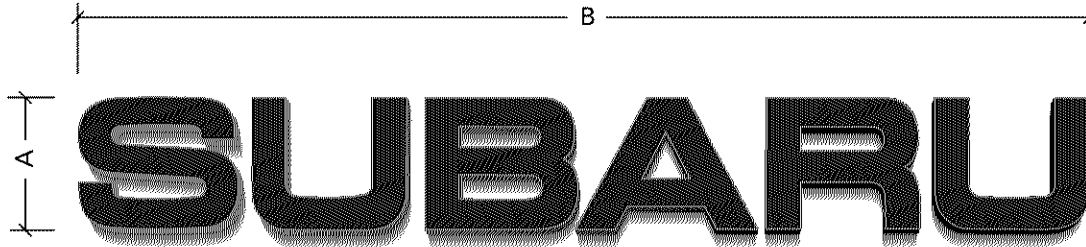

Day Channel Letter Elevation

Scale: NTS

Day Channel Letter Specifications


#2447 White Acrylic w/Perforated 3M Vinyl VDN-10968 3630-137 European Blue/210 White Vinyl Dual Color Film Laminated to Face (Blue By Day, White By Night)

White Precoat Returns Painted Matthews 281342SP Brushed Aluminum

1" Wide Chrome Jewelite

15mm 6500 White Neon Tubes

60ma 120 volt Transformer

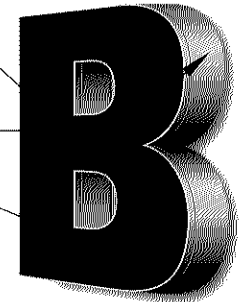


Color Schedule

Letter Faces	3M Vinyl VDN-10968 3630-137 European Blue/210 White Vinyl Dual Color Film Laminated to Face (Day=Blue/Night=White)
Trimcap	Chrome Jewelite
Returns	Matthews 281342SP Brushed Alum.

Sign Type	A	B	Sq Ft	Face
CLB.18_SUB	18"	12' 10"	19.25	Acrylic
CLB.24_SUB	24"	17' 1-1/4"	34.21	Acrylic
CLB.36_SUB	36"	25' 7-3/4"	76.94	Acrylic

PL201900150

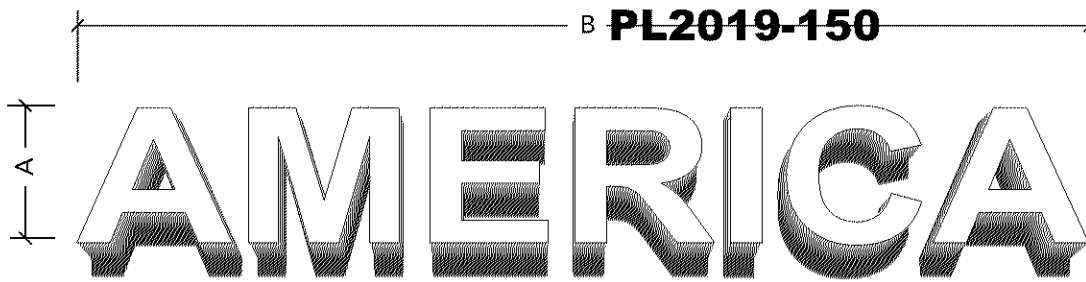

Night Channel Letter Elevation

Scale: NTS

Night Channel Letter Specifications


#2447 White Acrylic w/Perforated 3M Vinyl VDN-10968 3630-137 European Blue/210 White Vinyl Dual Color Film Laminated to Face (Blue By Day, White By Night)

White Precoat Returns Painted Matthews 281342SP Brushed Aluminum

1" Wide Chrome Jewelite


White LED Lit

Raceway to match building fascia

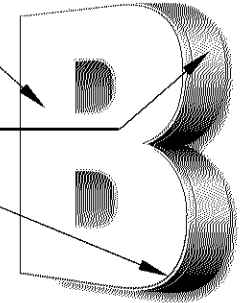

Color Schedule

Letter Faces	3M Vinyl VDN-10968 3630-137 European Blue/210 White Vinyl Dual Color Film Laminated to Face (Day=Blue/Night=White)
Trimcap	Chrome Jewelite
Returns	Matthews 281342SP Brushed Alum.
Raceway	Painted to match fascia

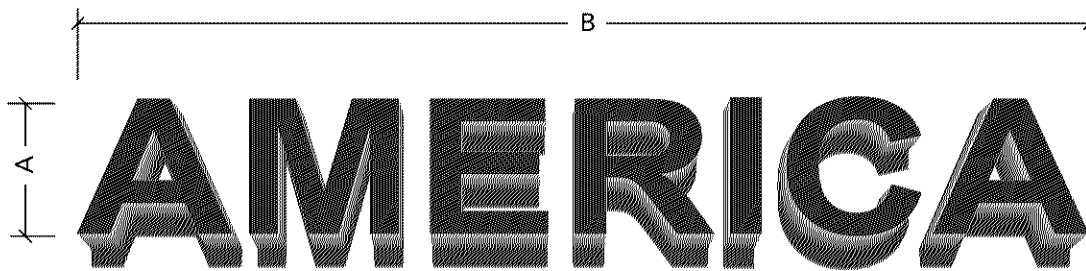

Day Channel Letter Elevation

Scale: NTS

Day Channel Letter Specifications


#2447 White Acrylic w/Perforated 3M Vinyl VDN-10968 3630-137 European Blue/210 White Vinyl Dual Color Film Laminated to Face (Blue By Day, White By Night)

White Precoat Returns Painted Matthews 281342SP Brushed Aluminum

1" Wide Chrome Jewelite

White LED Lit

Raceway to match building fascia

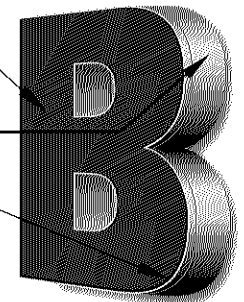


Color Schedule

Letter Faces	3M Vinyl VDN-10968 3630-137 European Blue/210 White Vinyl Dual Color Film Laminated to Face (Day=Blue/Night=White)
Trimcap	Chrome Jewelite
Returns	Matthews 281342SP Brushed Alum.
Raceway	Painted to match fascia

Sign Type	A	B	Sq Ft	Face
12" America	12"	7' 3"	7.25	Acrylic
18" America	18"	10' 10-3/8"	16.3	Acrylic
24" America	24"	14' 5-7/8"	28.98	Acrylic
36" America	36"	18' 11-1/2"	56.86	Acrylic

PL201900150

PL2019-150

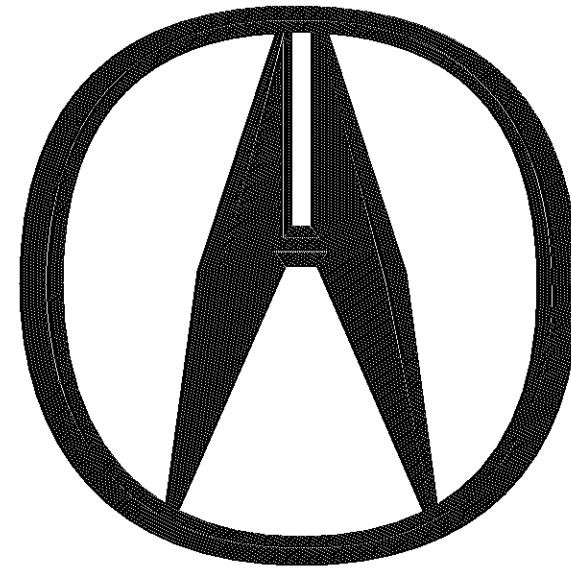

ACURA









Dealership Identification Program & Branding Guidelines









410 N. Cedar Bluff Road Suite 101
Knoxville, Tennessee 37923
www.pattisonsign.com

PL201900150

ACURA Sign Family PL2019-150

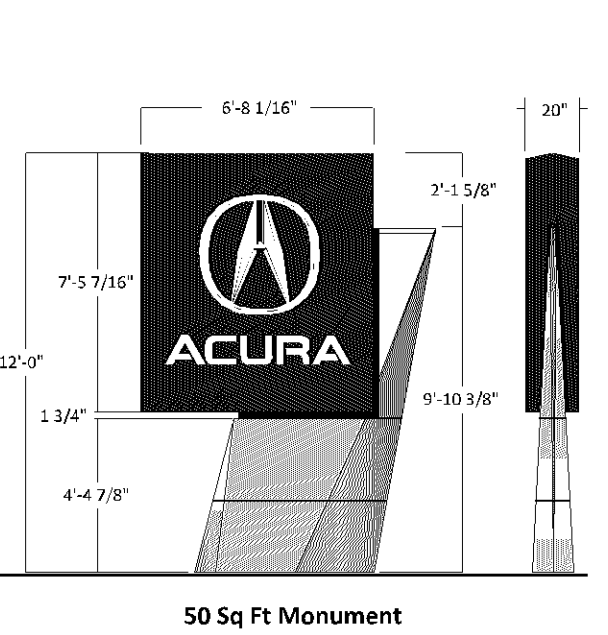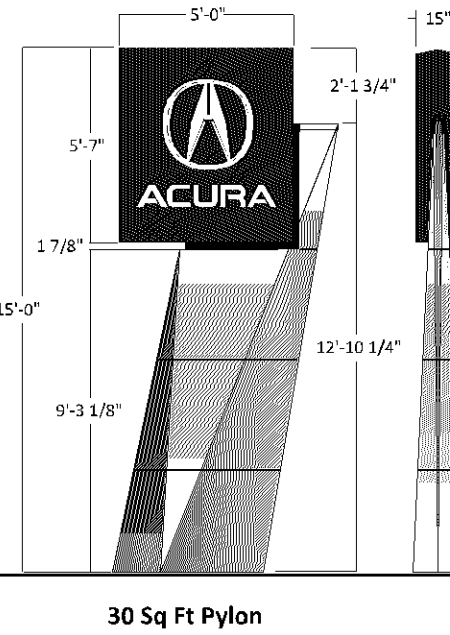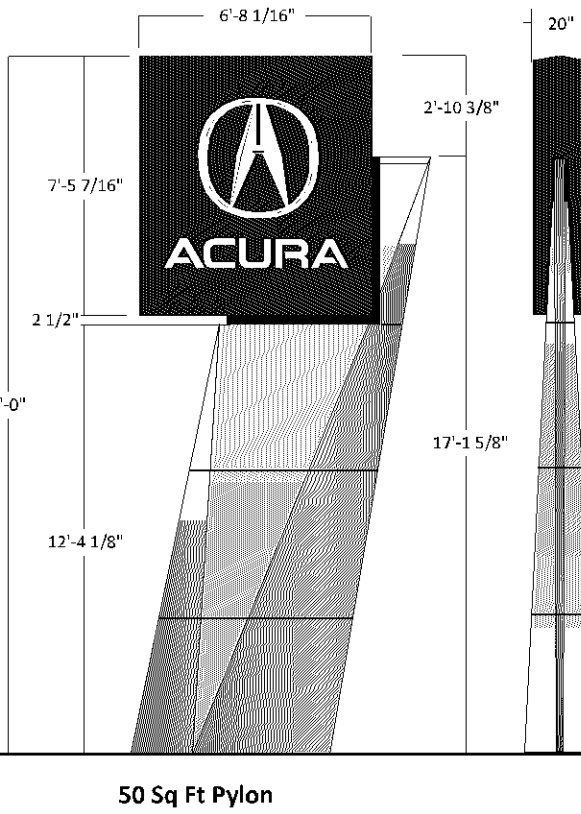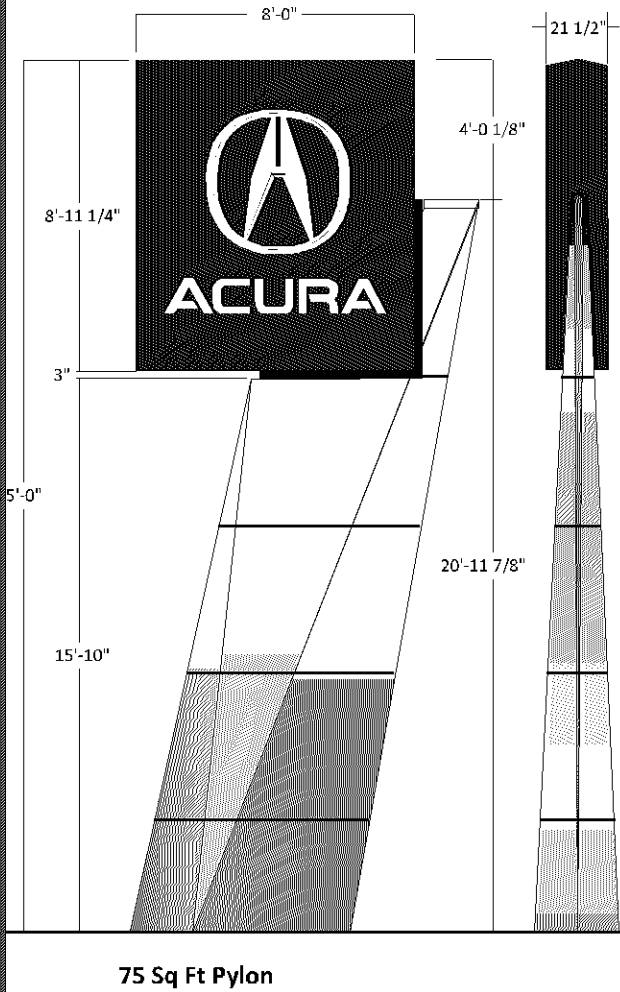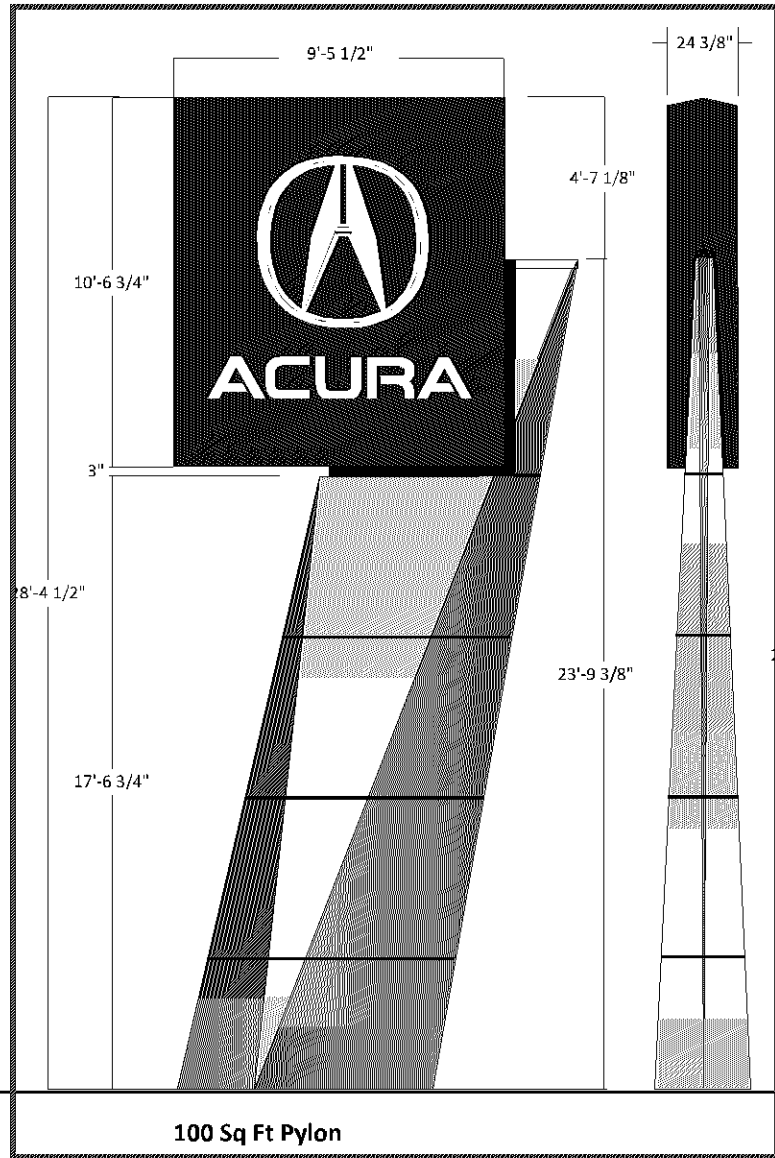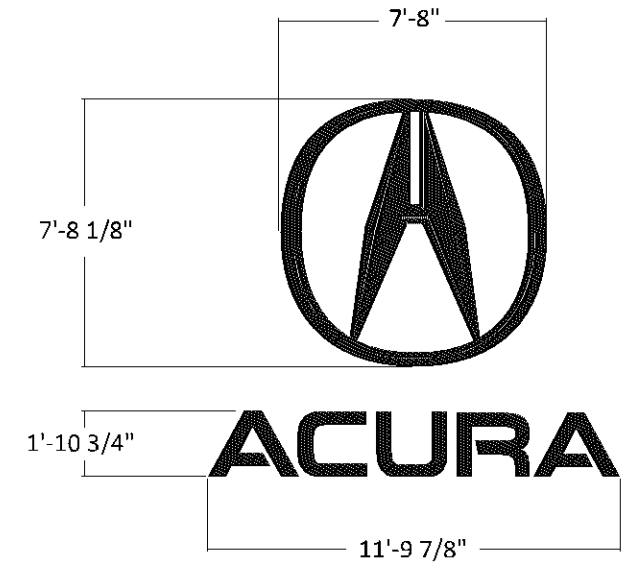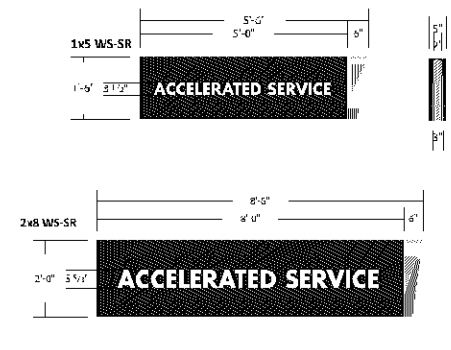
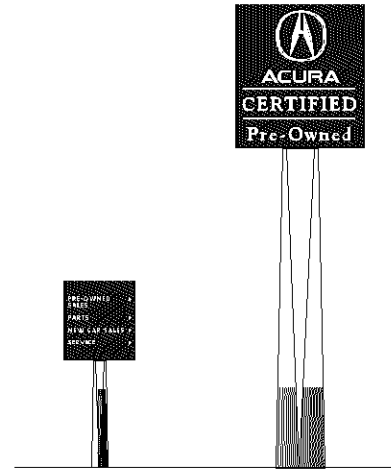


PL201900150

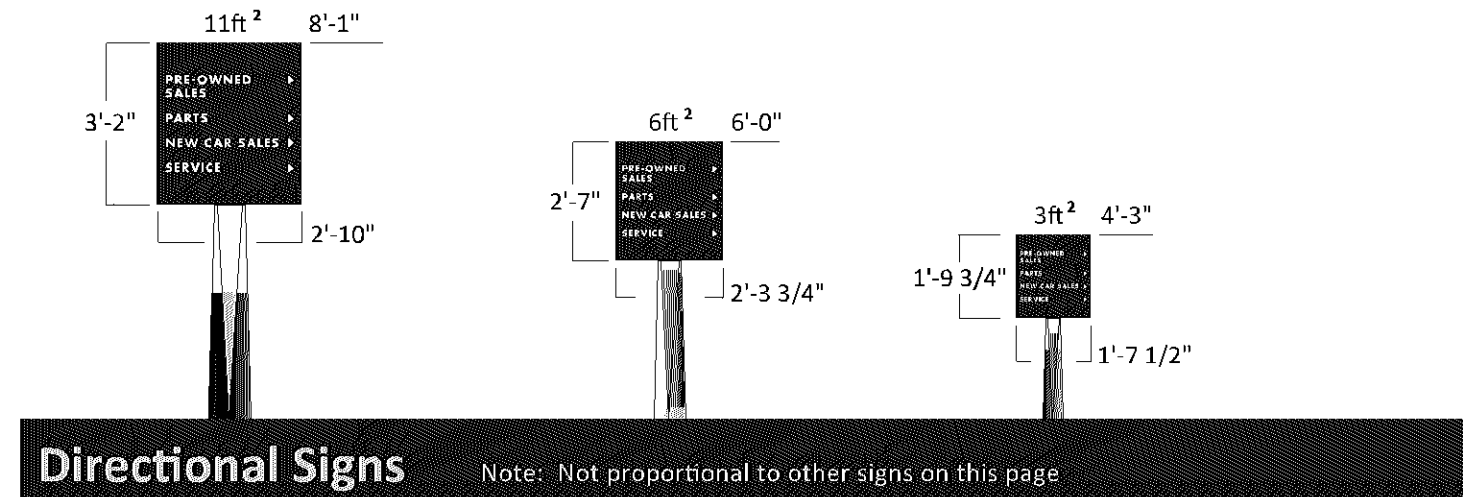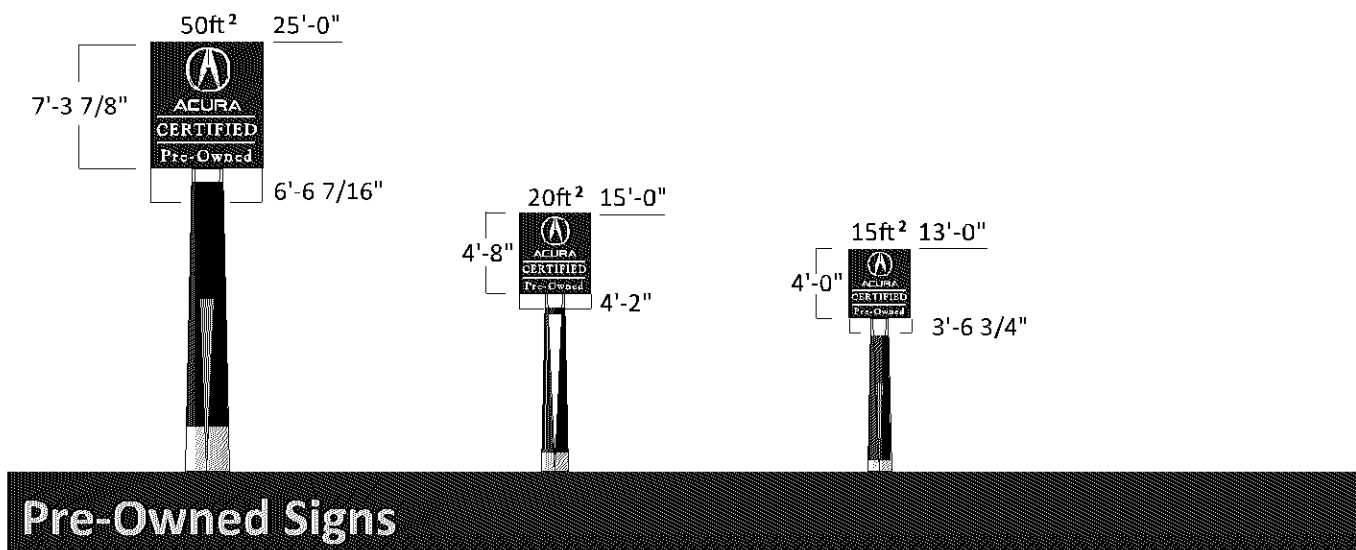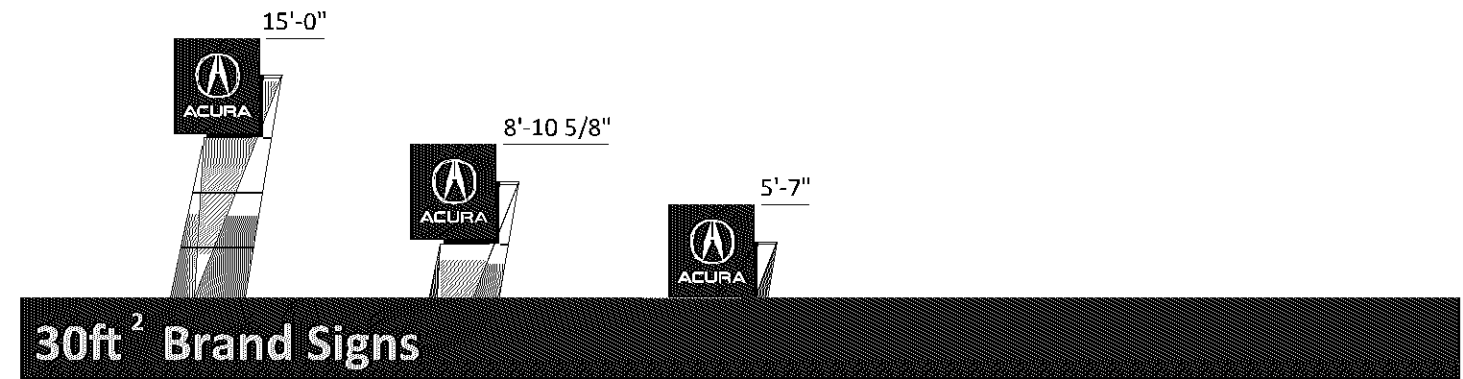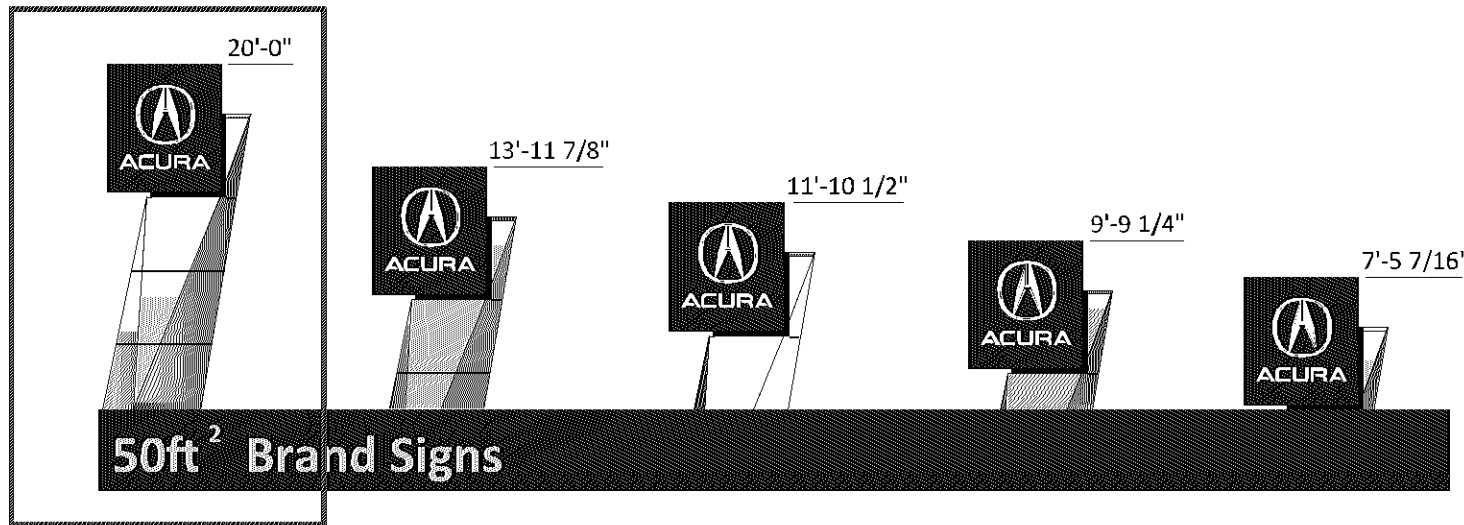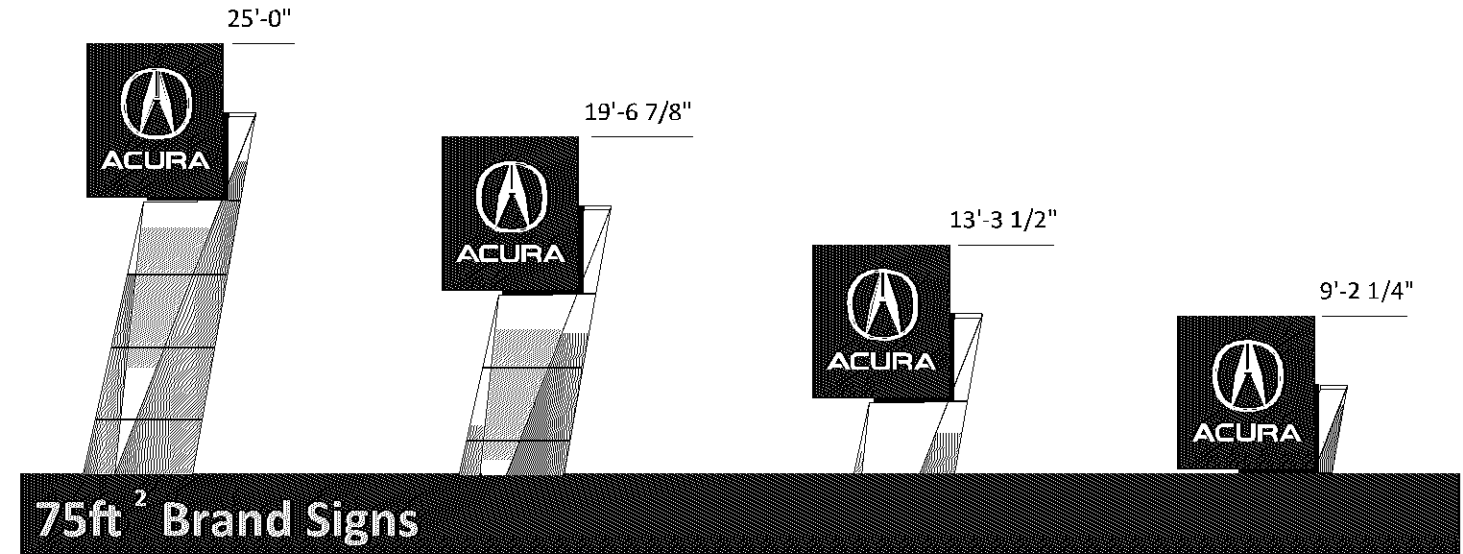
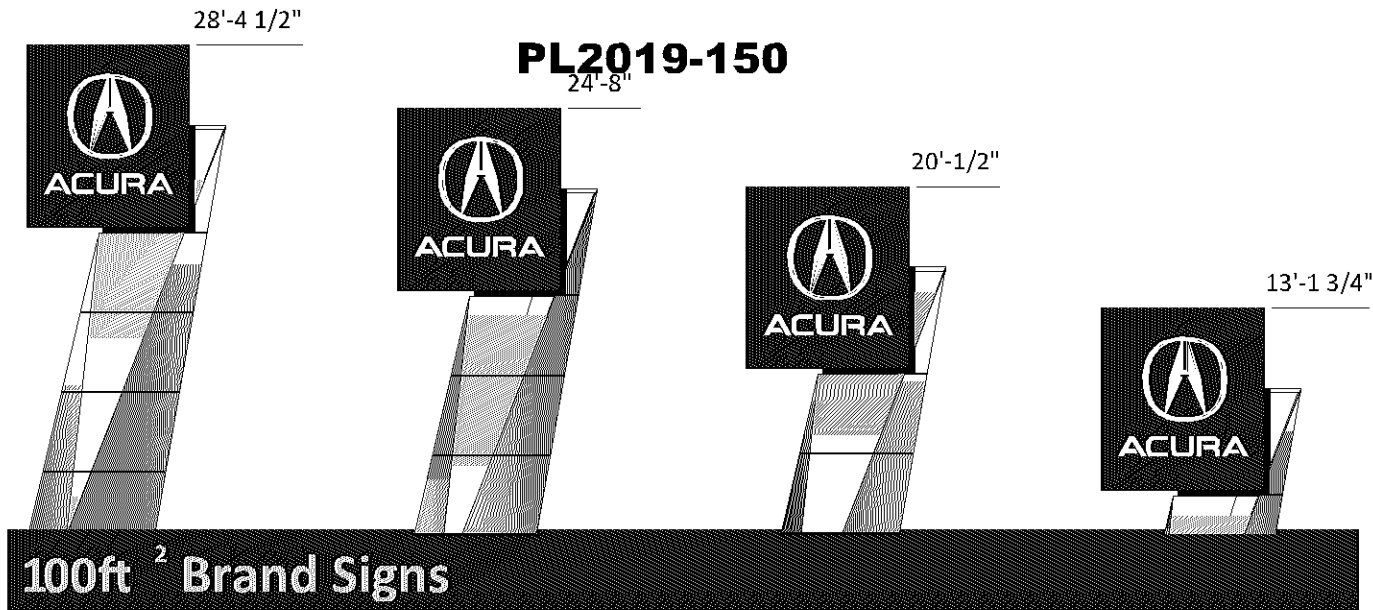


PL201900150

PL2019-150

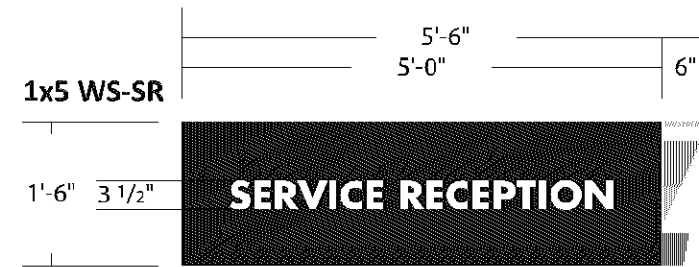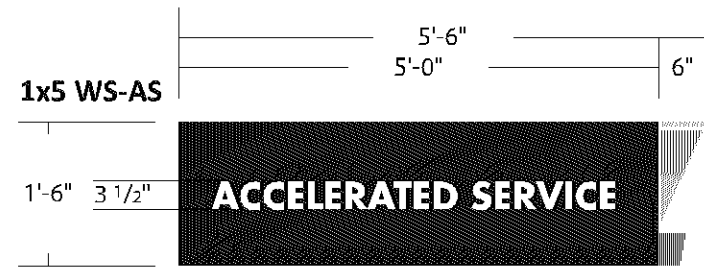

 1x5 Acura S/F Illuminated Wall Sign - Routed Out and Pushed Through

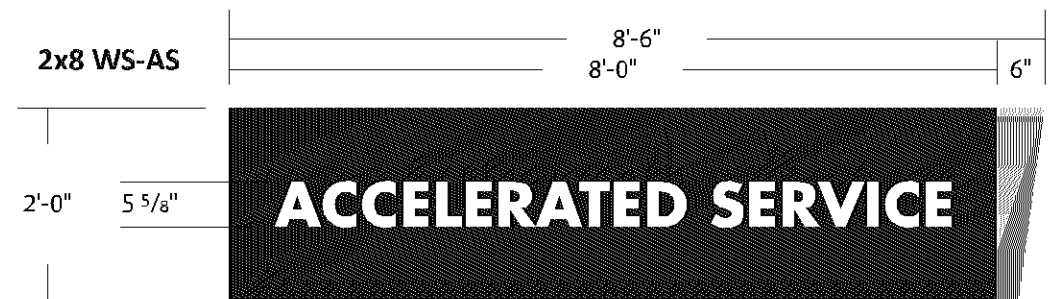

2x8 Acura S/F Illuminated Wall Sign - Routed Out and Pushed Through

PL201900150

PL2019-150

Acura Branding Guidelines

Acura logo and ACURA letterset on tower are illuminated.

Acura logo placement as per Pattison Sign Group install drawing.

Available Trademark "ACURA" letters on secondary elevations are 24" or 18"

Standard DEALER NAME letters are 18" upper case. LED illuminated.
The faces are striped so they are blue by day and white at night.
The dealer name letterset is a minimum of 3' from the edge of the elevation.
Installed 12" above building cap.

The dealer name follows DBA guidelines

"SERVICE" letters are 18" all upper case with elongated letter spacing. LED illuminated.
The faces are striped so they are blue by day and white at night.
Installed center above service bay door(s).

"PRE-OWNED" letters are 18' upper case. LED illuminated.

The Acura Brand sign is 100sf @ 28'. If not permitted by City code, various sizes are available.

The face of the Acura Brand sign faces the street where the "wing" faces back toward the dealership.


Non-illuminated directional signs are cladded and direct burial.

Acura Certified Pre-Owned ground signs are LED illuminated.


All sign elements need to be approved by Interbrand Design Forum and AHM.

Standard Sign Placement

PL201900150
PL2019-150

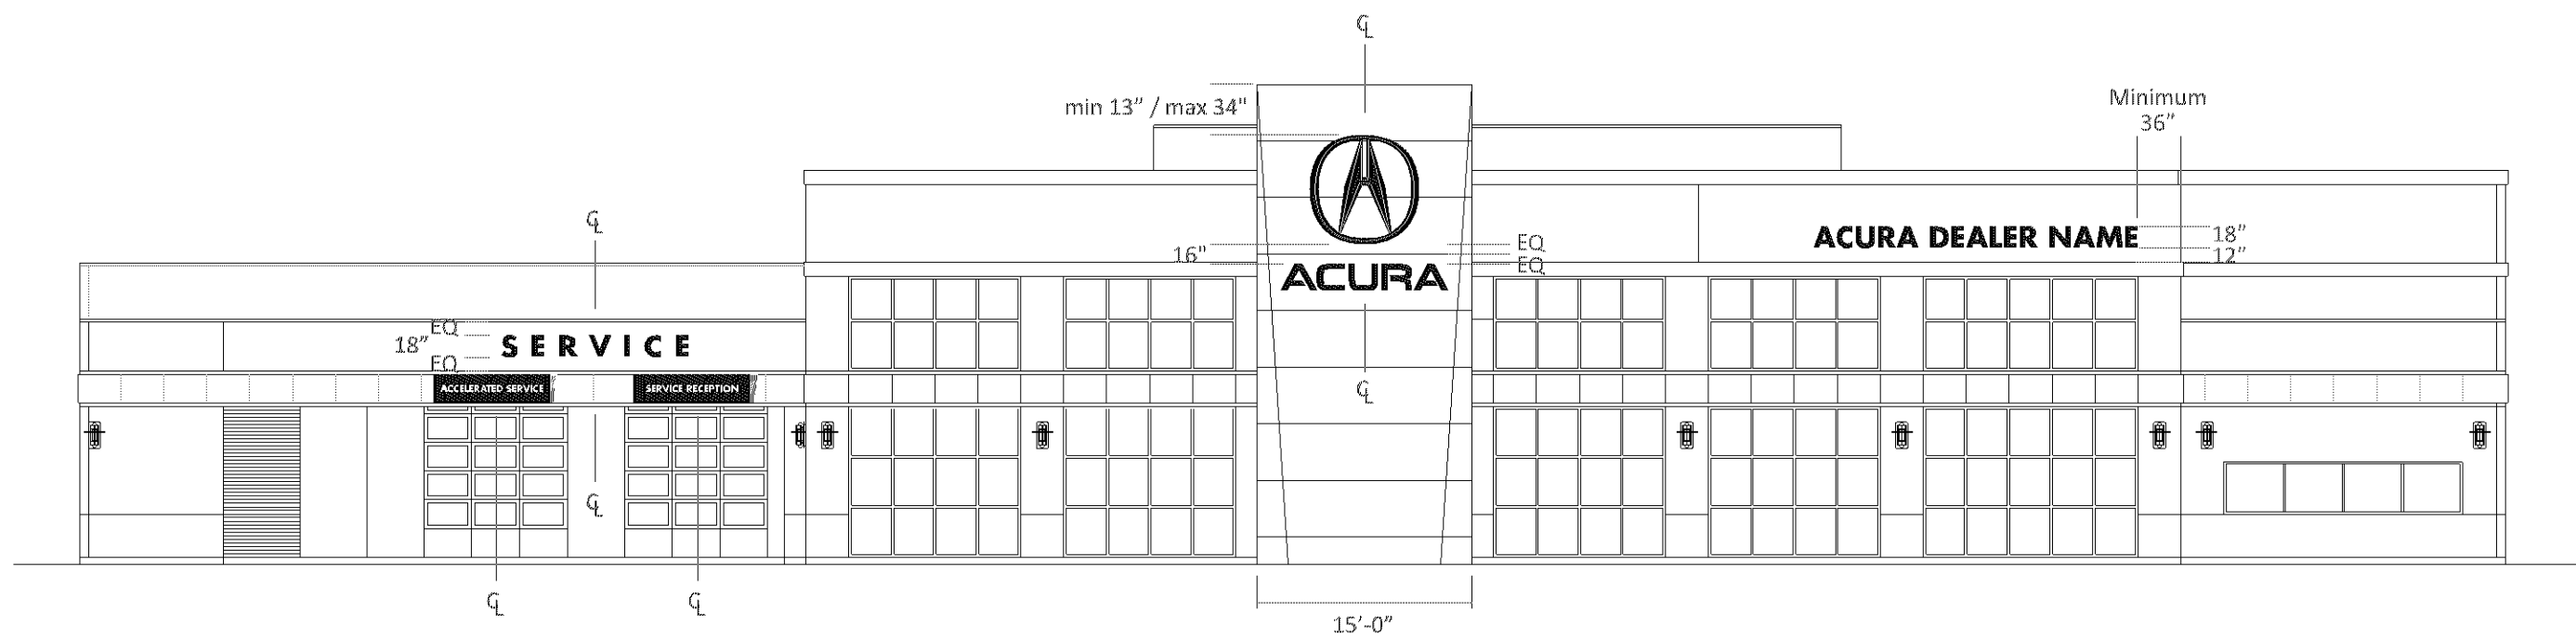

PERFECT

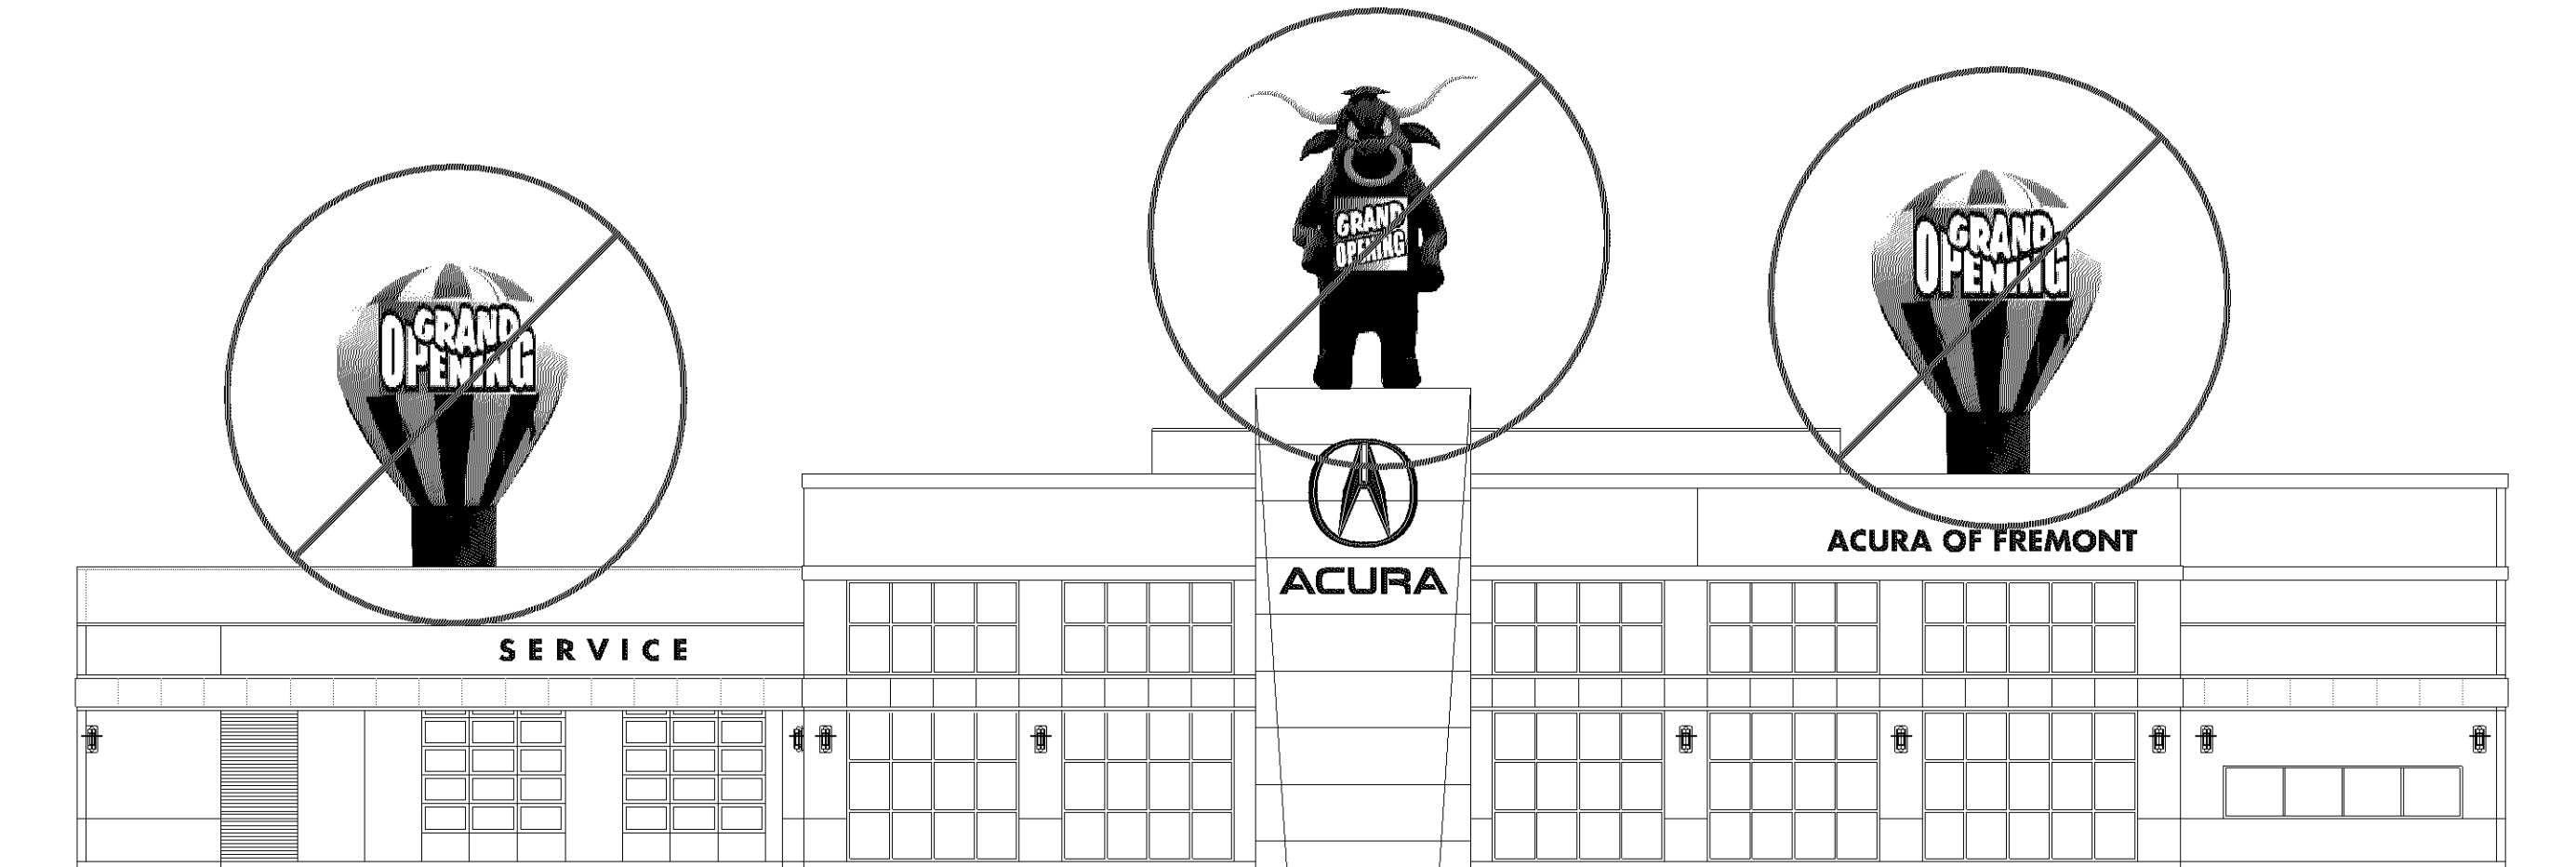

This is not under AHM authority, but wishes that it was!