

SHEET NOTES

1. THIS LIGHTING PLAN ILLUSTRATES ILLUMINATION LEVELS CALCULATED FROM LABORATORY DATA UNDER CONTROLLED CONDITIONS IN ACCORDANCE WITH ILLUMINATING ENGINEERING SOCIETY OF NORTH AMERICA (IESNA) APPROVED METHODS. ACTUAL SITE ILLUMINATION LEVELS AND PERFORMANCE OF LUMINAIRES MAY VARY DUE TO VARIATIONS IN WEATHER, ELECTRICAL VOLTAGE, TOLERANCES IN LAMPS AND OTHER RELATED VARIABLE FIELD CONDITIONS.
2. PROPOSED LIGHTING SOLUTION SUBJECT TO TENANT / LANDLORD AGREEMENT.
3. NOTE: MUNICIPAL STREET LIGHTING HAS NOT BEEN INCLUDED IN THIS STUDY. AMBIENT LIGHT LEVELS MAY VARY FROM THE MODELED LIGHT LEVELS.

CASE #PL2020-14

NELSON
Nelson Architecture & Interiors, Inc.

6000 Lombardo Center Suite #500
Cleveland, OH 44131
Phone: (216) 781-9144

Client Representative:

Roman Hepburn
Tel: 312.805.0199
Email: Hepburn@am.jll.com

Architect:

Nelson Architecture & Interiors, Inc.
Project Manager: Brandon Garnett
T: 312.578.5313
E: bgarnett@nelsonww.com
Architect: Andrew Wehler
T: 216.830.1554
E: awehler@nelsonww.com

Civil:

Civil Site Group
Attn: David Knaeble
T: 763.234.7523
E: dknable@civilsitegroup.com

Structural:

KPFF
Attn: Andrew Cott, PE
T: 212.401.6344
E: andrew.cott@kpff.com

MEP:

Syska Hennessy Group
Attn: Matthew Cassidy
T: 312.588.3562
E: mcassidy@syska.com

Description:	No:	Date:
Issued for Coordination	09/04/2020	
Issued for Coordination	09/11/2020	
Issued for LL Review	09/17/2020	
Issued for Permit and Pricing	10/22/2020	
Issued for Construction	1 06/24/2021	
CD Record Drawings	2 06/25/2021	
Issued For Exterior Lighting	10/28/2021	

BANK OF AMERICA

Oxboro

611 West 98th Street
Bloomington, Minnesota 55420

PROPERTY ID: MN2-529
NSRP VERSION: 2.0
BULLETIN: 2-2020

**ELECTRICAL INITIAL
PHOTOMETRIC SITE PLAN**


PROFESSIONAL ENGINEER
I hereby certify that this plan, specification, or report was prepared by me or under my direct supervision and that I am a duly Licensed Professional Engineer under the laws of the State of Minnesota

Print Name: Joseph J. Romano

Signature: *Joseph J. Romano*
Date: 10/28/2021 License #: 56495

Project No: NCH20040
Drawn By: Approved By: ---
Project Manager:

E04.03

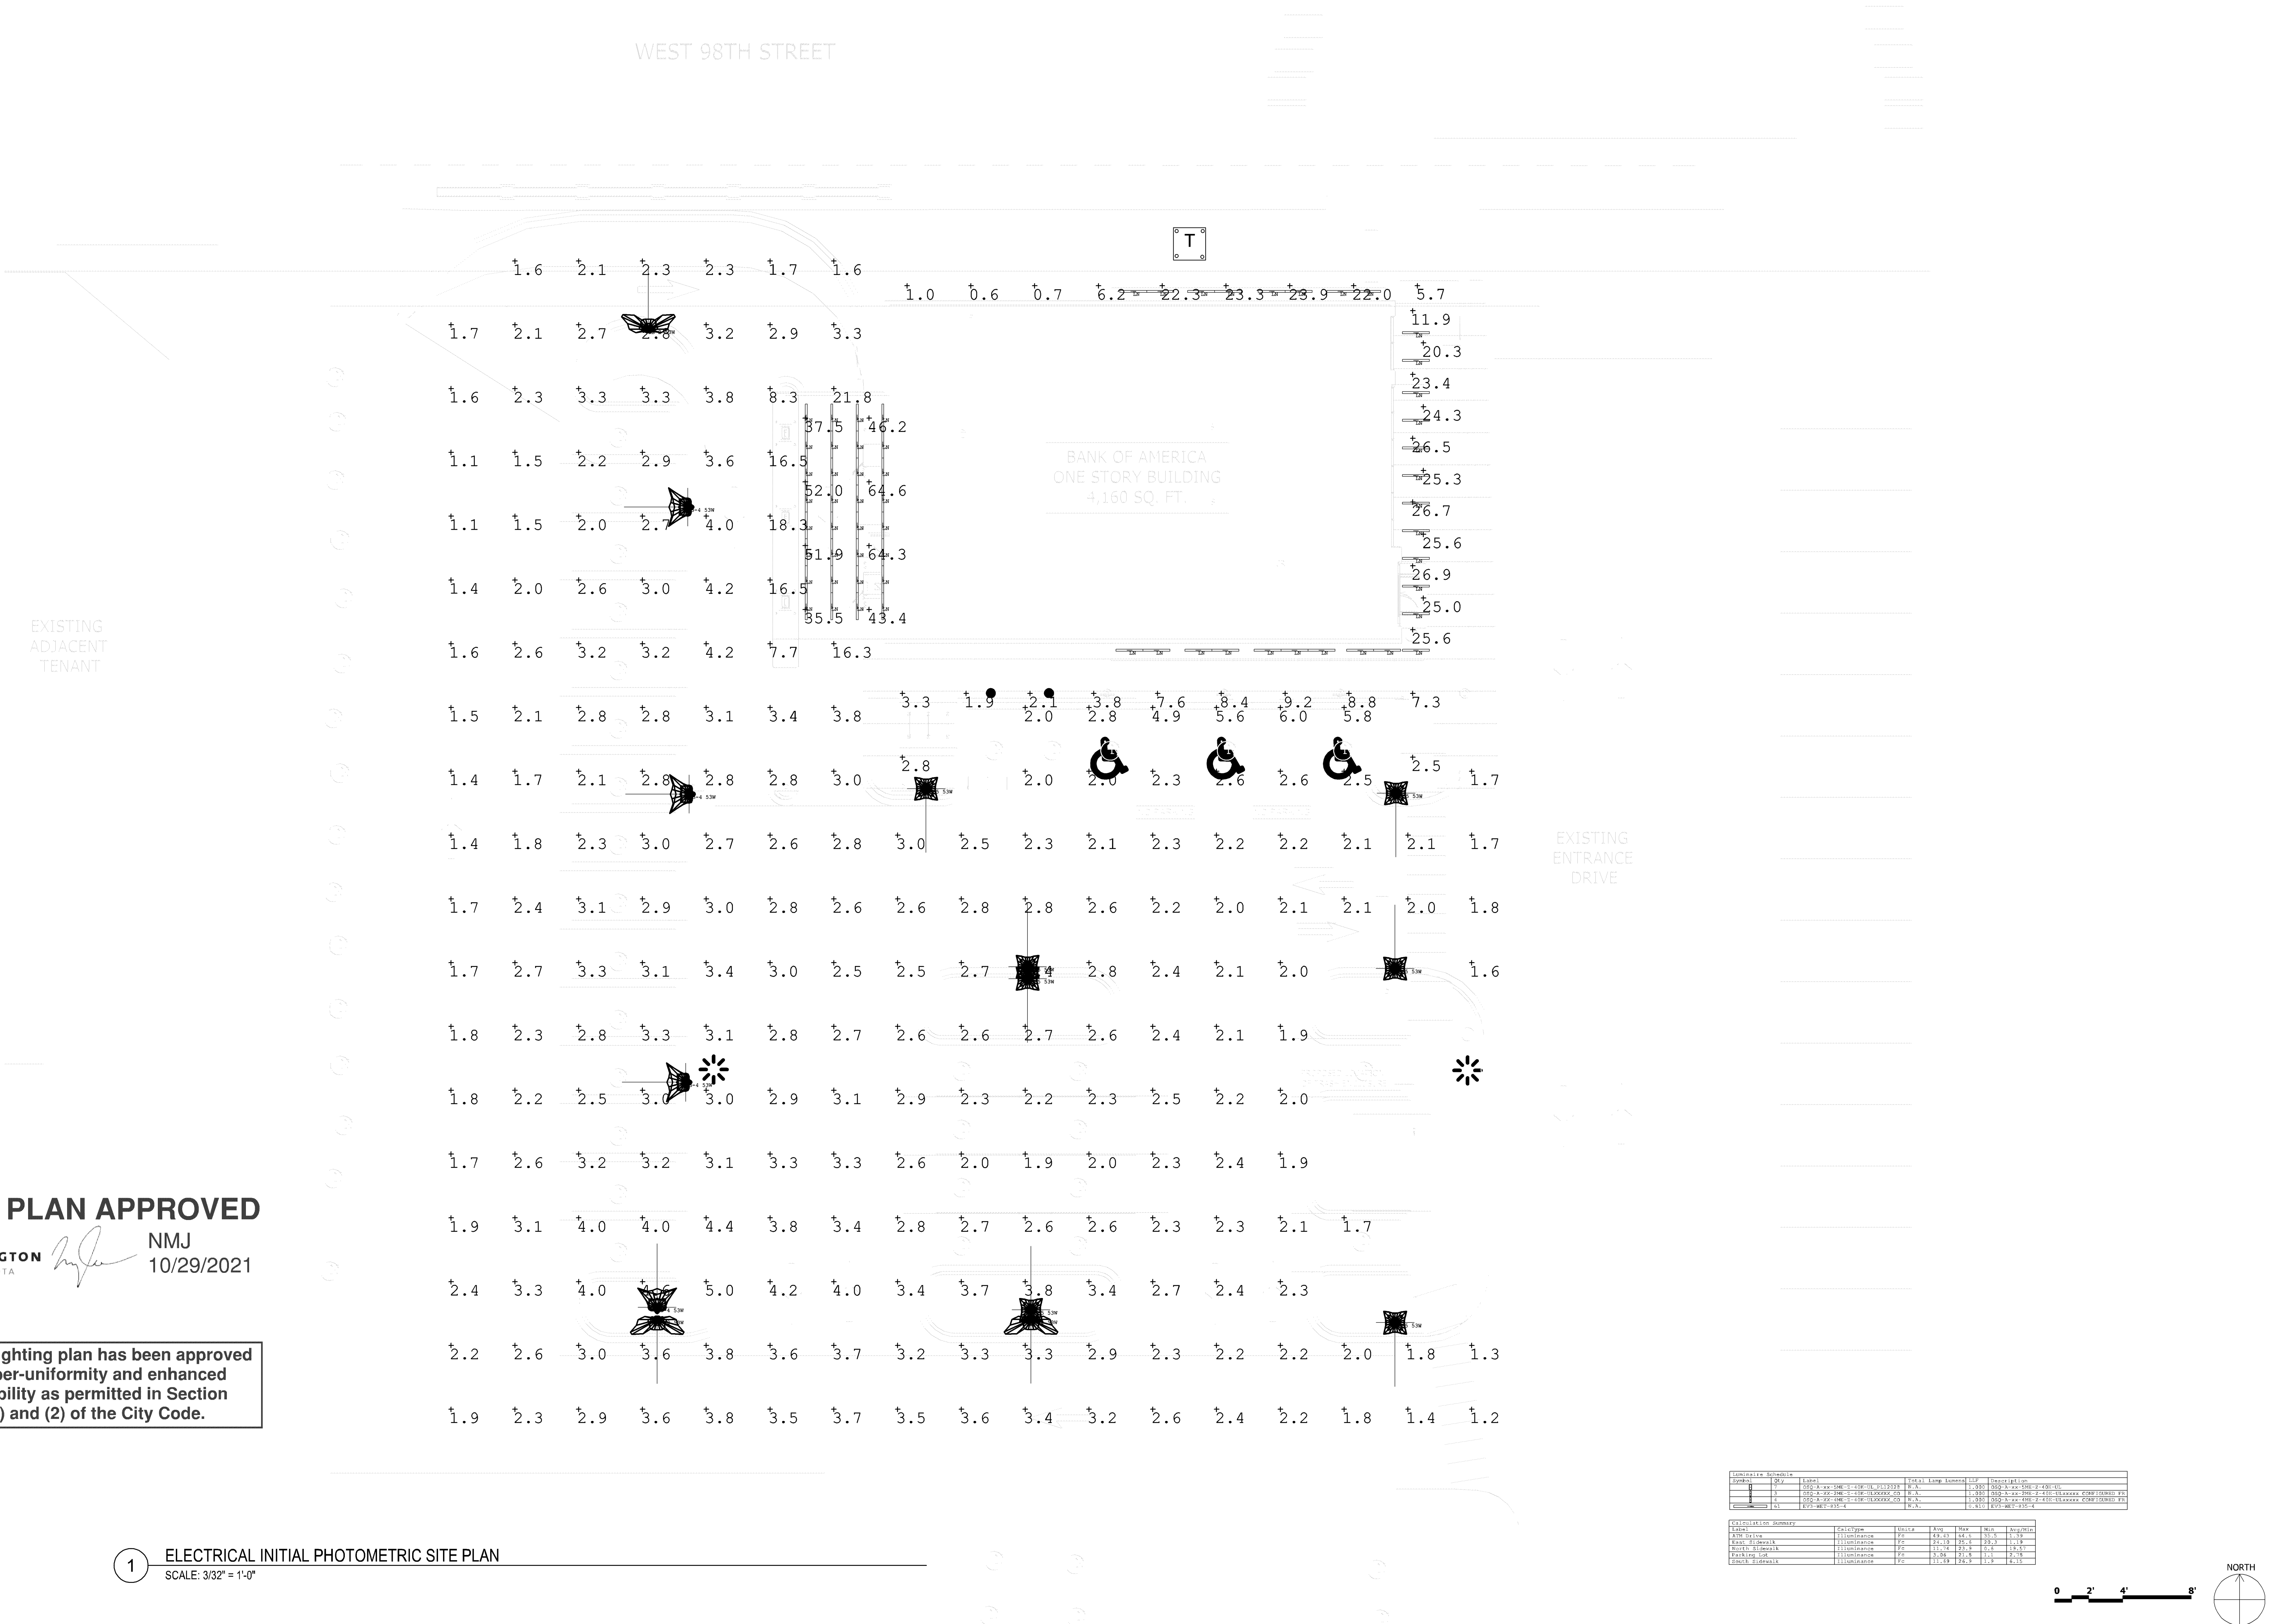

SHEET NOTES

1. THIS LIGHTING PLAN ILLUSTRATES ILLUMINATION LEVELS CALCULATED FROM LABORATORY DATA UNDER CONTROLLED CONDITIONS IN ACCORDANCE WITH ILLUMINATING ENGINEERING SOCIETY OF NORTH AMERICA (IESNA) APPROVED METHODS. ACTUAL SITE ILLUMINATION LEVELS AND PERFORMANCE OF LUMINAIRES MAY VARY DUE TO VARIATIONS IN WEATHER, ELECTRICAL VOLTAGE, TOLERANCES IN LAMPS AND OTHER RELATED VARIABLE FIELD CONDITIONS.
2. PROPOSED LIGHTING SOLUTION SUBJECT TO TENANT / LANDLORD AGREEMENT.
3. NOTE: MUNICIPAL STREET LIGHTING HAS NOT BEEN INCLUDED IN THIS STUDY. AMBIENT LIGHT LEVELS MAY VARY FROM THE MODELED LIGHT LEVELS.

CASE #PL2020-14

NELSON
Nelson Architecture & Interiors, Inc.

6000 Lombardo Center Suite #500
Cleveland, OH 44131
Phone: (216) 781-9144

Client Representative:
Roiann Hepburn
Tel: 312.805.0199
Email: Hepburn@am.jll.com

Architect:
Nelson Architecture & Interiors, Inc.
Project Manager: Brandon Garnett
T: 312.578.5313
E: bgarnett@nelsonww.com
Architect: Andrew Wehler
T: 216.830.1554
E: awehler@nelsonww.com

Civil:
Civil Site Group
Attn: David Knaeble
T: 312.588.3562
E: dknaeble@civilsitegroup.com

Structural:
KPFF
Attn: Andrew Cott, PE
T: 212.401.6344
E: andrew.cott@kpff.com

MEP:
Syska Hennessy Group
Attn: Matthew Cassidy
T: 312.588.3562
E: mcassidy@syska.com

Description:	No:	Date:
Issued for Coordination	09/04/2020	
Issued for Coordination	09/11/2020	
Issued for LL Review	09/17/2020	
Issued for Permit and Pricing	10/22/2020	
Issued for Construction	1 06/24/2021	
CD Record Drawings	2 06/25/2021	
Issued For Exterior Lighting	10/28/2021	

BANK OF AMERICA
Oxboro

611 West 98th Street
Bloomington, Minnesota 55420

PROPERTY ID: MN2-529
NSRP VERSION: 2.0
BULLETIN: 2-2020

**ELECTRICAL MAINTAINED
PHOTOMETRIC SITE PLAN**

PROFESSIONAL ENGINEER
I hereby certify that this plan, specification, or report was prepared by me or under my direct supervision and that I am a duly Licensed Professional Engineer under the laws of the State of Minnesota

Print Name: Joseph J. Romano

Signature: *Joseph J. Romano*
Date: 10/28/2021 License #: 56495

Project No: NCHZ0040
Drawn By: Reviewed By:
Project Manager: Approved By:

E04.04

LIGHTING PLAN APPROVED



NMJ
10/29/2021

The subject lighting plan has been approved with both super-uniformity and enhanced security flexibility as permitted in Section 21.301.07(j)(1) and (2) of the City Code.

1 ELECTRICAL MAINTAINED PHOTOMETRIC SITE PLAN
SCALE: 3/32" = 1'-0"

