



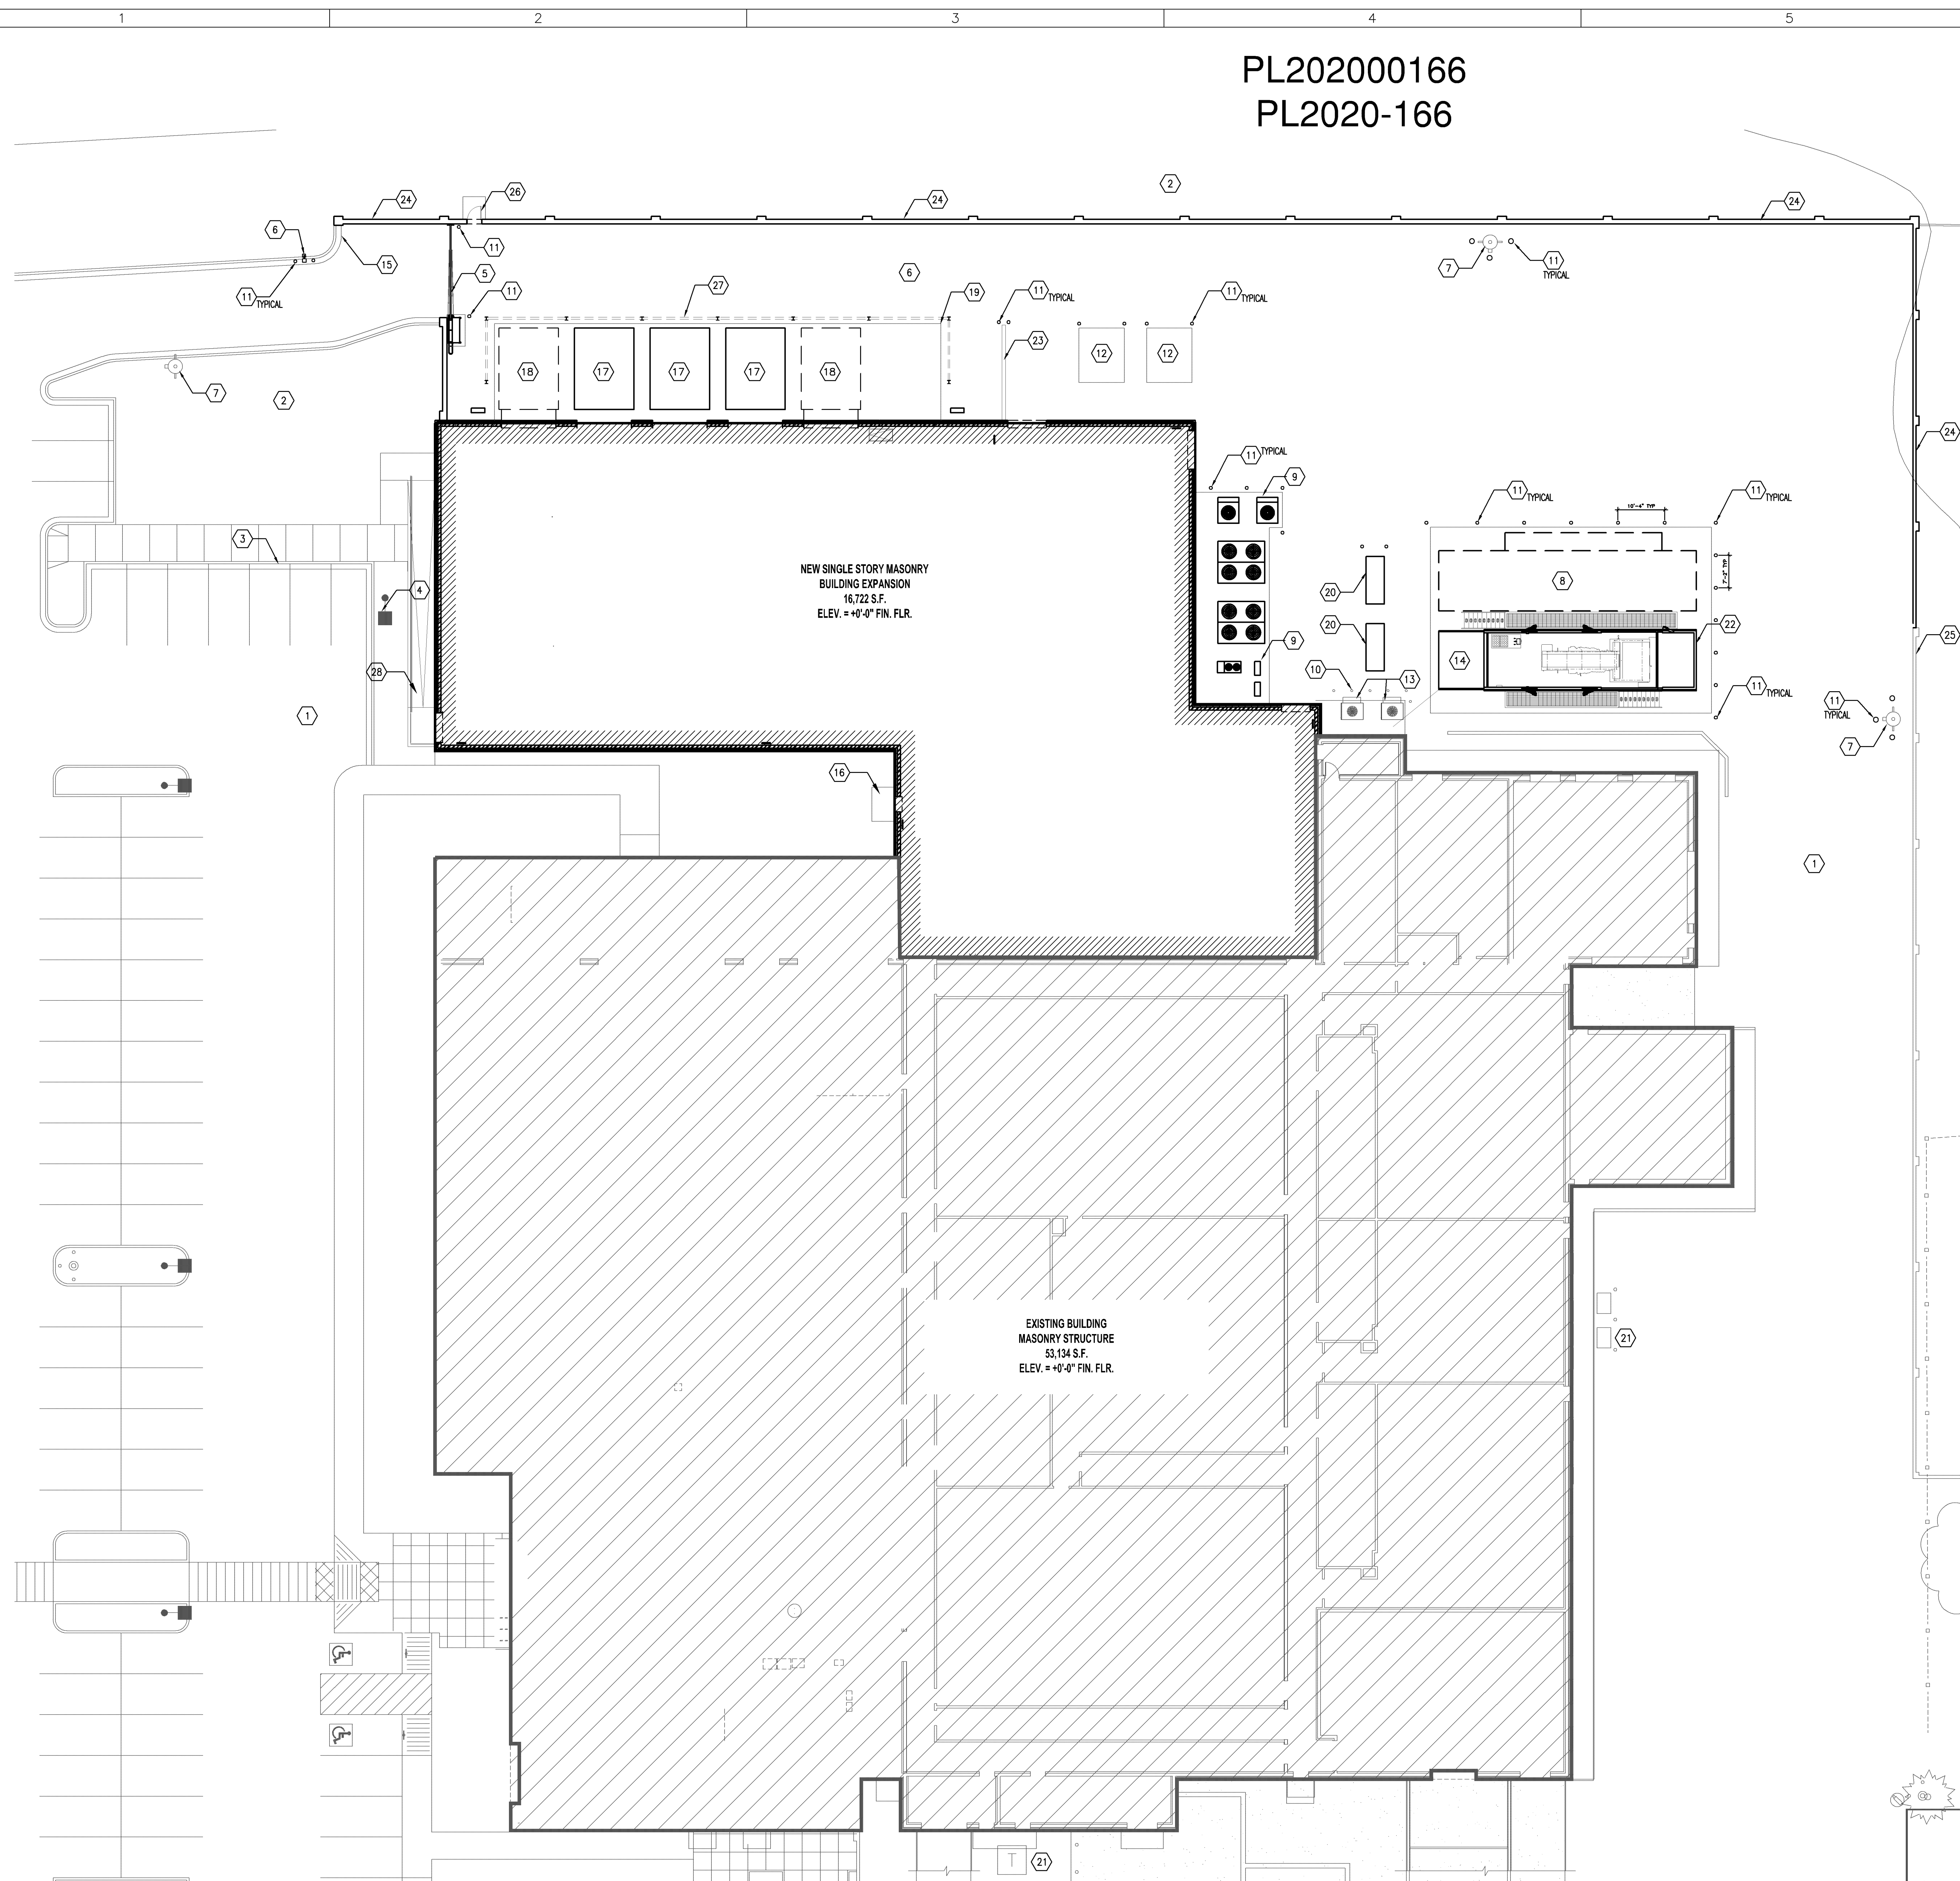


1 ARCHITECTURAL ENLARGE SITE PLAN
A101 SCALE: 1/16" = 1'-0"

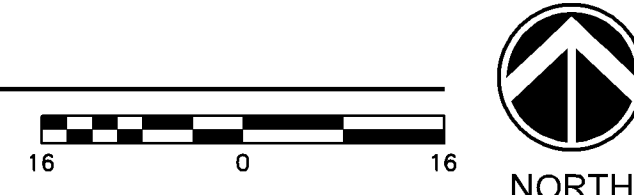

KEY NOTES

- 1 EXISTING ASPHALT PAVING.
- 2 EXISTING GRASS AREA.
- 3 EXISTING CURB.
- 4 EXISTING LIGHT POLE.
- 5 VERTICAL PIVOT GATE, HARDWARE AND OPERATOR.
- 6 CARD READER AND PEDESTAL. REFER TO ELECTRICAL DRAWINGS FOR ADDITIONAL DETAILS.
- 7 NEW FIRE HYDRANT. - SEE CIVIL DRAWINGS
- 8 NEW ADD ALTERNATE GENERATOR ENCLOSURE AND BELLY TANK.
- 9 NEW CONDENSING UNITS ON CONCRETE PAD. - REFER TO MECHANICAL & STRUCTURAL DRAWINGS FOR DETAILS.
- 10 EXISTING BOLLARD.
- 11 NEW 6" DIA. BOLLARD, TYP.
- 12 NEW UTILITY TRANSFORMER-REFER TO ELECTRICAL DRAWINGS.
- 13 EXISTING CONDENSER UNIT
- 14 NEW BACK-UP GENERATOR ENCLOSURE WITH BELLY TANK.
- 15 NEW CONCRETE CURB. - REFER TO CIVIL DRAWINGS FOR DETAILS.
- 16 NEW CONCRETE PAD AT DOOR. - REFER TO CIVIL DRAWINGS FOR DETAILS.
- 17 DRY ONE HVAC UNIT- REFER TO MECHANICAL DRAWINGS.
- 18 ADD ALTERNATE HVAC UNIT- REFER TO MECHANICAL DRAWINGS
- 19 NEW CONCRETE PAD FOR AHU'S- REFER TO STRUCTURAL DRAWINGS. TOP OF PAD 832'.
- 20 NEW TYP GEN TAP BOOMS- REFER TO ELECTRICAL DRAWINGS FOR ADD. INFORMATION
- 21 EXISTING UTILITY TRANSFORMER
- 22 FUEL FILL PORTS MOUNTED AT NEW GEN PAD AND BELLY TANKS.
- 23 CONCRETE RETAINING WALL, SEE DETAIL 8/SS11
- 24 NEW CMU SCREENWALL
- 25 EXISTING CMU SCREENWALL
- 26 NEW HW DOOR
- 27 SOUND CONTROL BARRIER - SEE DETAIL 8/A212 AND SPECIFICATION 323516
- 28 NEW RAMP - SEE DETAILS 4213


LEGEND

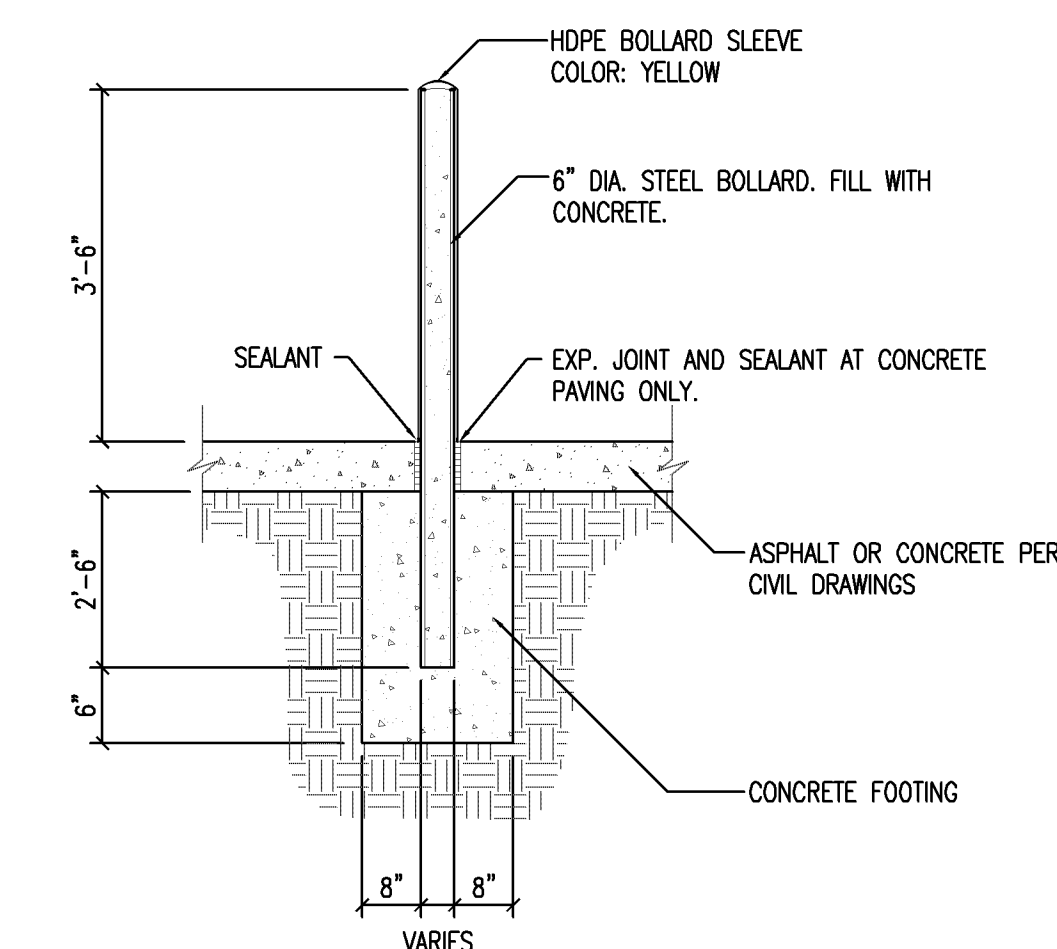

2 BOLLARD DETAIL
A101 SCALE: 1/2" = 1'-0"

I hereby certify that this plan, specifications, or report was prepared by me or under my direct supervision and that I am a duly licensed Architect under the laws of the state of Minnesota.

Signature: 2021.10.28 17:56:31 -0400
Typed or Printed Name: Robert Jerry Lara
Date: 10/28/2021 License Number: 59397

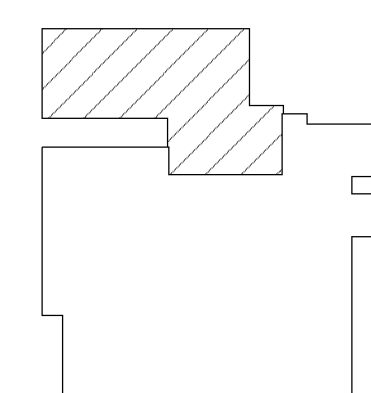

KEY PLAN



This drawing was prepared solely for the use of Verizon Wireless and must only be used by Verizon Wireless employees, contractors, and vendors while performing the work shown on this drawing. Any other use of this drawing is forbidden.



1455 LINCOLN PARKWAY, SUITE 500
ATLANTA, GA 30346
TEL:770.379.8500 FAX:770.379.8501
WWW.MORRISONHERSHFIELD.COM

Do not scale drawings. Contractor must verify all dimensions and advise Consultants of any errors or omissions. No variations or modifications to work shown shall be implemented without prior written approval. All previous issues of this drawing are superseded by the latest revision. All drawings and specifications remain the property of Morrison Hershfield Corporation.

SUBCONSULTANT

verizon[✓]
BLOOMINGTON MSC EXPANSION
10801 BUSH LAKE ROAD
BLOOMINGTON, MN.

[illegible]

PROJECT NO:	200174800	STAMP
CAD DWG FILE:	A101	
DESIGNED BY:	JP	
DRAWN BY:	KNC	
CHECKED BY:	KM	
COPYRIGHT:	MAY 2020	
		2021.10.28 17:56:27-0400

SHEET TITLE

ARCHITECTURAL ENLARGED
SITE PLAN

SHEET NUMBER **A101**