



Schedule									
Symbol	Label	QTY	Manufacturer	Catalog	Description	Number Lamps	Lamp Output	LLF	Input Power
□	AA1	12	BEGA North America	99596	Roadway luminaire	1	9342.636	0.81	76.3
□	AA3	6	BEGA North America	99599	Roadway luminaire	1	13262.99	0.81	115.4
○	BB1	35	BEGA Converted by LUMCat V 18.04.2017 / M.S.		84063K3	1	1363.389	0.81	23
▮	WW1	4	BEGA-US	22 132	CAST ALUMINUM HOUSING, TRANSLUCENT WHITE GLASS ENCLOSURE WITH STAINLESS STEEL FACE PLATE	1	90.81557	0.81	11.5
—	Z6	4	Lithonia Lighting	WPX1 LED P2 40K Mvolt	WPX1 LED wallpack 3000lm 4000K color temperature 120-277 Volts	1	2912.045	0.81	24.42
—	LE1	218	Senso Lighting	455-405-F5-MO-35-XX-XX-1"	Trident IP	2	340.9987	0.81	3.751
○	LE2	6	3G LIGHTING- TORONTO, ONTARIO	3G-DL33RA-10-S80-35K-60D-SDP60	DOWNLIGHT (3.3 INCH ROUND ADJUSTABLE)	1	830	0.81	10.26
○	BB2	11	BEGA Converted by LUMCat V 17.07.2017 / H.R.		84063K3	2	1363.389	0.81	66

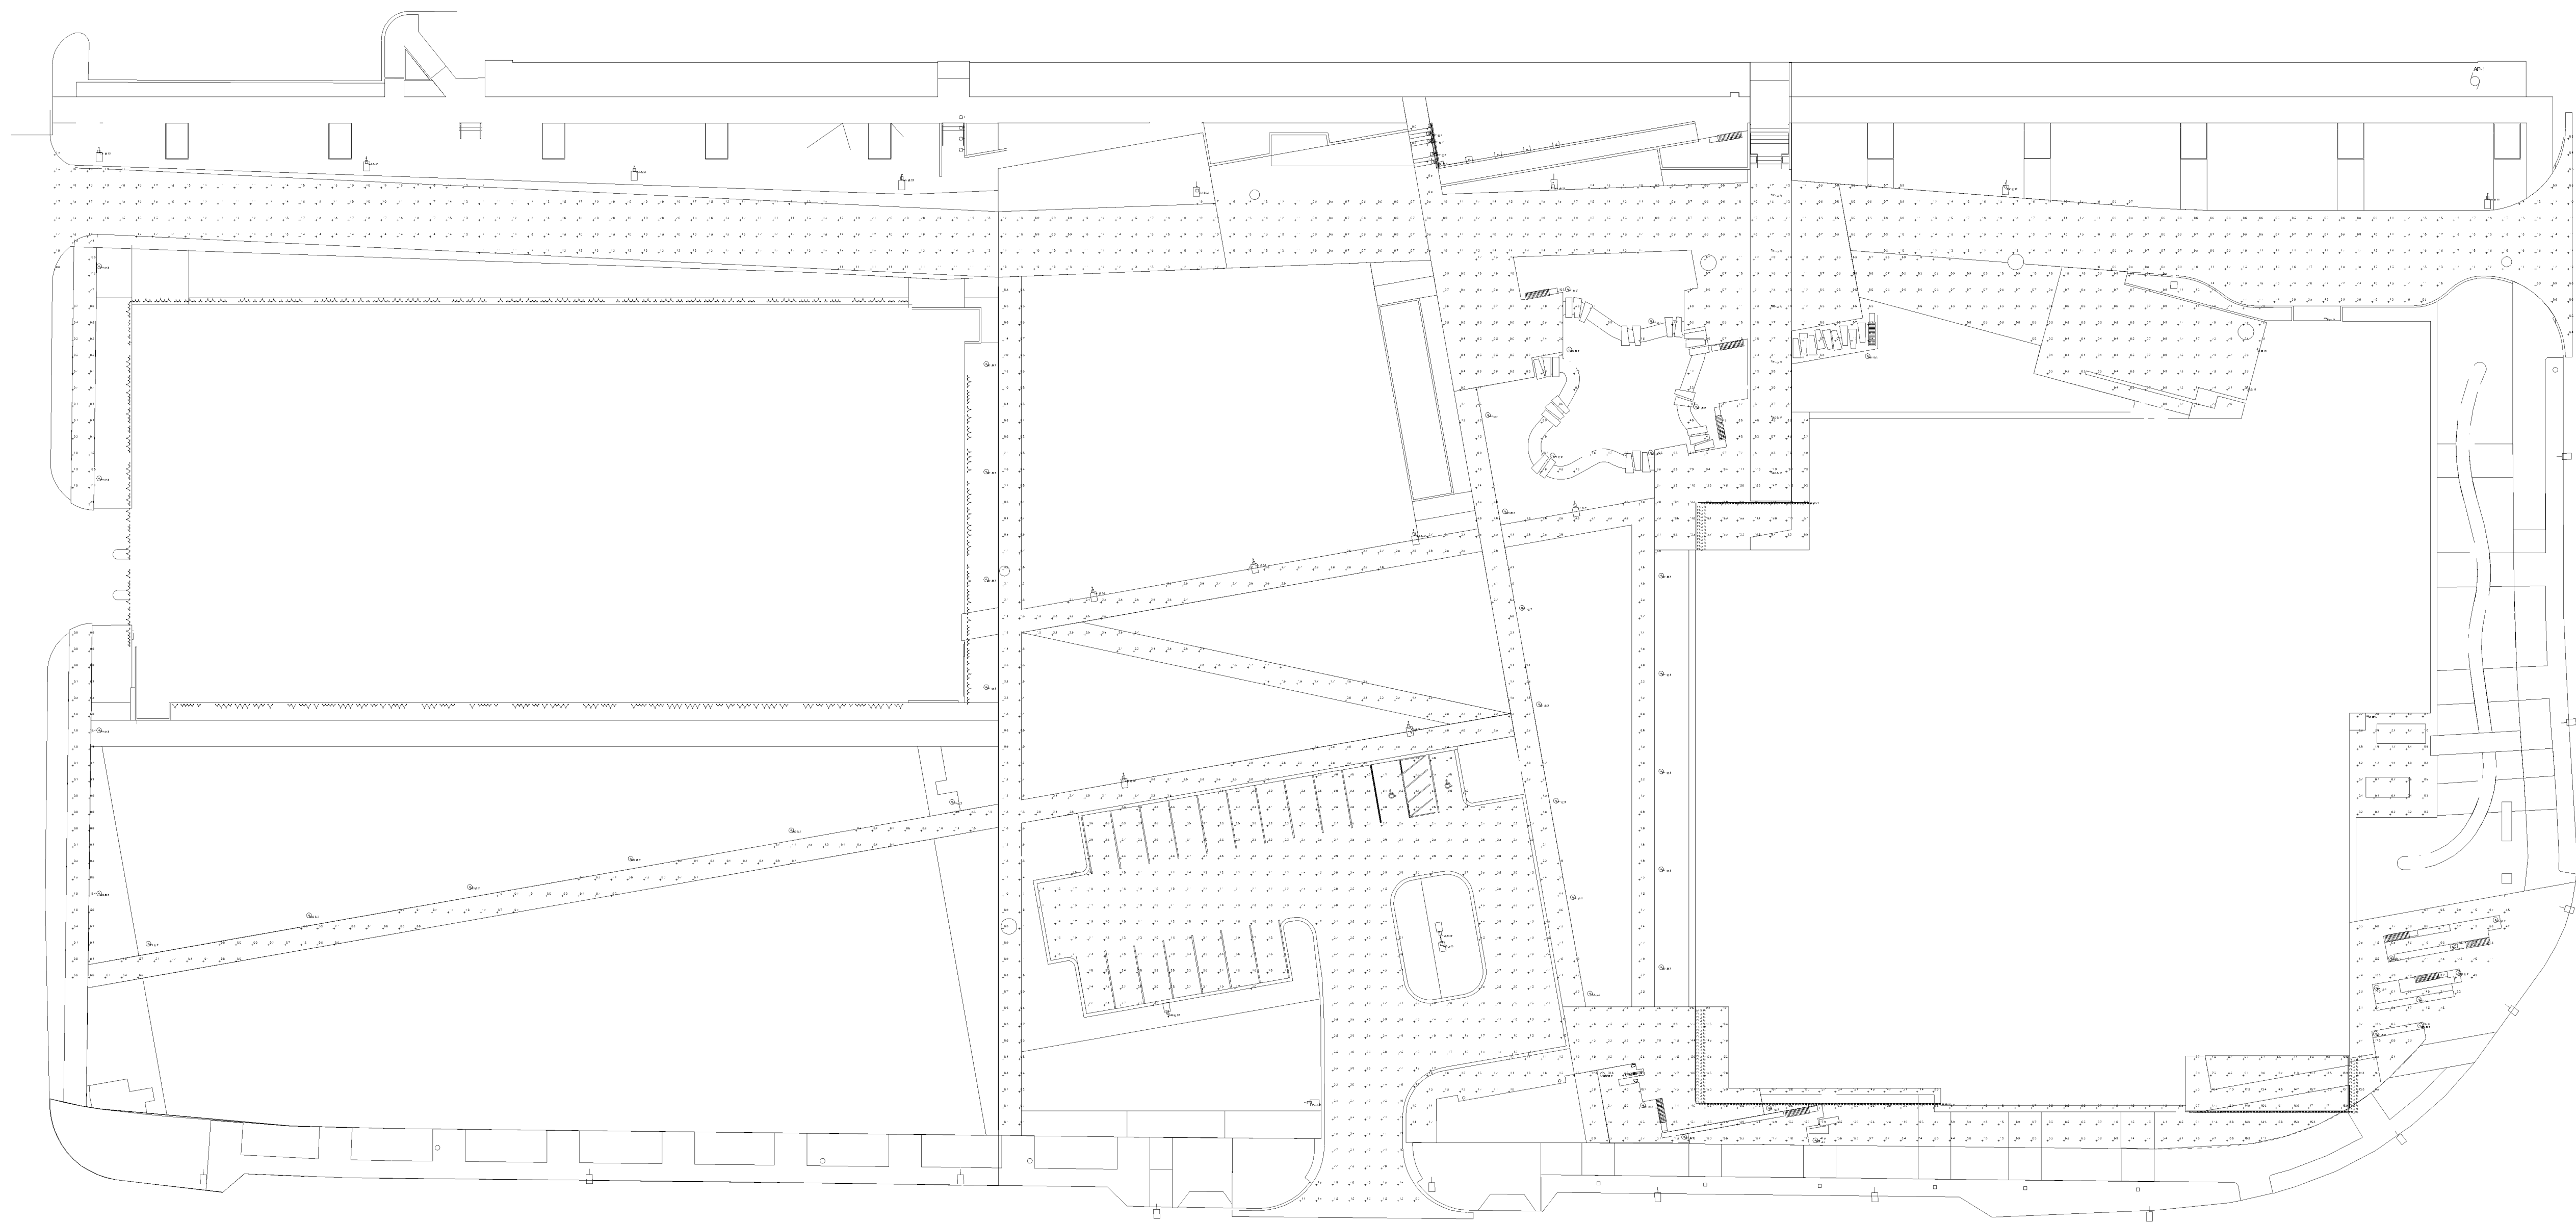

2 SITE PLAN - PHOTOMETRICS - MAINTAINED
SCALE: 1"=30'-0"

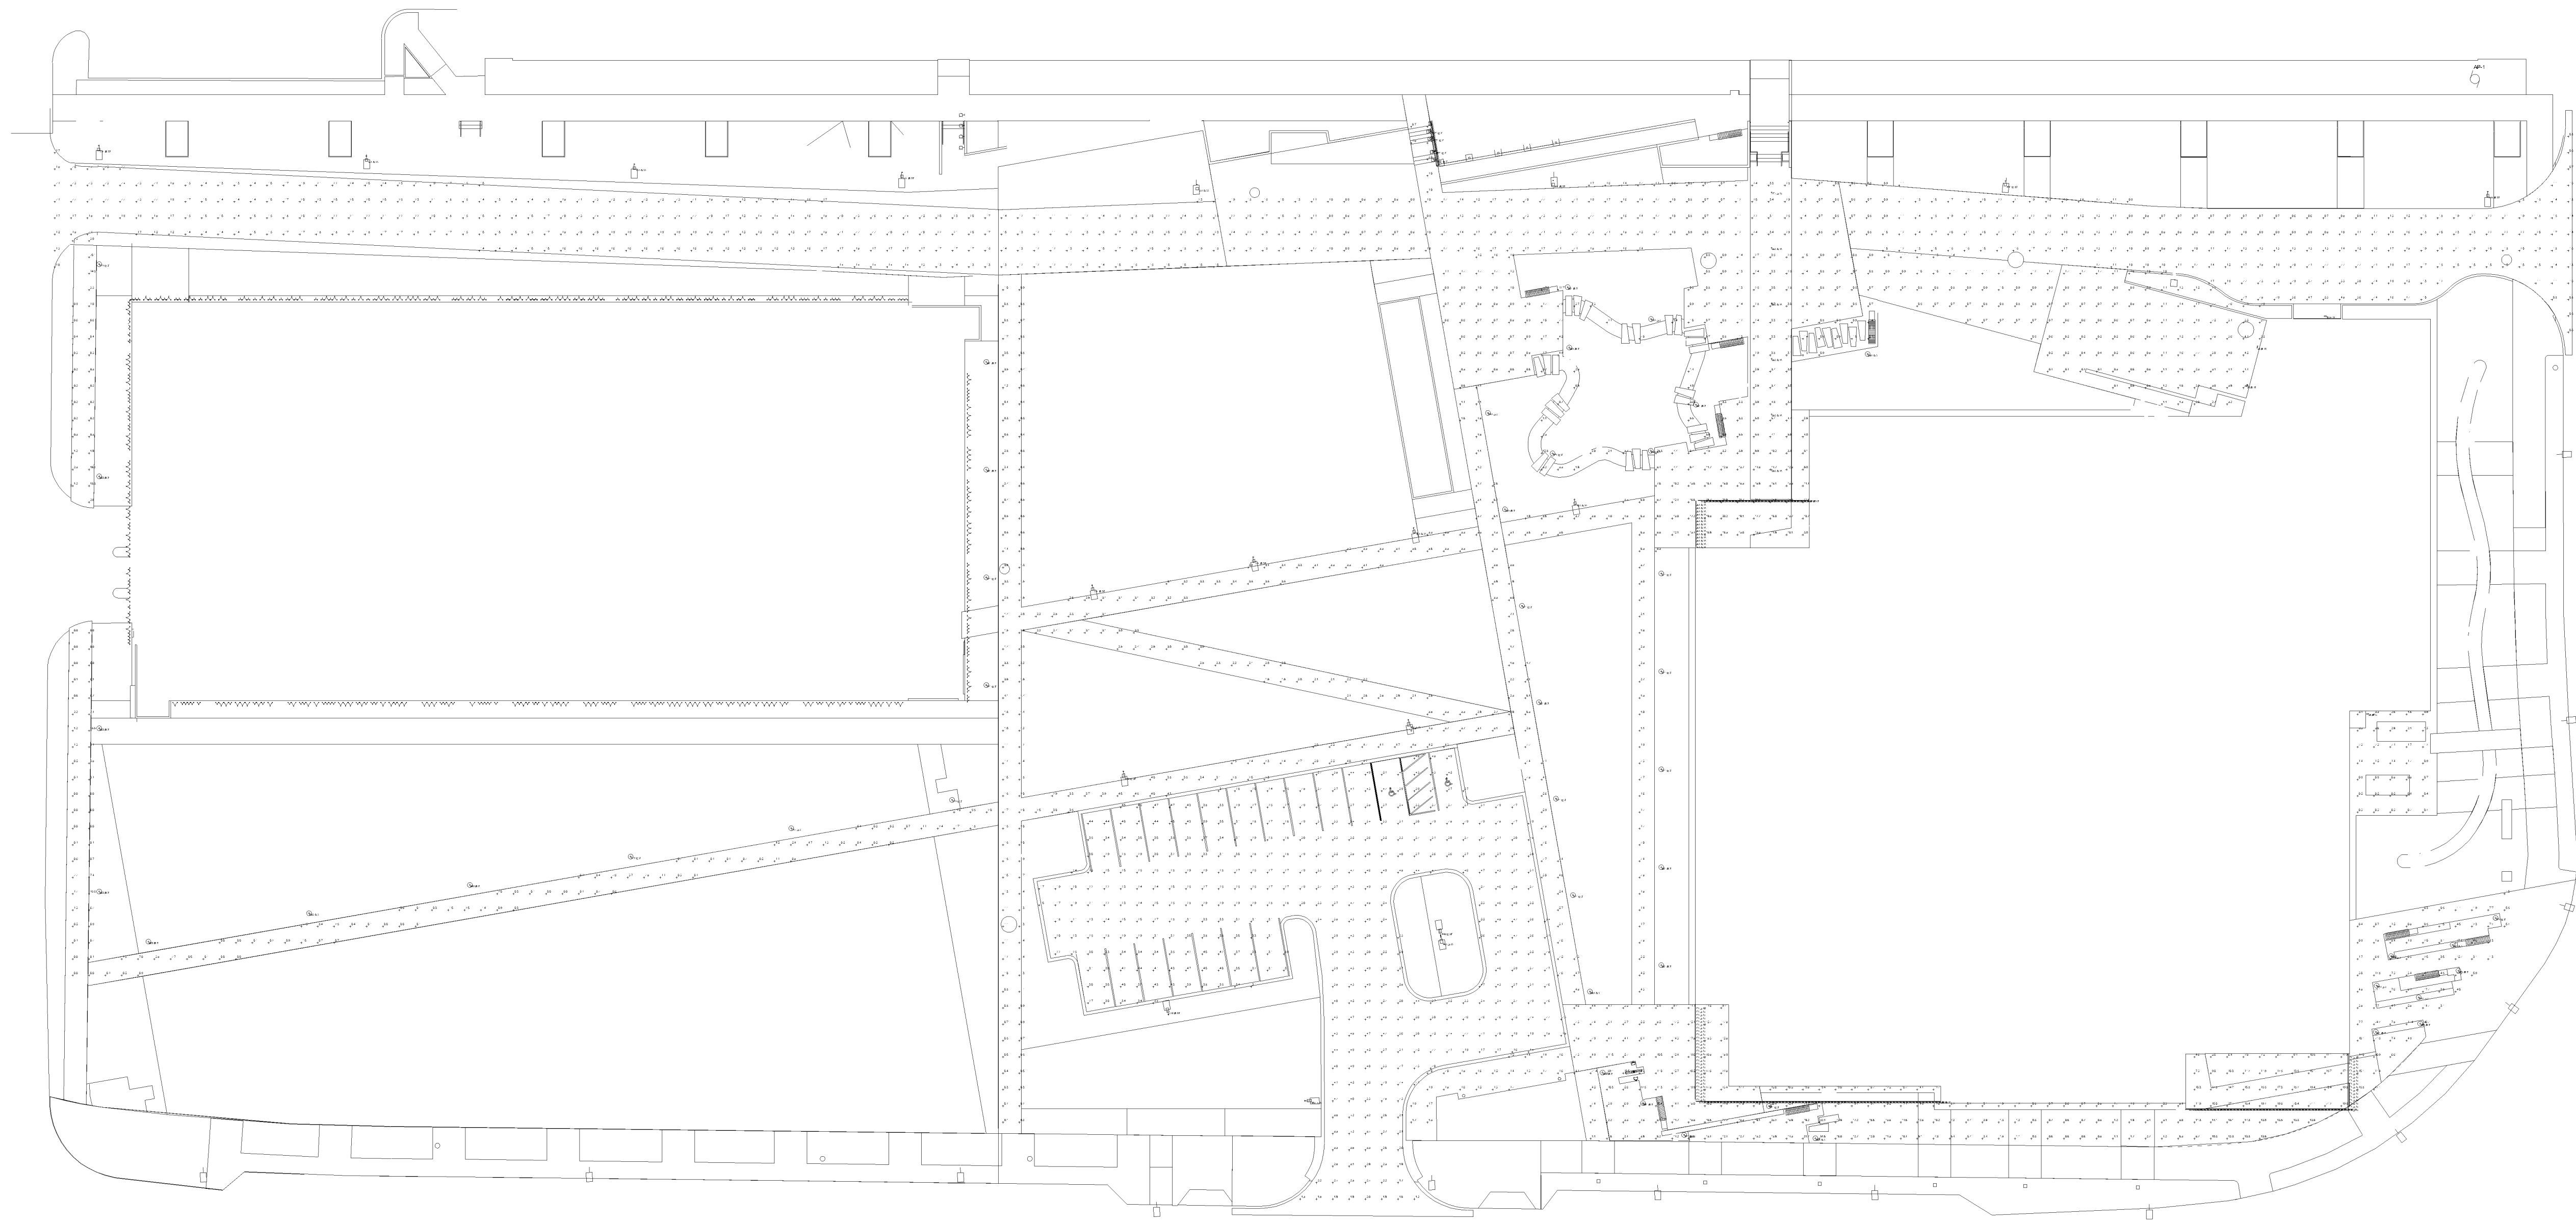

1 SITE PLAN - PHOTOMETRICS - INITIAL
SCALE: 1"=30'-0"

DRAWING ISSUES / REVISIONS		
NO.	DATE	DESCRIPTION

I hereby certify that this plan, specifications, or reports were prepared by me or under my direct supervision and that I am a duly licensed Professional Engineer under the laws of the State of Minnesota.

Signed: 

Name: Josh Ortmann

License No.: 57111

Date: 5/31/2024

phase	PERMIT SET
date	2.29.2024
checked by	Checker
drawn by	Author
project number	2022149
project name	


SICK
Minneapolis
Campus
Phase 2
Office/Resource
Center

PHOTOMETRICS PLAN


Sheet number
E0.01

Approved - Zoning Review
06/04/2024
M. Centinario


Schedule									
Symbol	Label	QTY	Manufacturer	Catalog	Description	Number Lamps	Lamp Output	LLF	Track Power
	AA1	16	Lithonia Lighting	D6X2 LED P3 40K 80CRI 14M	D-Series Size 2 Area Luminaire P3 Performance Package 4000K CCT 80 CRI Type 4 Medium	1	27399	0.81	219.4
	P1	39	BEACON PRODUCTS	SRT2-65-4K7-SQW	SRT2 65W SQW DISTRIBUTION 9171 lumens	1	9171	0.81	87.2
	V3	3	Nulite Lighting	RXT-P-D-PF-09-35-4	RXT 3600 lumens	1	3604	0.81	40.558
	V4	6	Nulite Lighting	RXT-R-D-PF-14L35-4	RXT 5700 lumens	1	5474	0.81	53.754

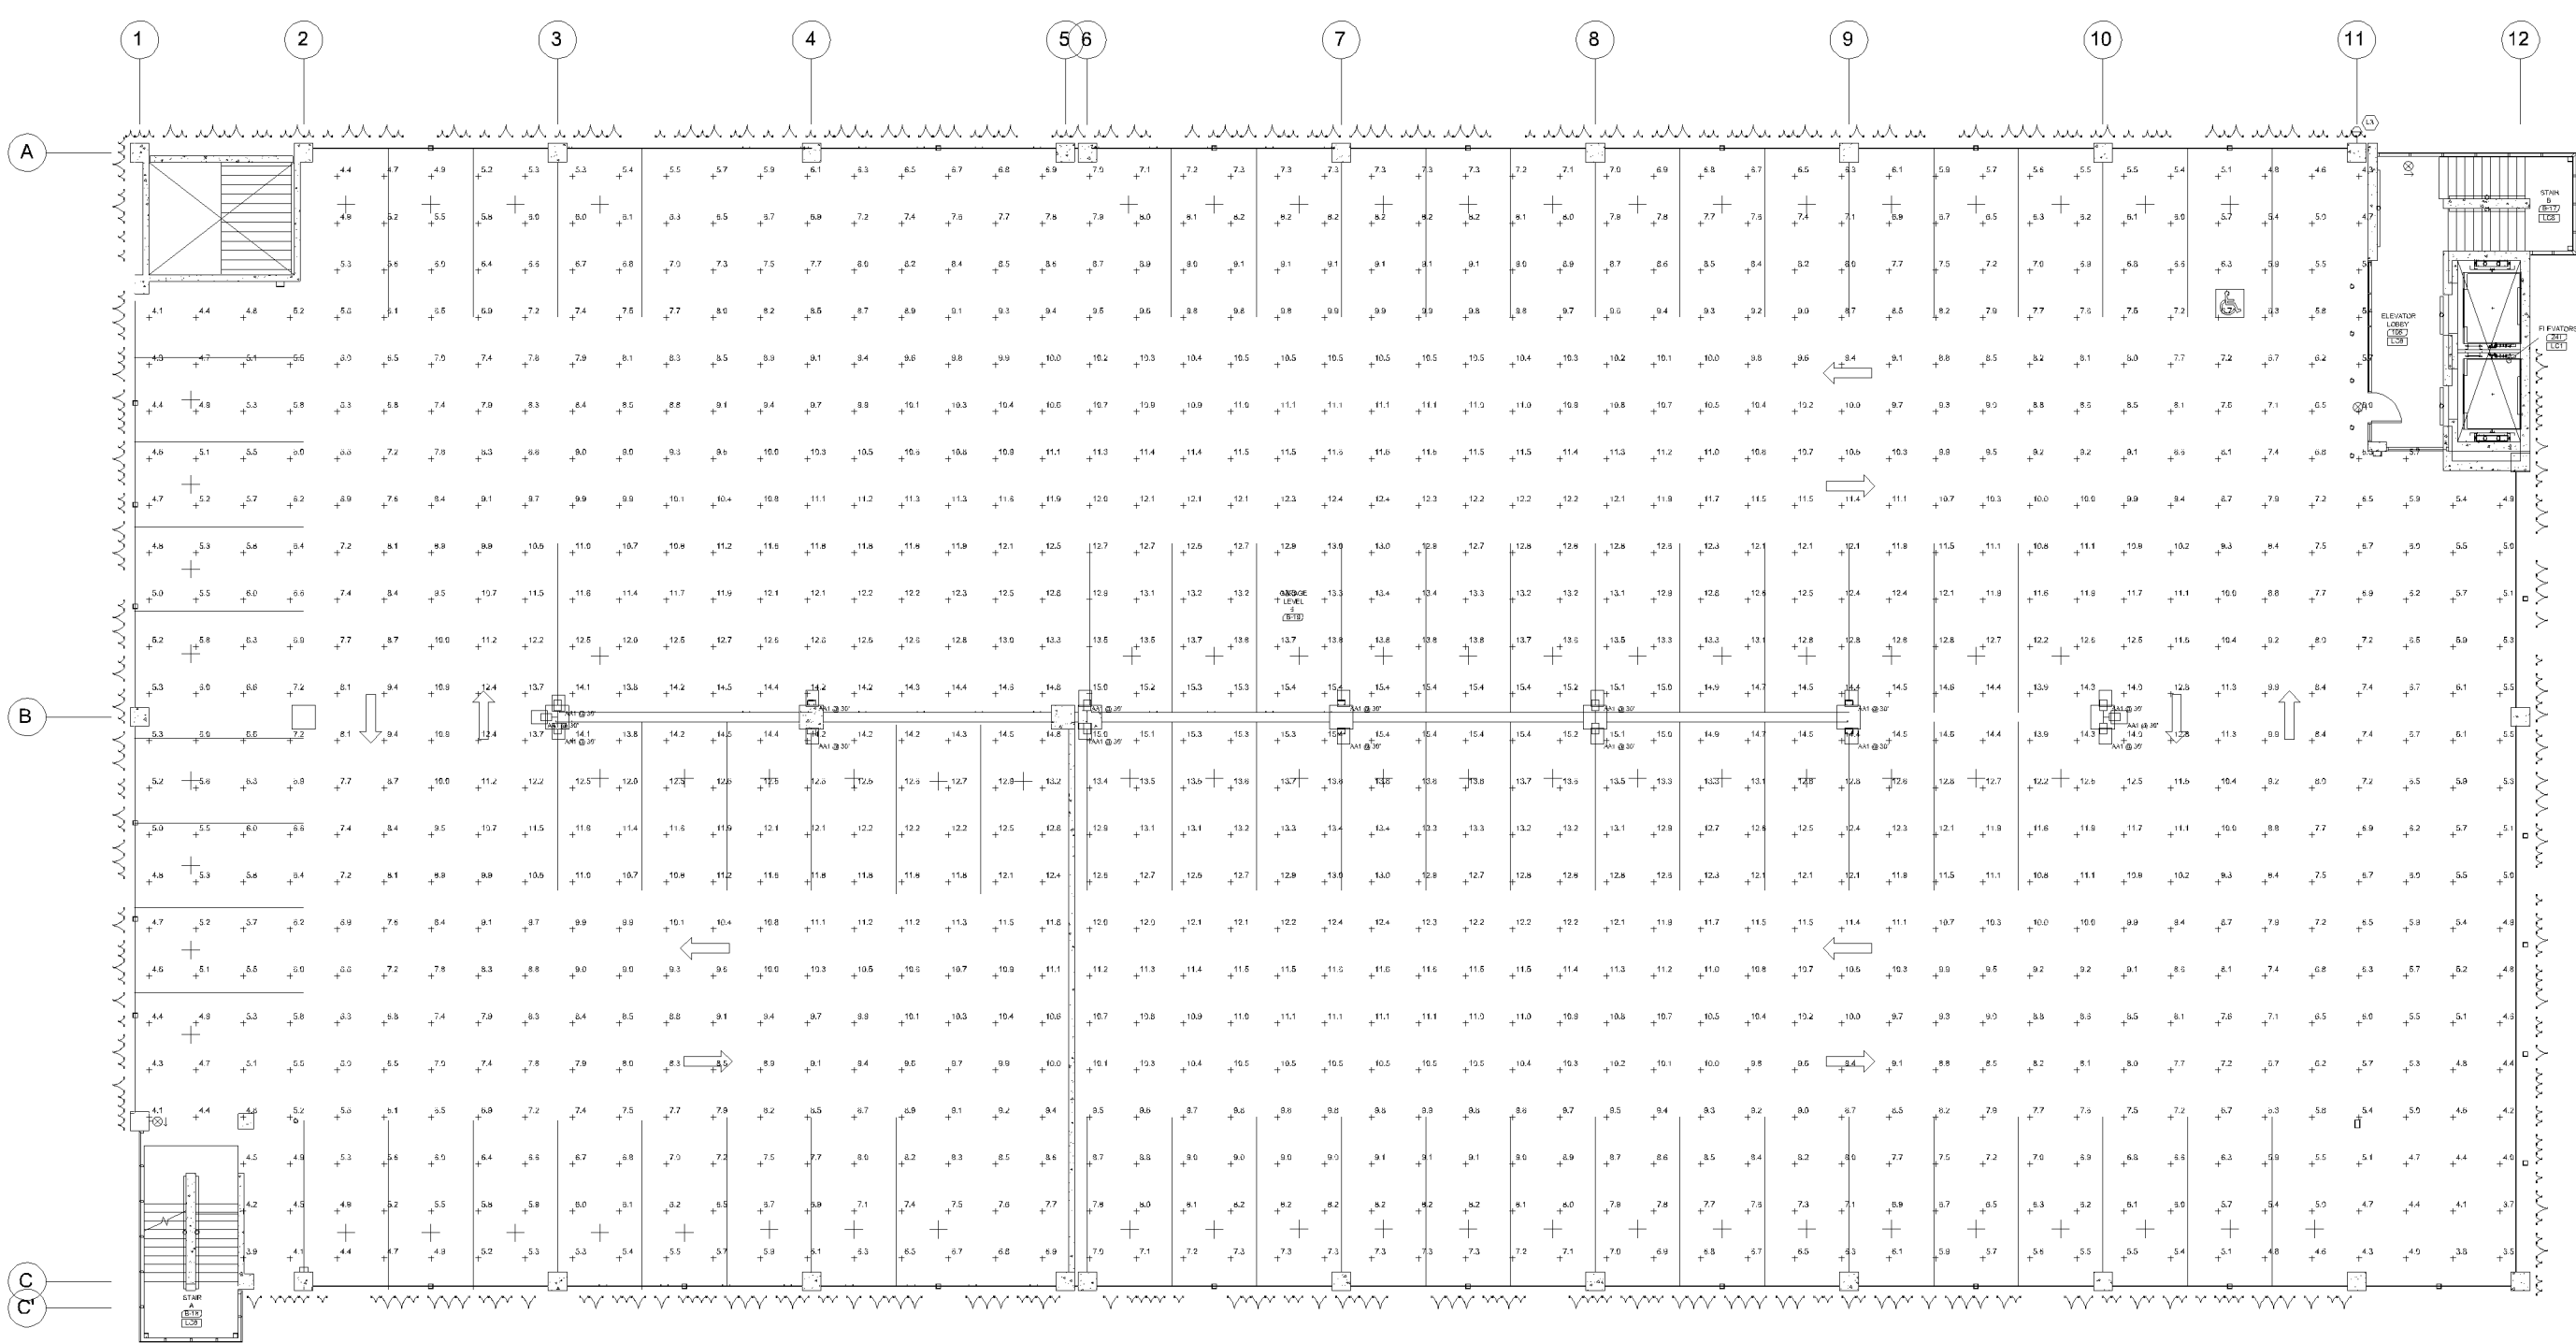


6 LEVEL 6 - PHOTOMETRICS - INITIAL
SCALE: 1" = 20'-0"

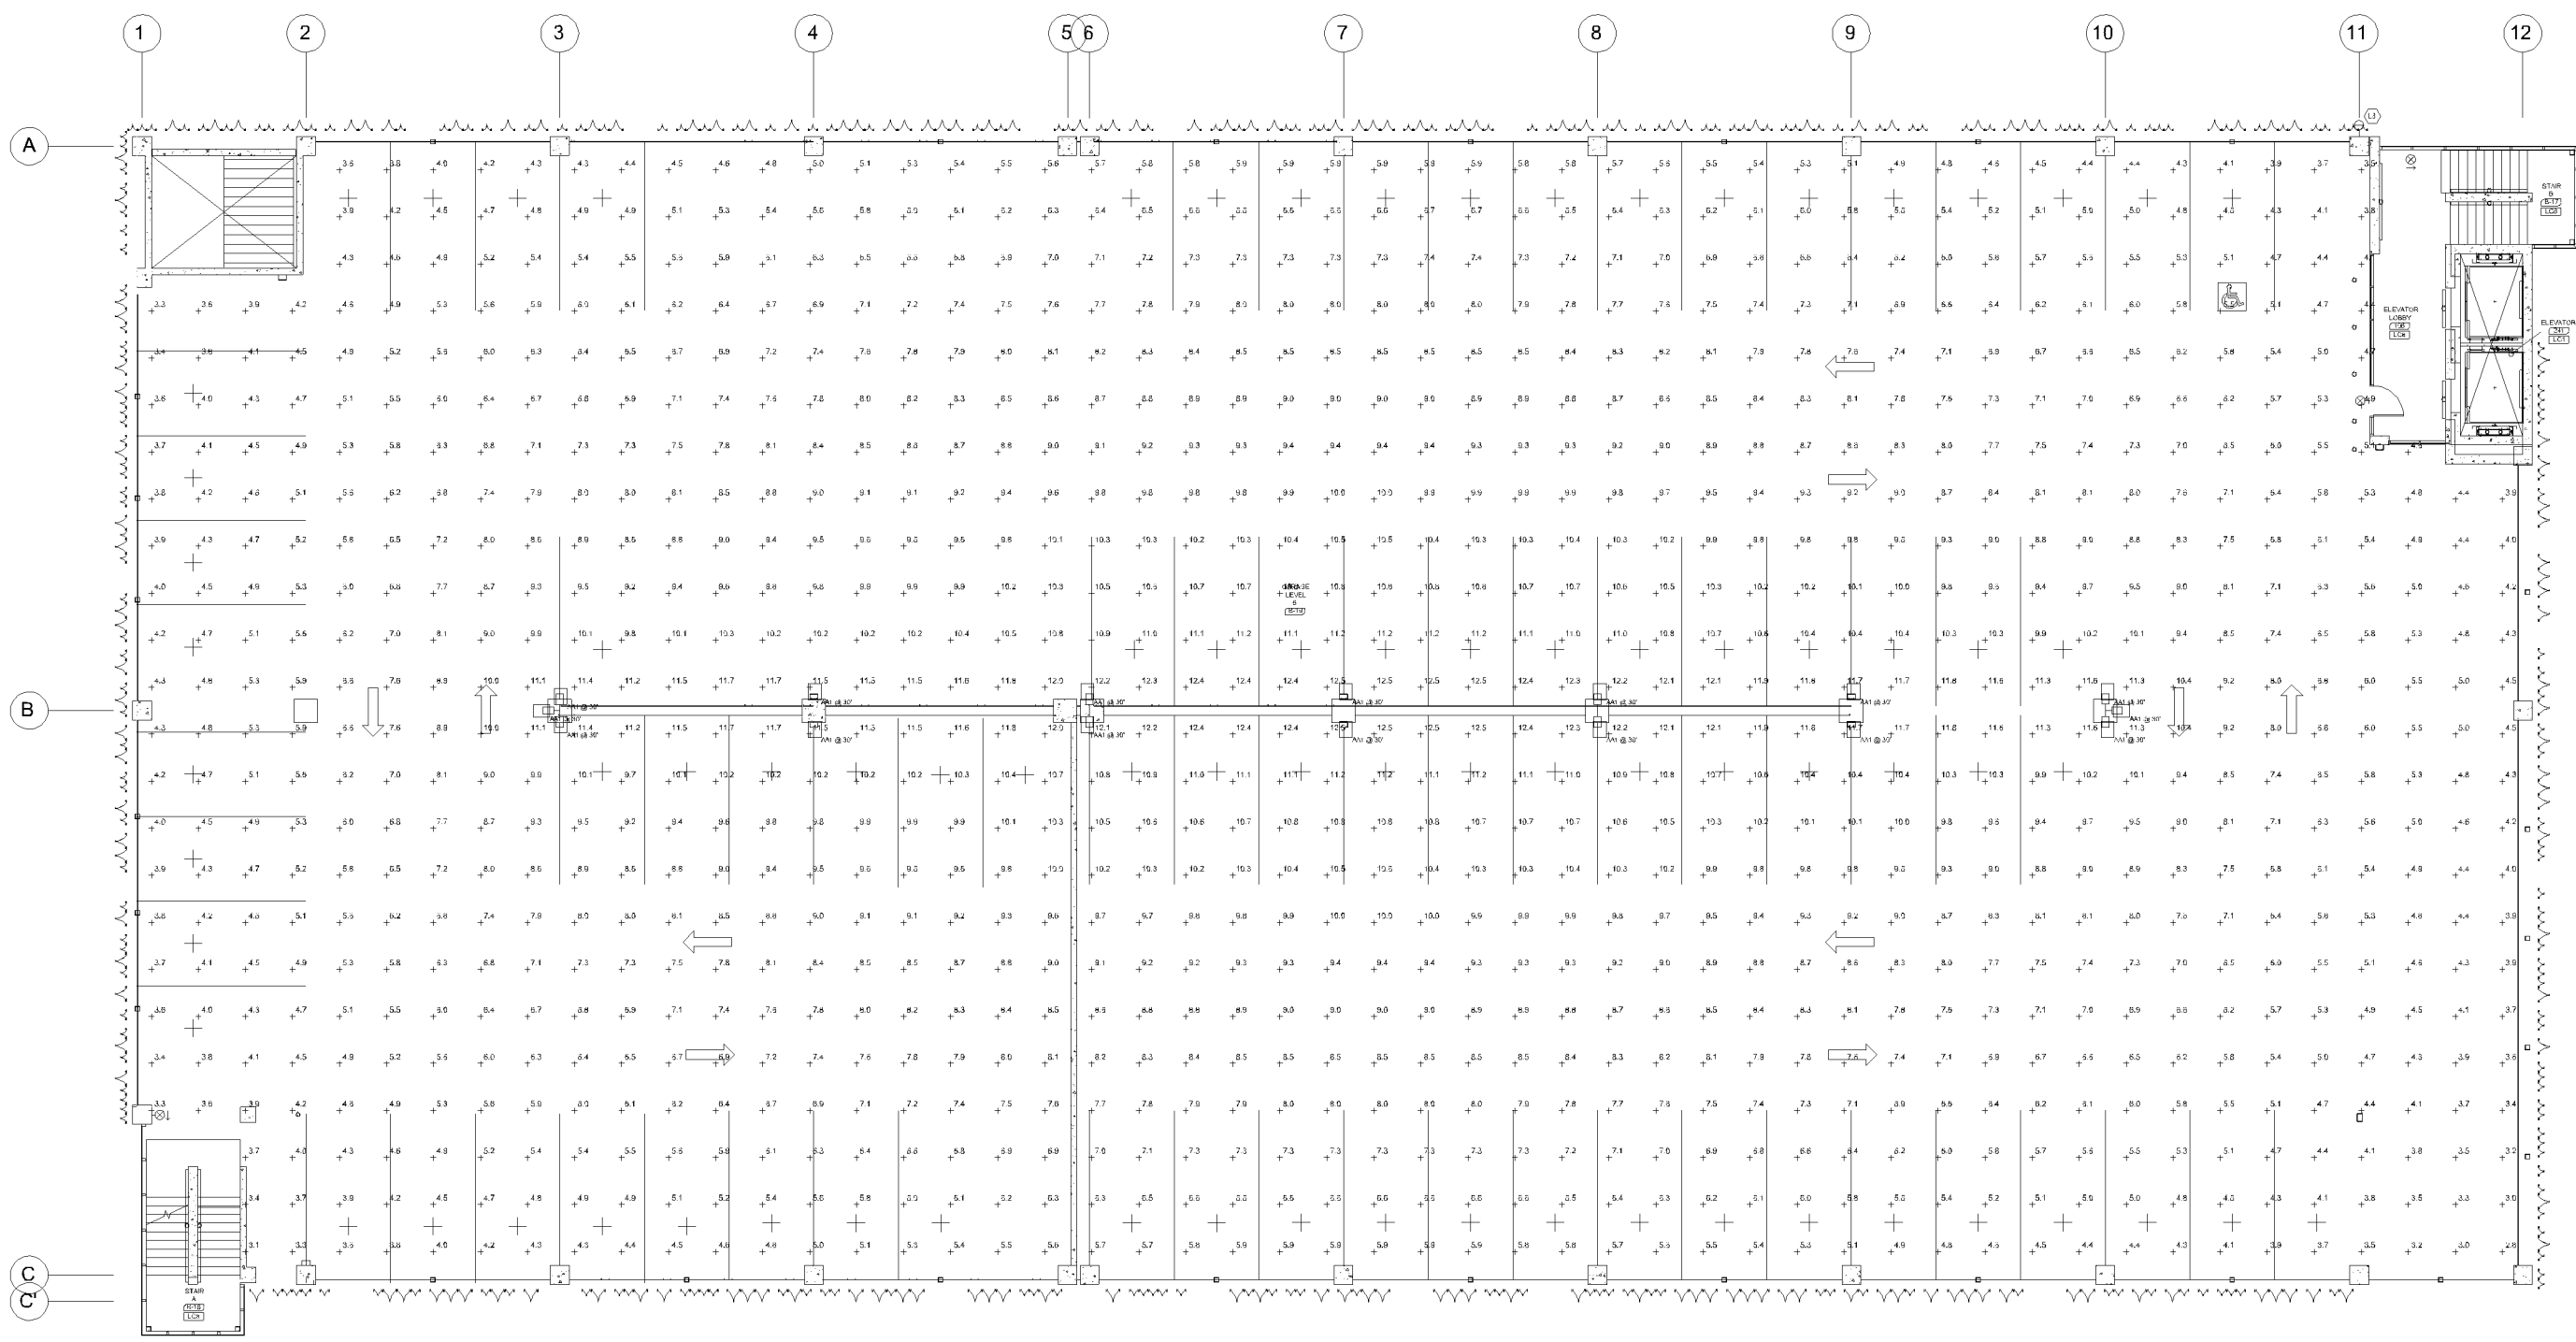


3 LEVEL 6 - PHOTOMETRICS - MAINTAINED
SCALE: NTS

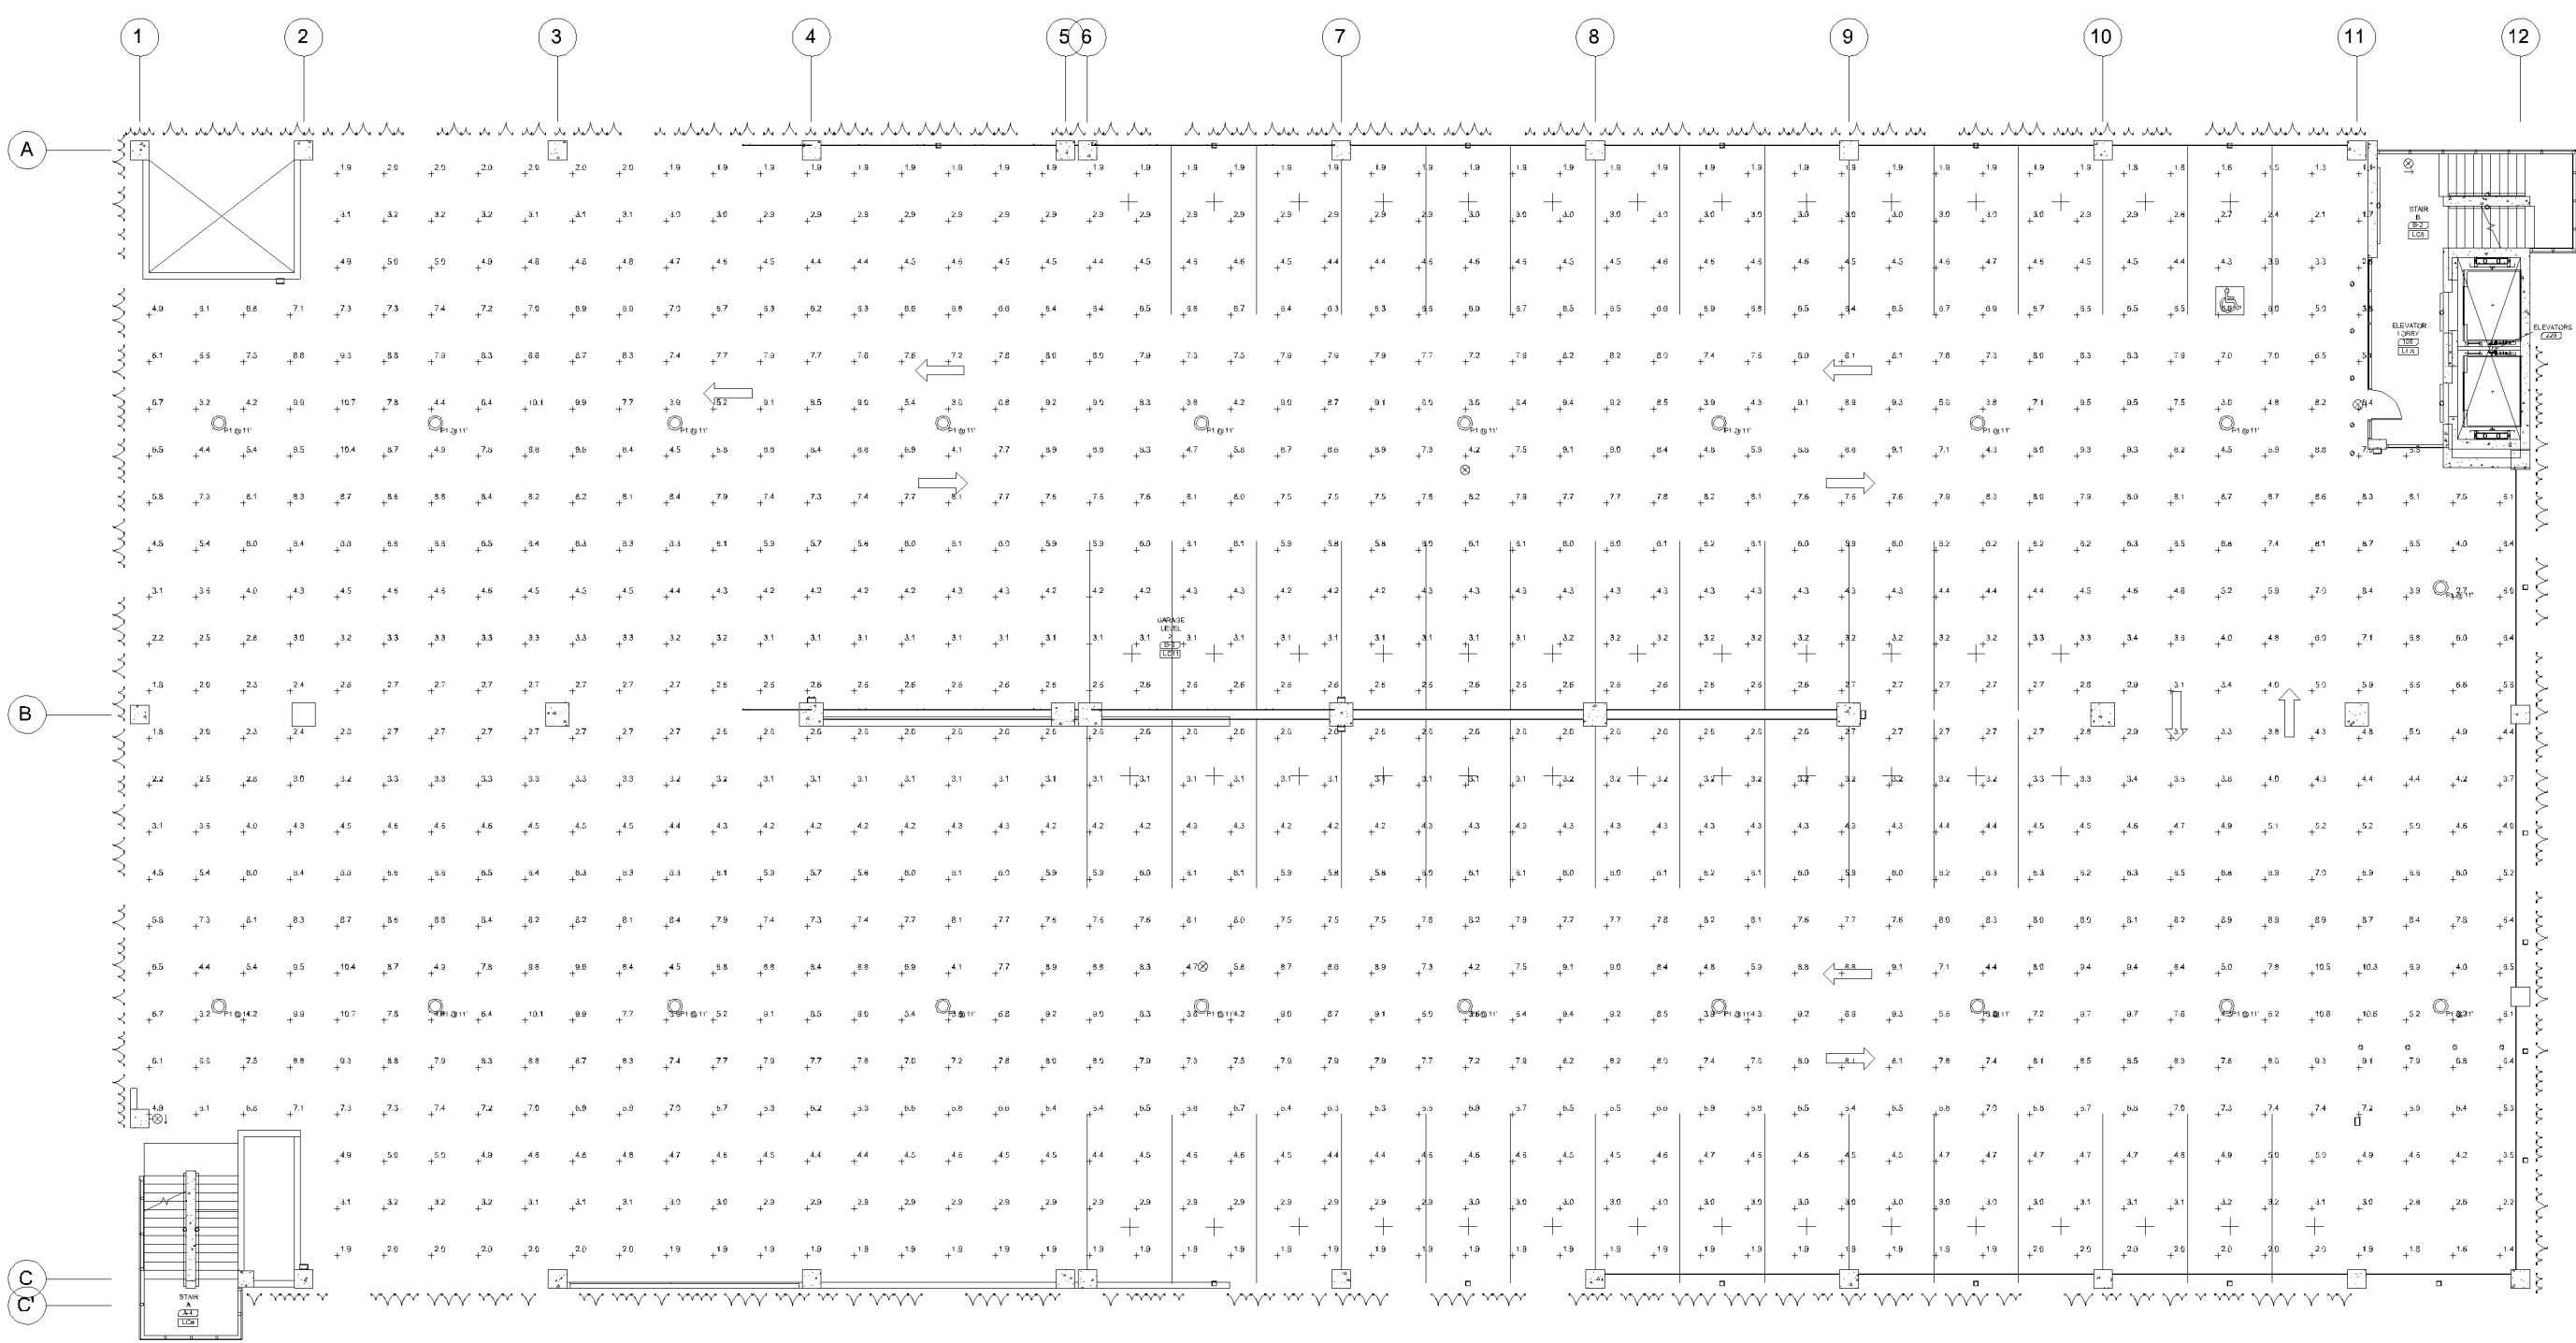


5 LEVEL 2-5 - PHOTOMETRICS - INITIAL
SCALE: 1" = 20'-0"

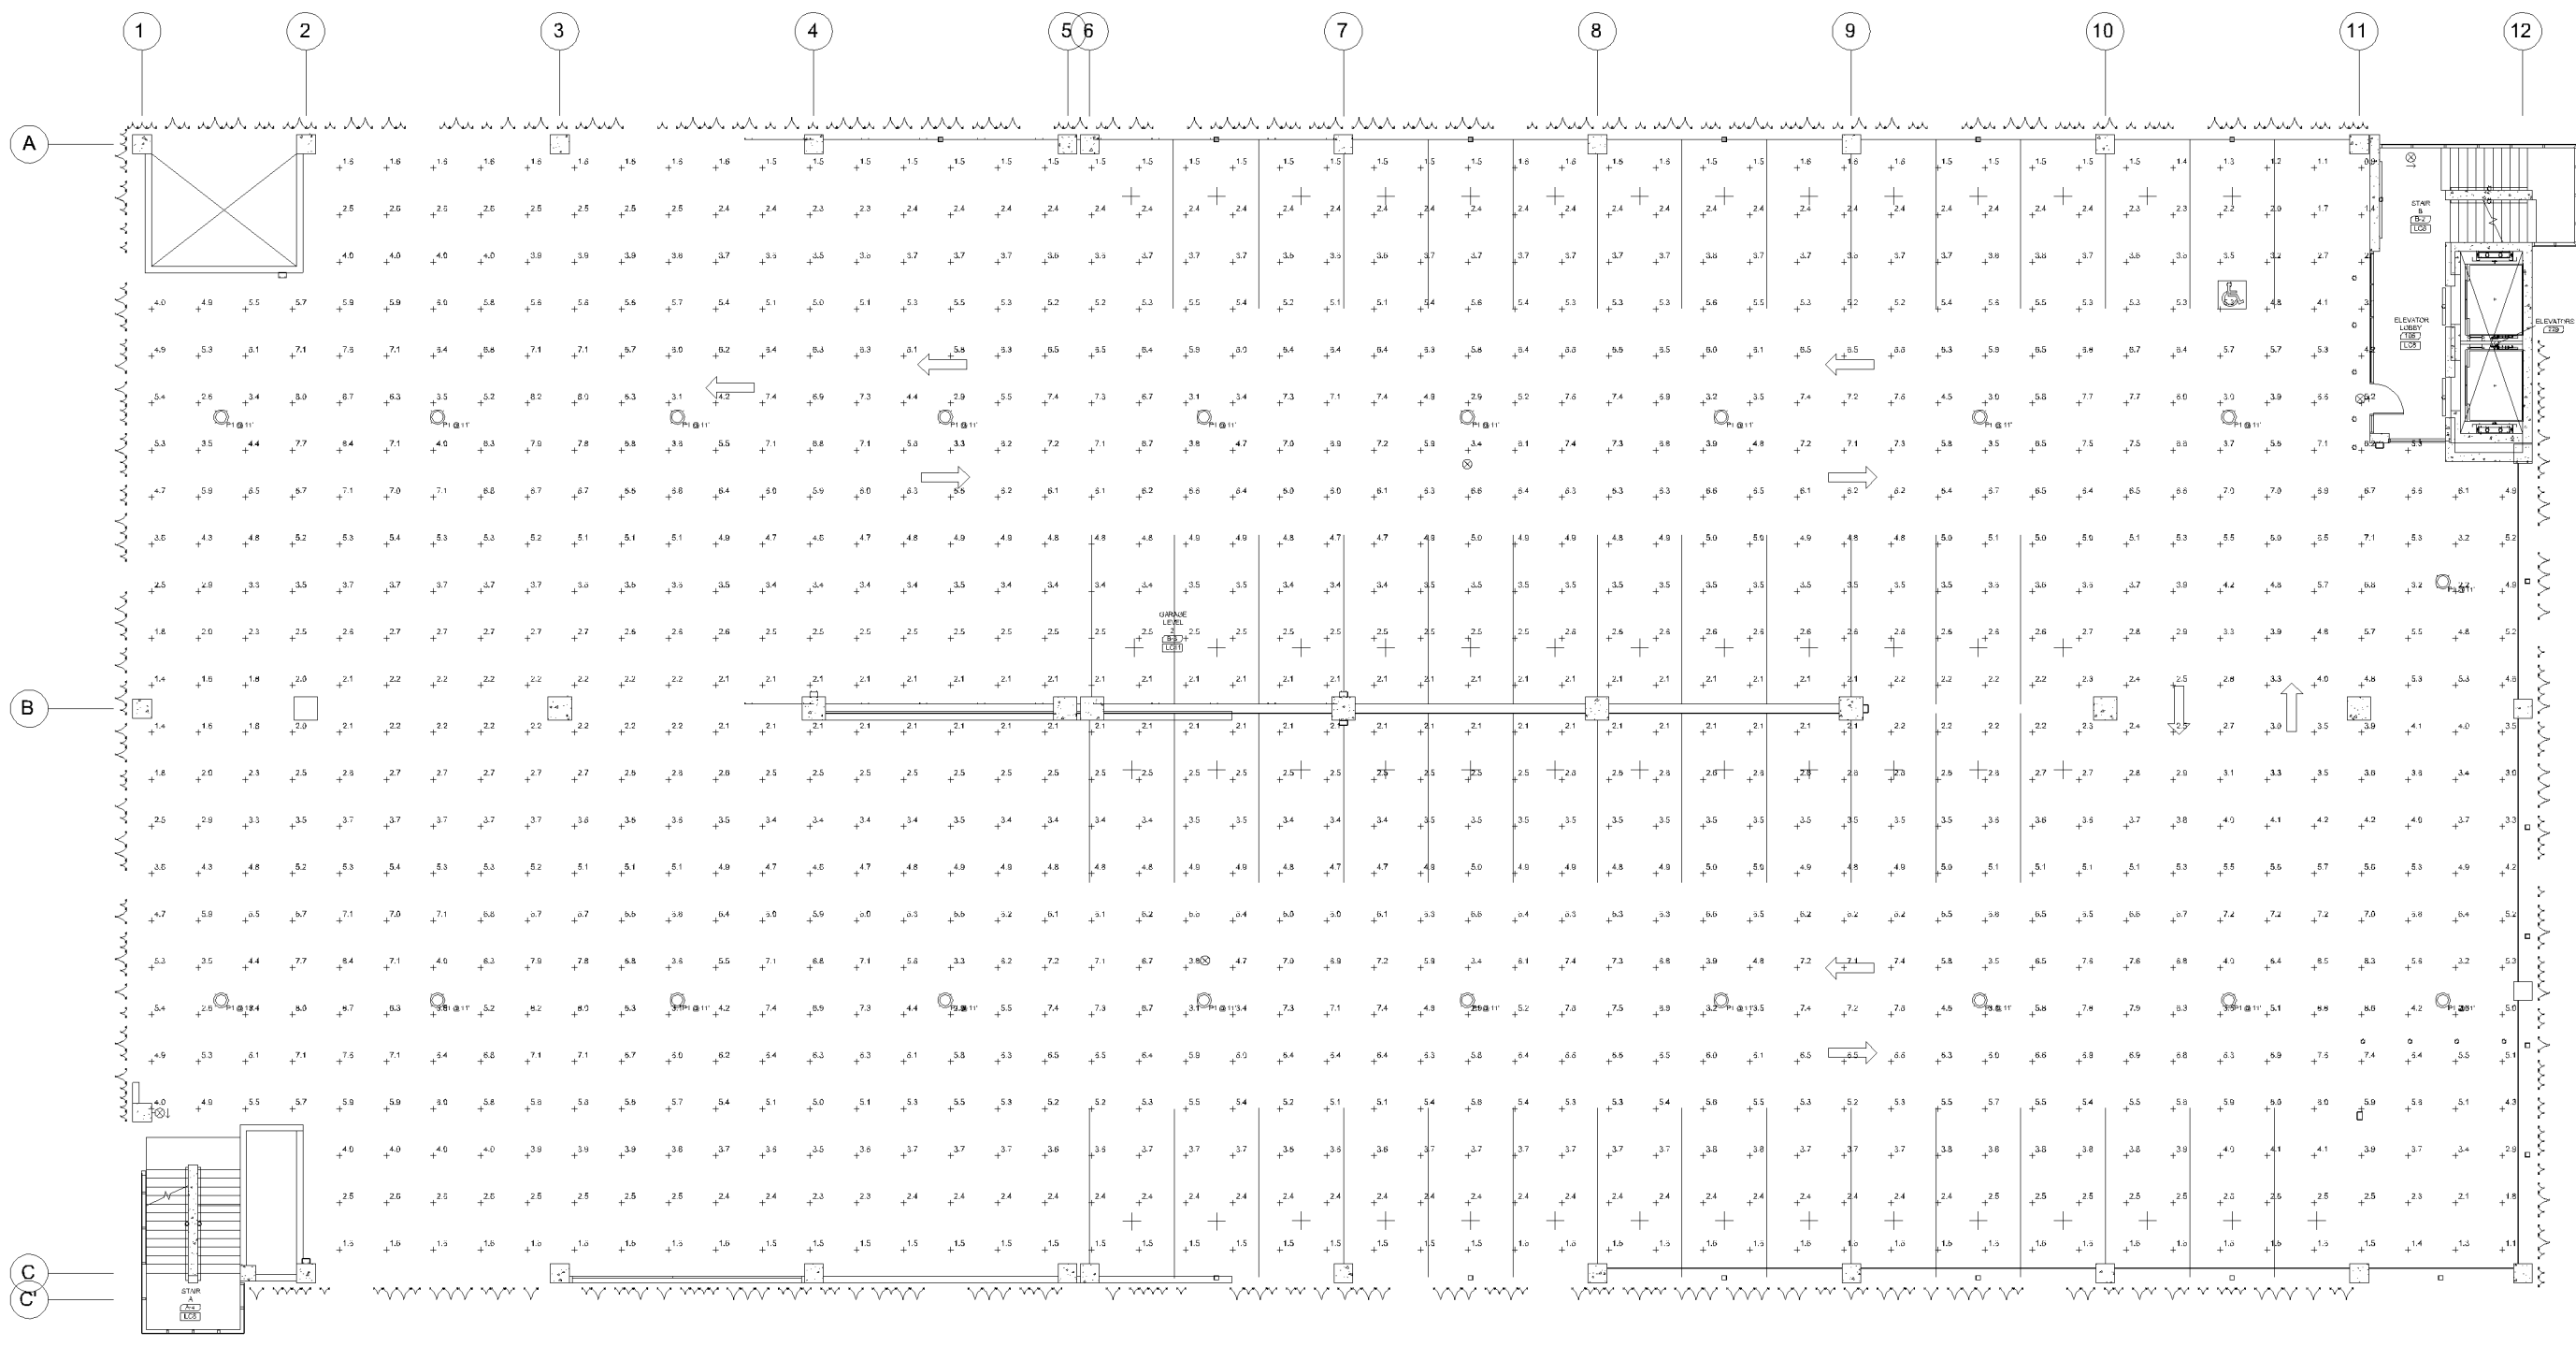

2 LEVEL 2-5 - PHOTOMETRICS - MAINTAINED
SCALE: NTS

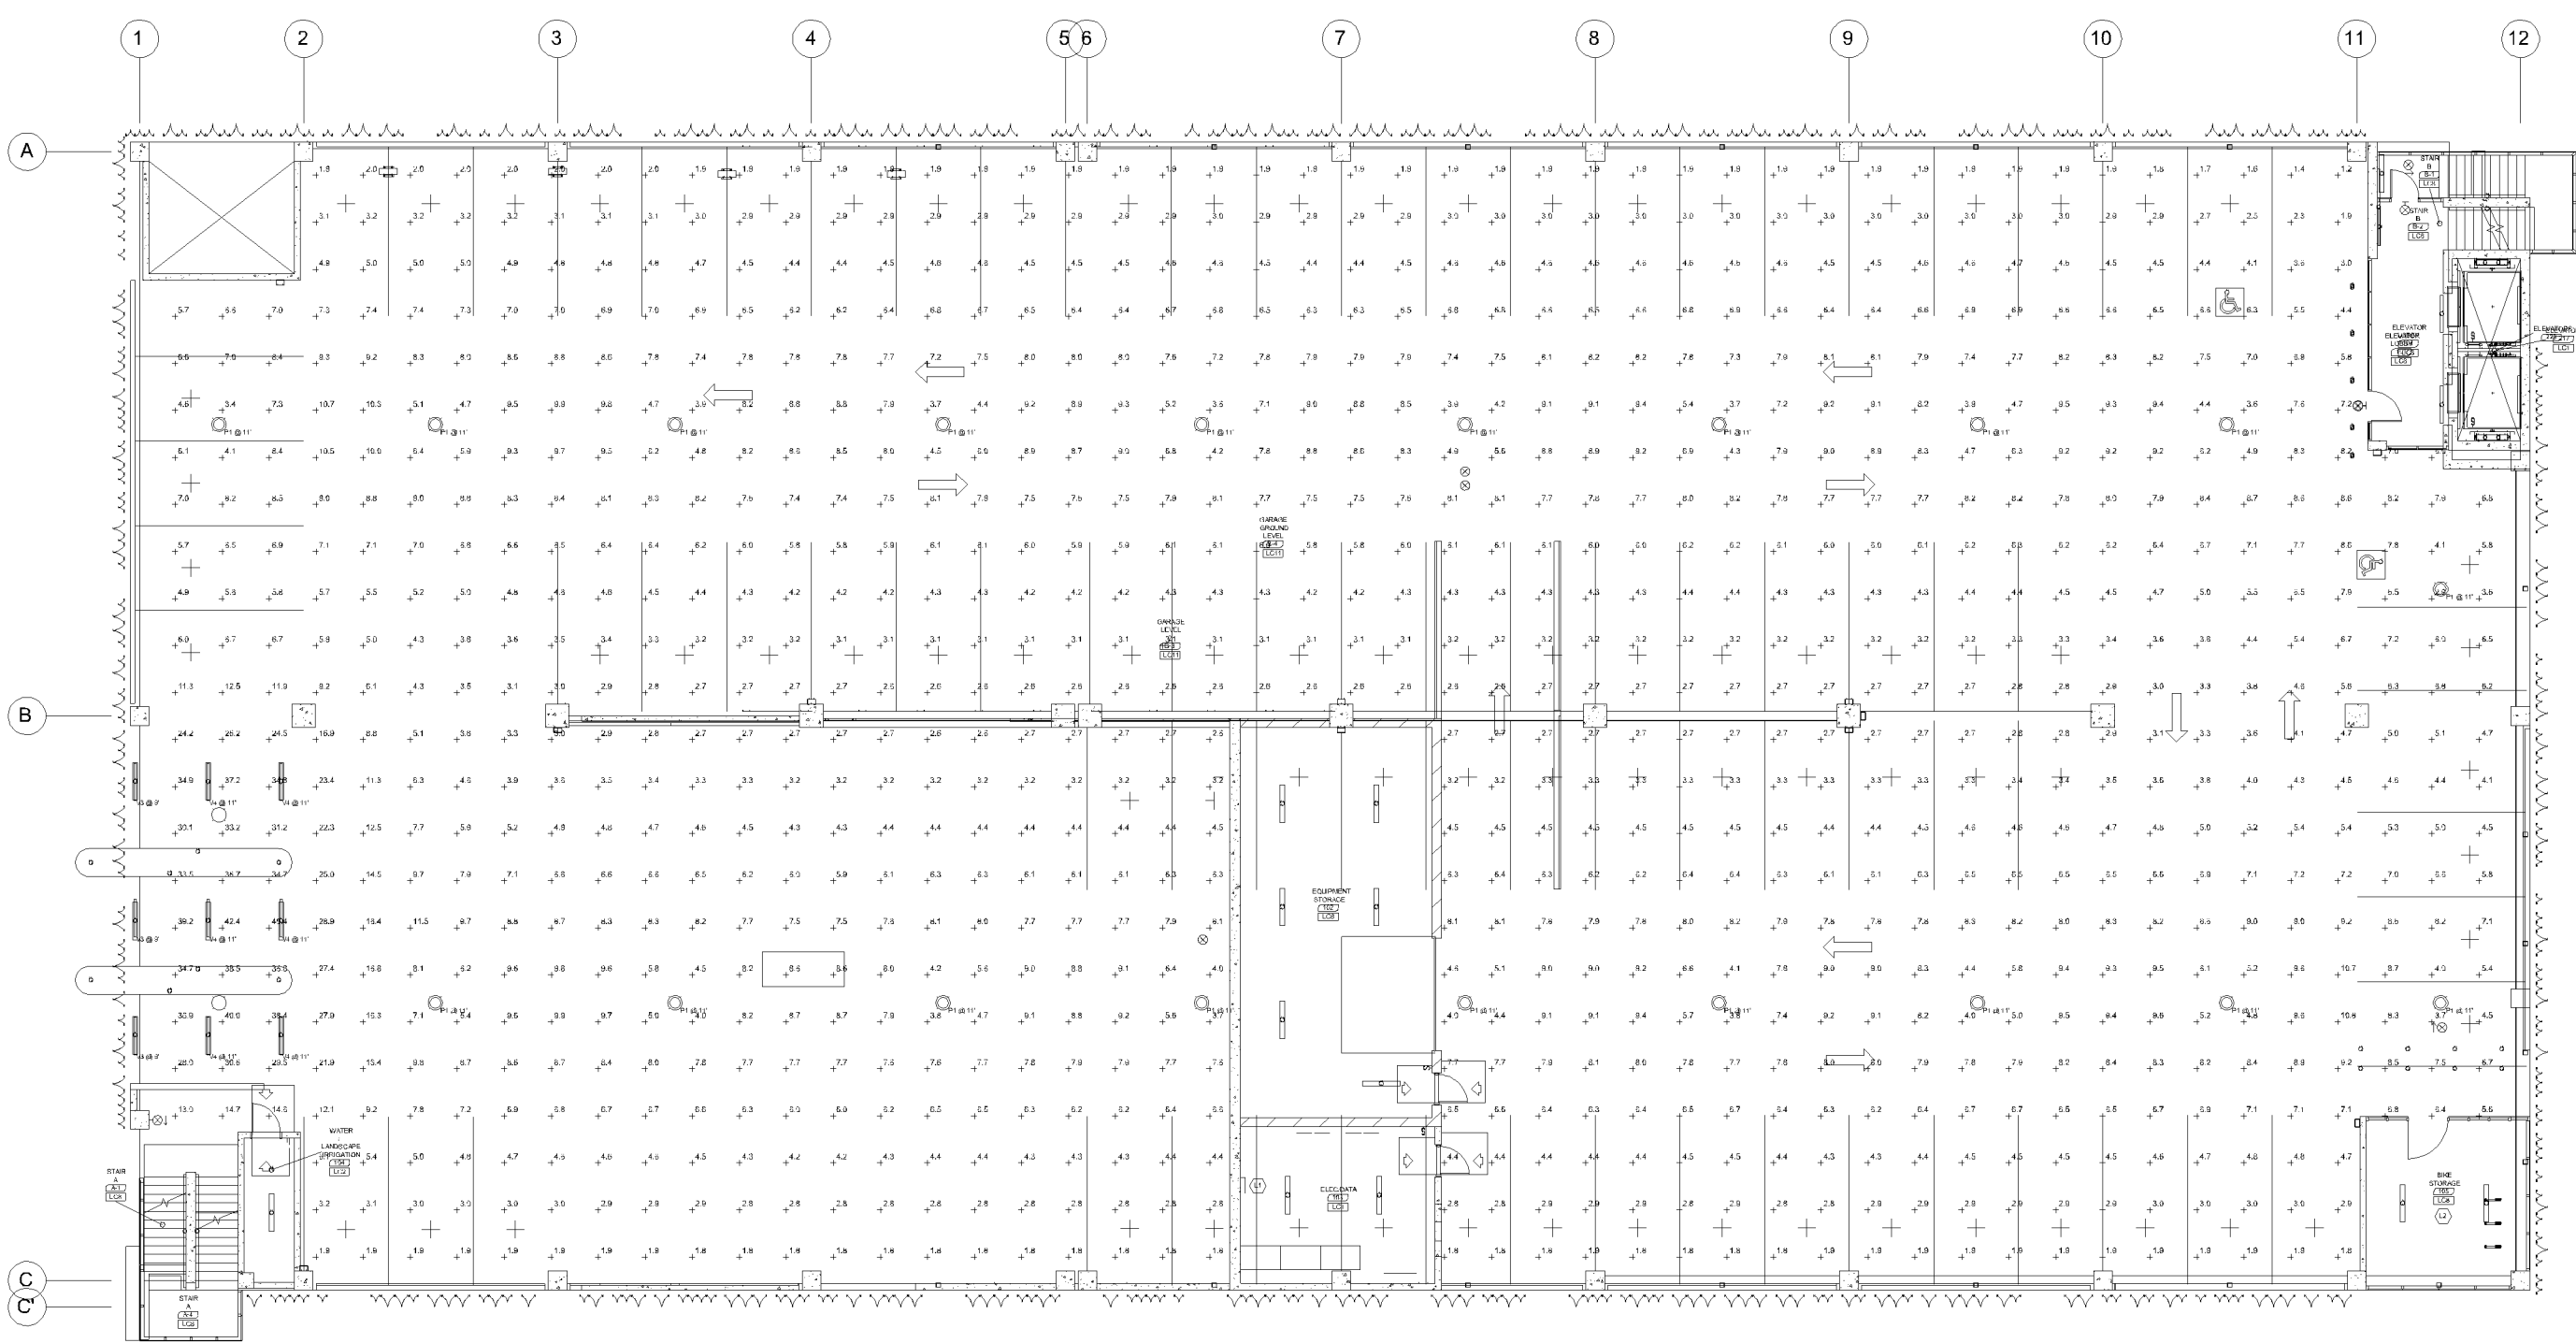

4 GROUND LEVEL - PHOTOMETRICS - INITIAL
SCALE: NTS

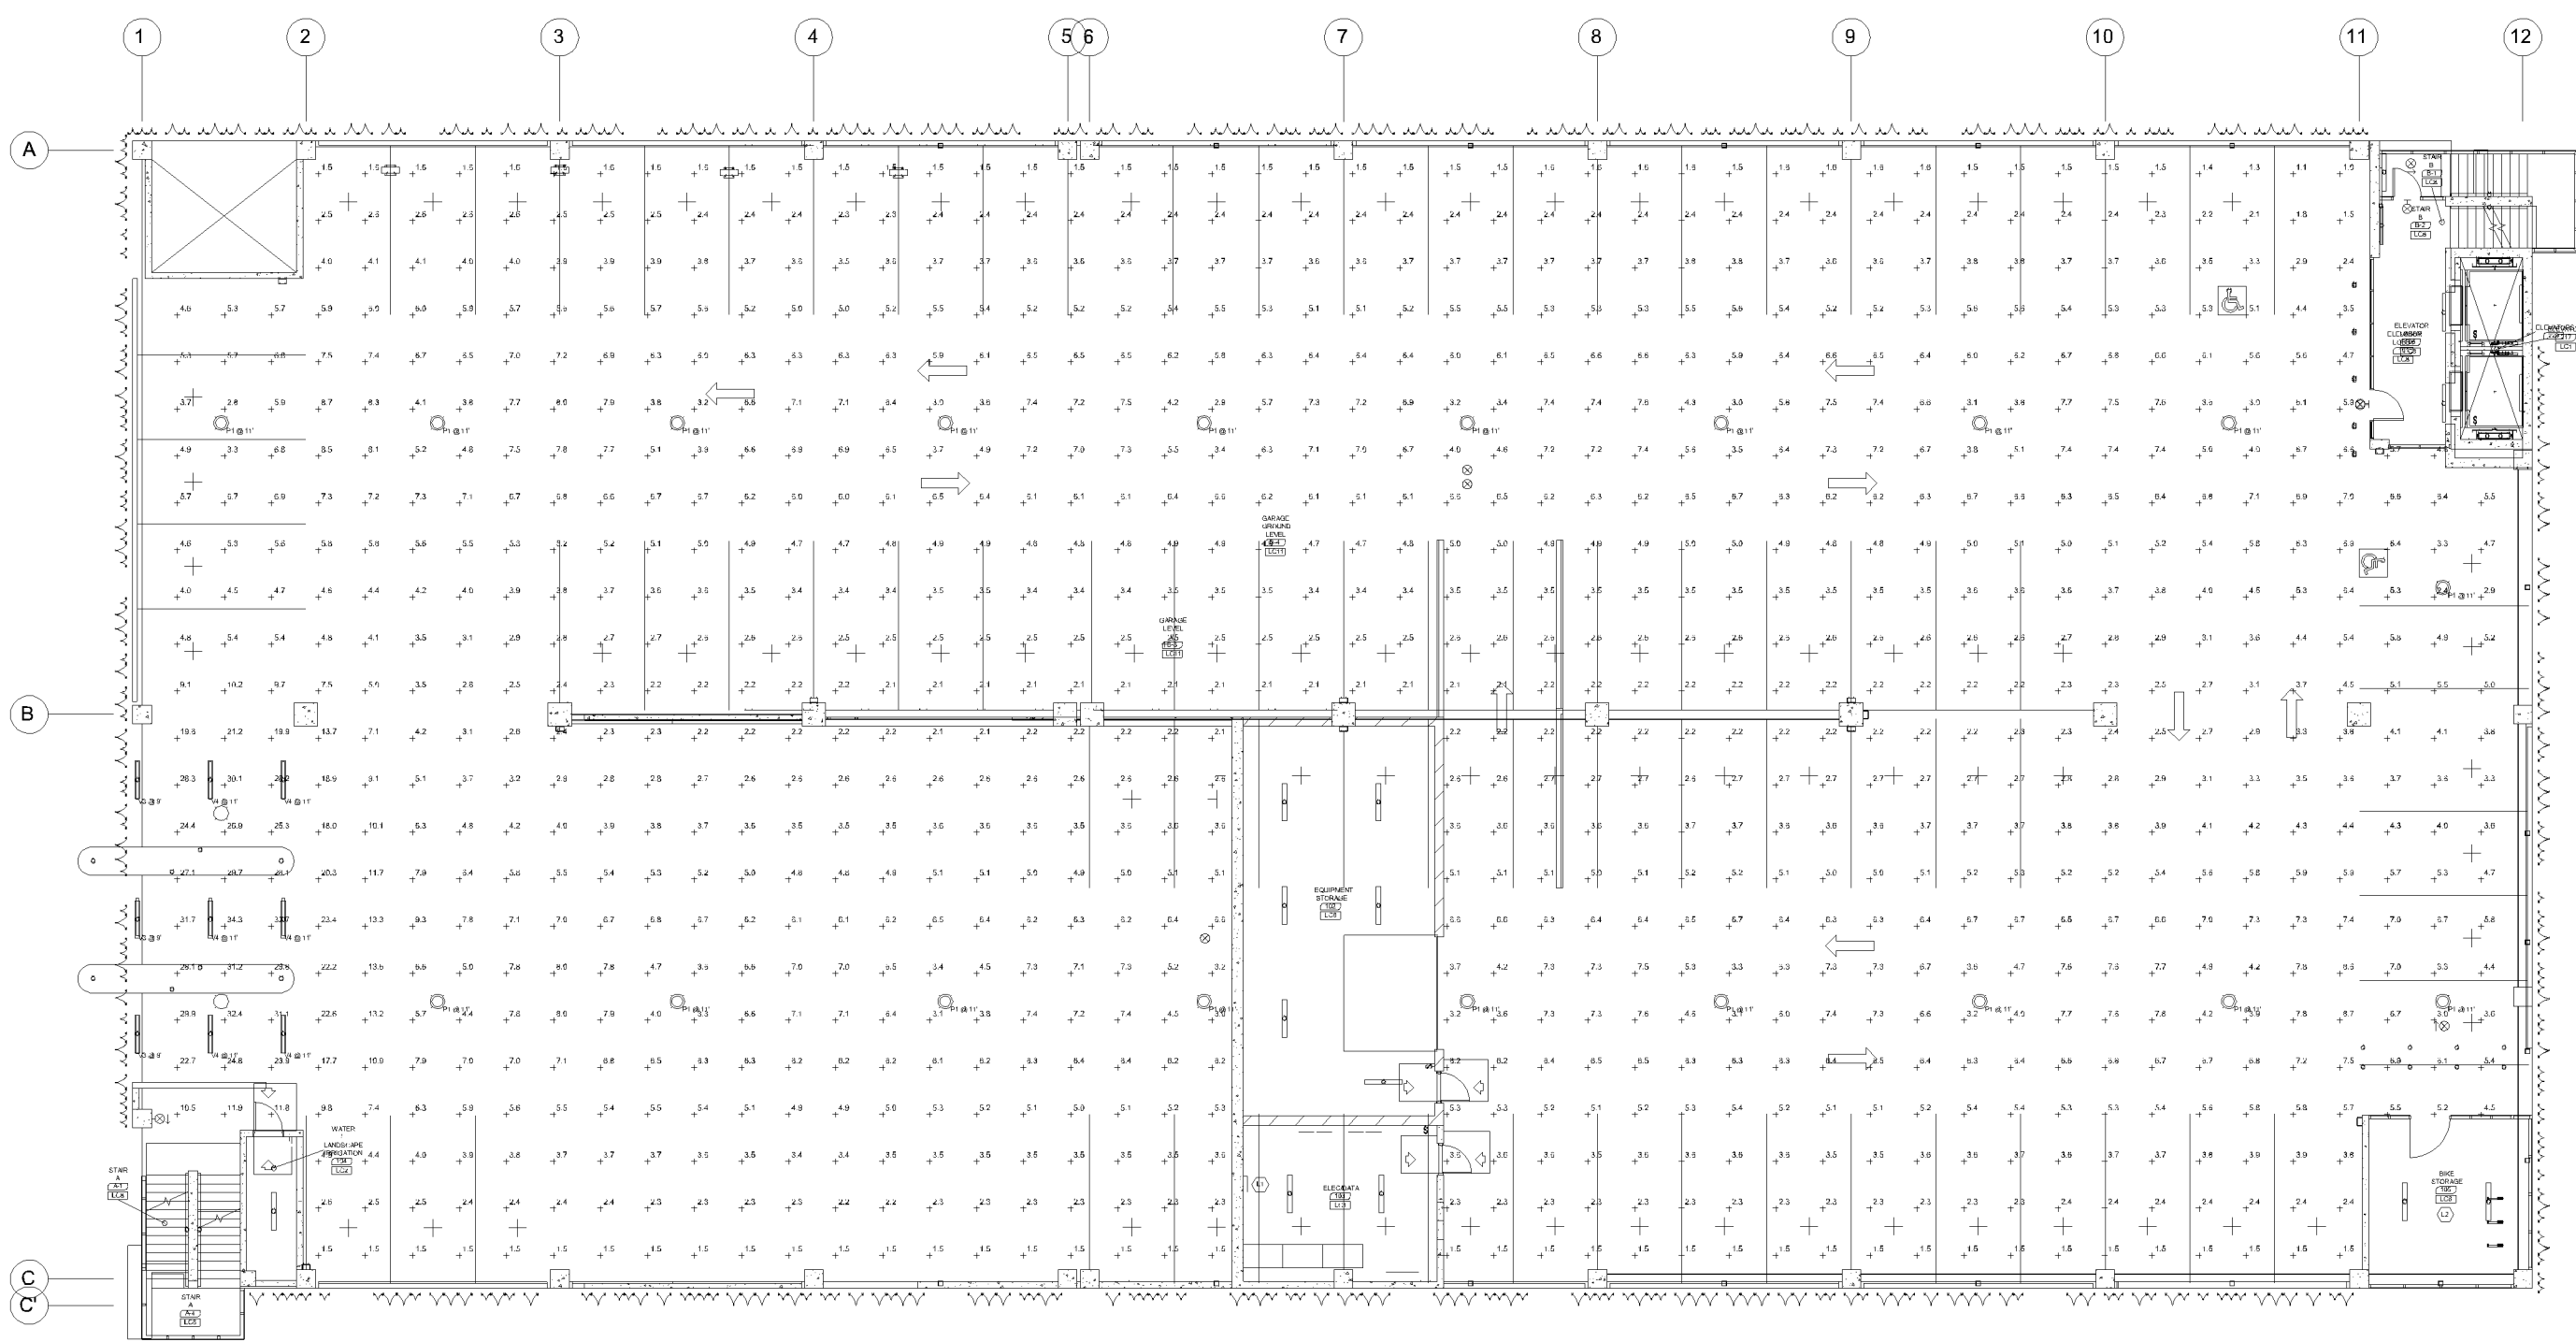

1 GROUND LEVEL - PHOTOMETRICS - MAINTAINED
SCALE: NTS

REVISIONS		
NO.	DATE	DESCRIPTION

I hereby certify that this plan, specification, or report was prepared by me or under my direct supervision and that I am a duly licensed Professional Engineer under the laws of the state of Minnesota

Signed:

Name: Josh Ortmann
License No.: 5/31/2024

phase	PERMIT SET
date	2/28/2024
PIC	MBS
drawn by	Author
project number	2022215
project name	

BLOOMINGTON
PARKING
STRUCTURE

Sheet Title
PHOTOMETRICS PLAN

Sheet Number

E0.01

Approved - Zoning Review
06/04/2024
M. Centinario